



GROUND FLOOR PLAN

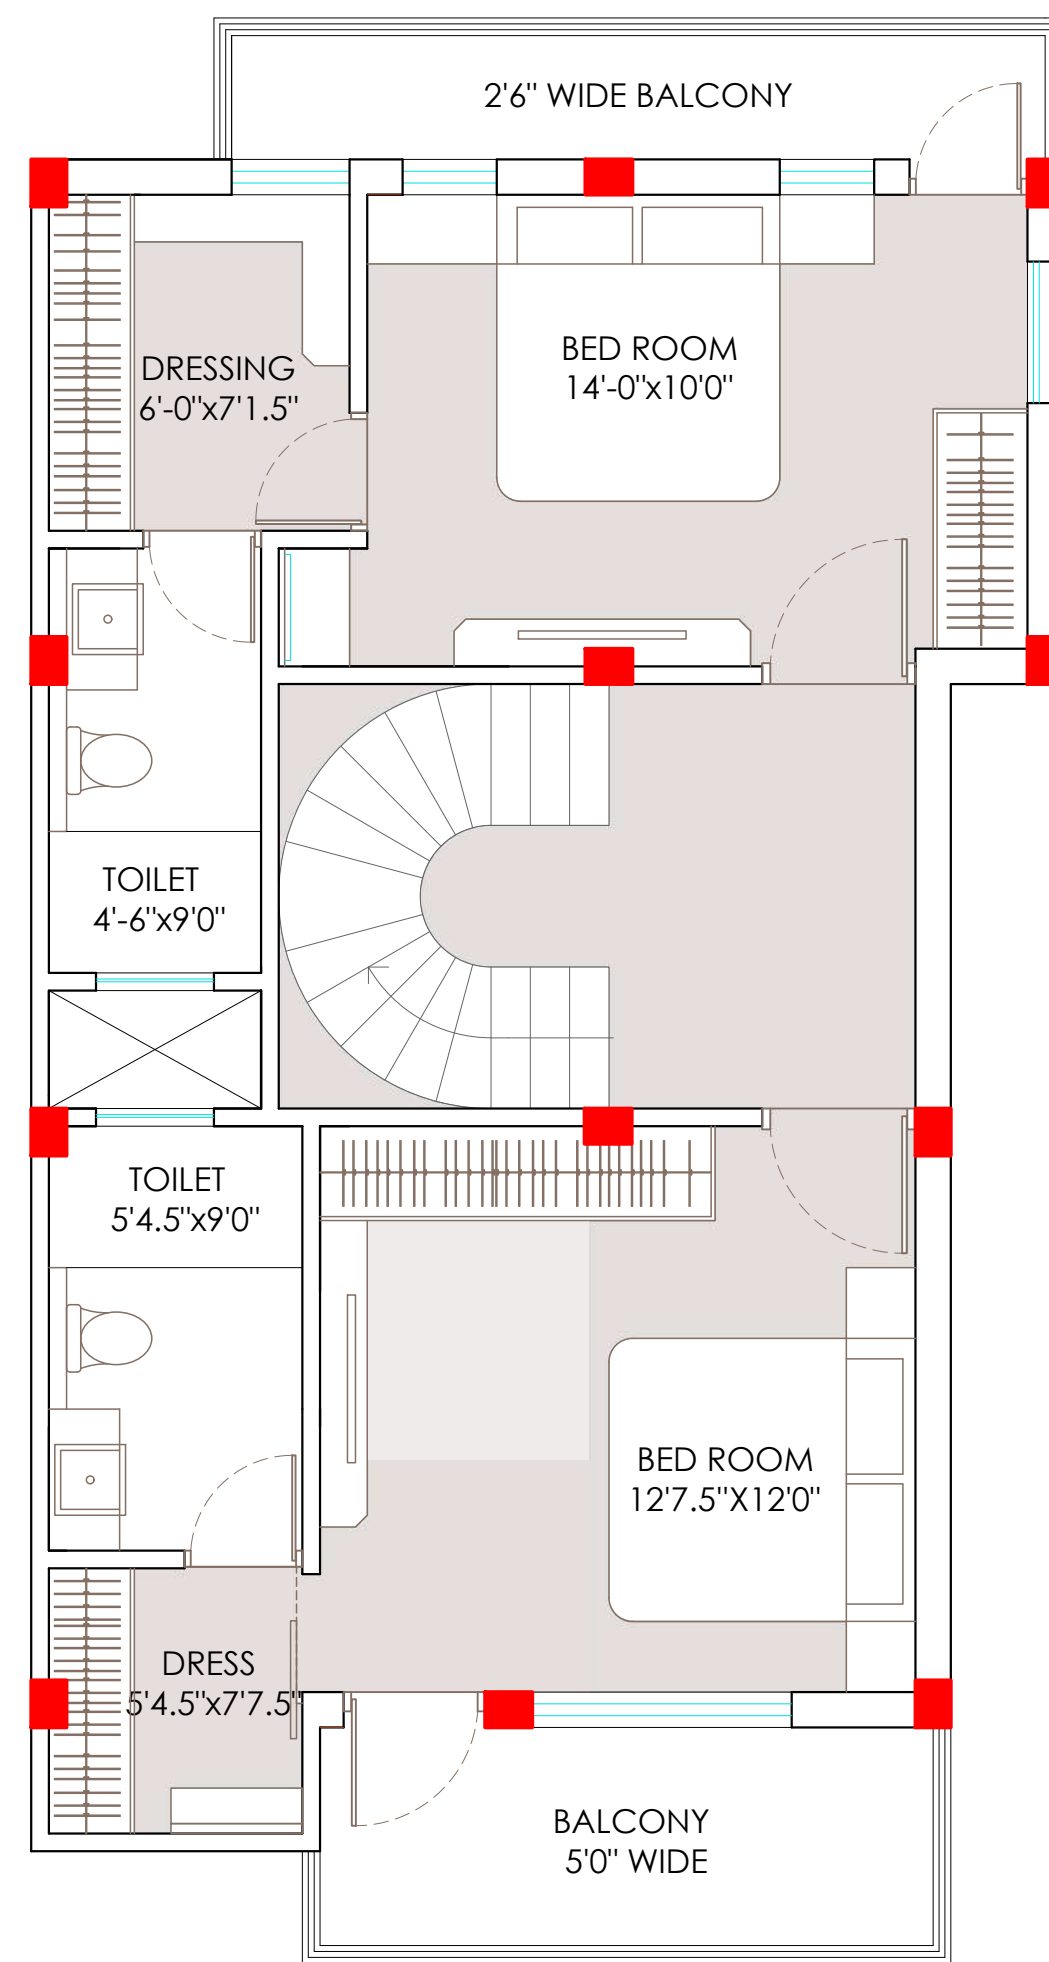

FIRST FLOOR.PLAN


GROUND FL BUILTUP AREA -651 SQ.FT
FIRST FL BUILTUP AREA -743 SQ.FT

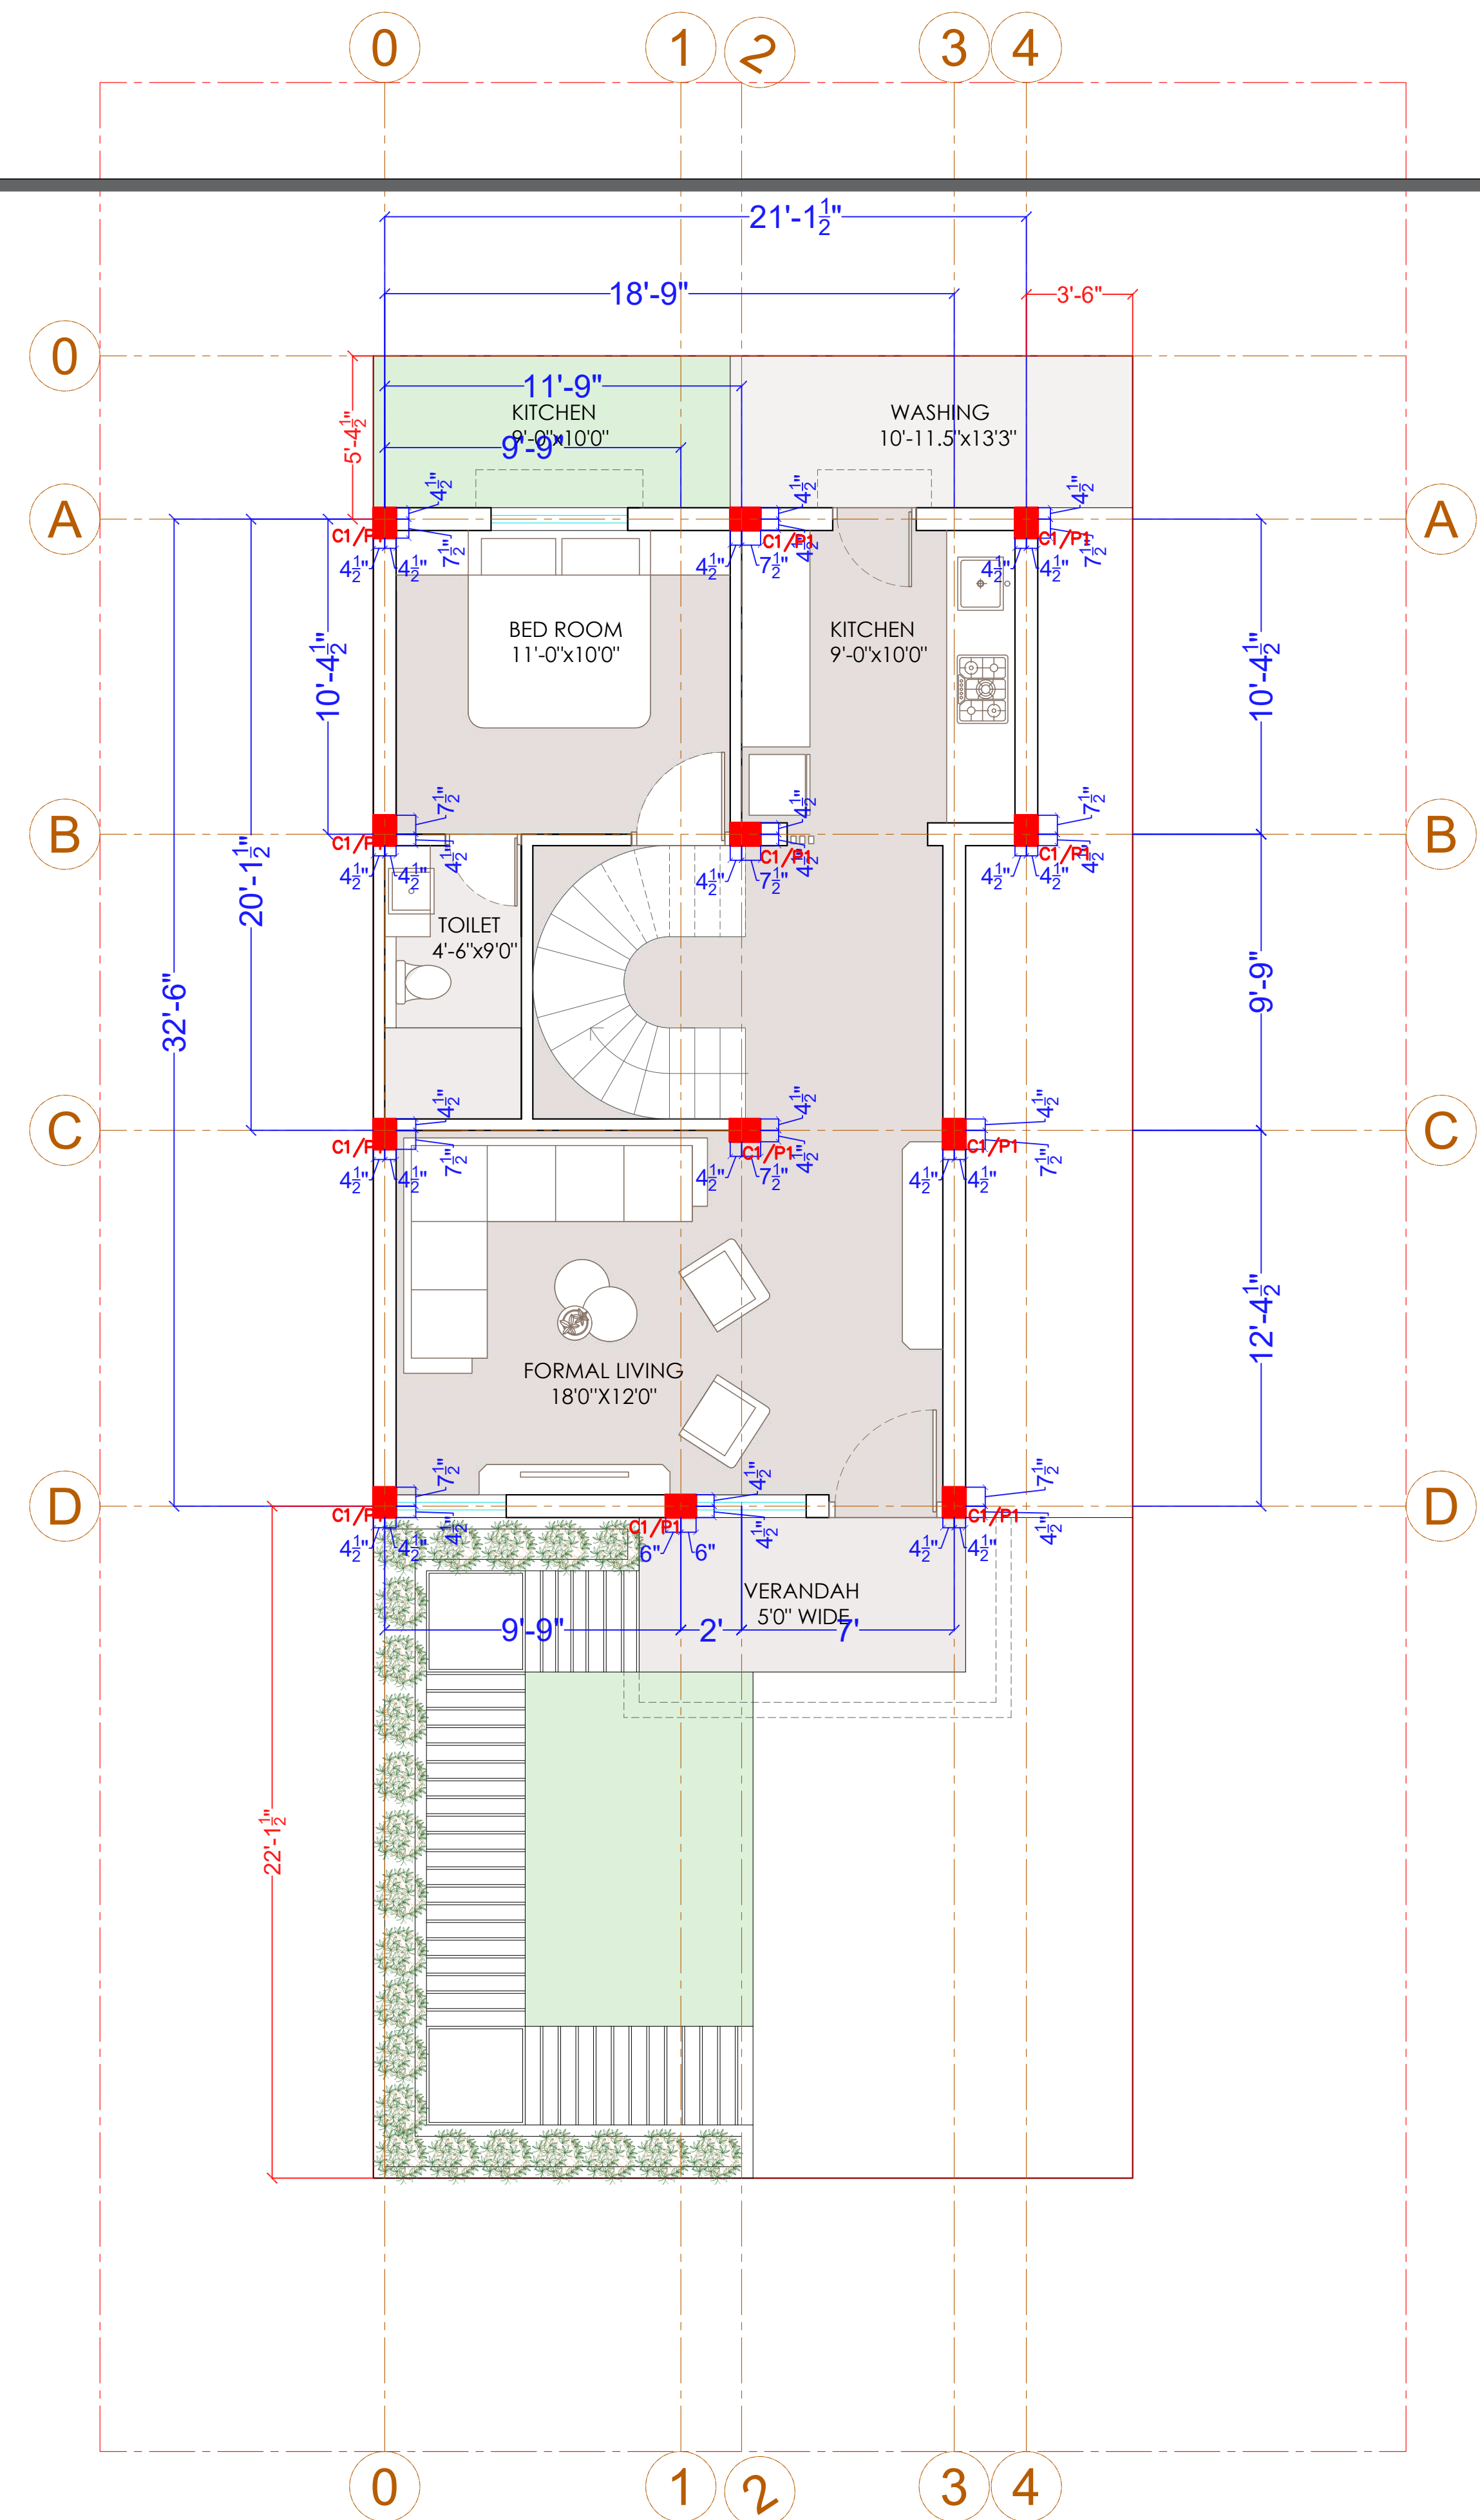

PROJECT NAME -
DRAWING NAME - PROPOSED PLAN

- Only written dimension should be followed.
- All dimension should be checked by contractor and any discrepancy in them shall be brought to the notice of Architect before execution.
- Structure details (beam & column) taken here are as given by structural engineer.
- All dimensions are feet & inch.

DRAWN BY - ADITYA
CHECKED BY - VINITA
DATE - 20 - 07 -2022


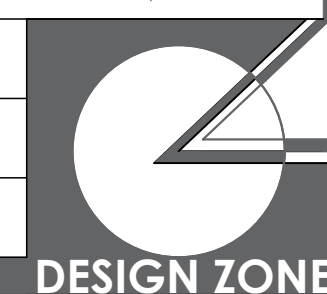


PROJECT NAME -
DRAWING NAME - PROPOSED PLAN

- Only written dimension should be followed.
- All dimension should be checked by contractor and any discrepancy in them shall be brought to the notice of Architect before execution.
- Structure details (beam & column) taken here are as given by structural engineer.
- All dimensions are feet & inch.

DRAWN BY - ADITYA
CHECKED BY - VINITA
DATE - 20 - 07 -2022



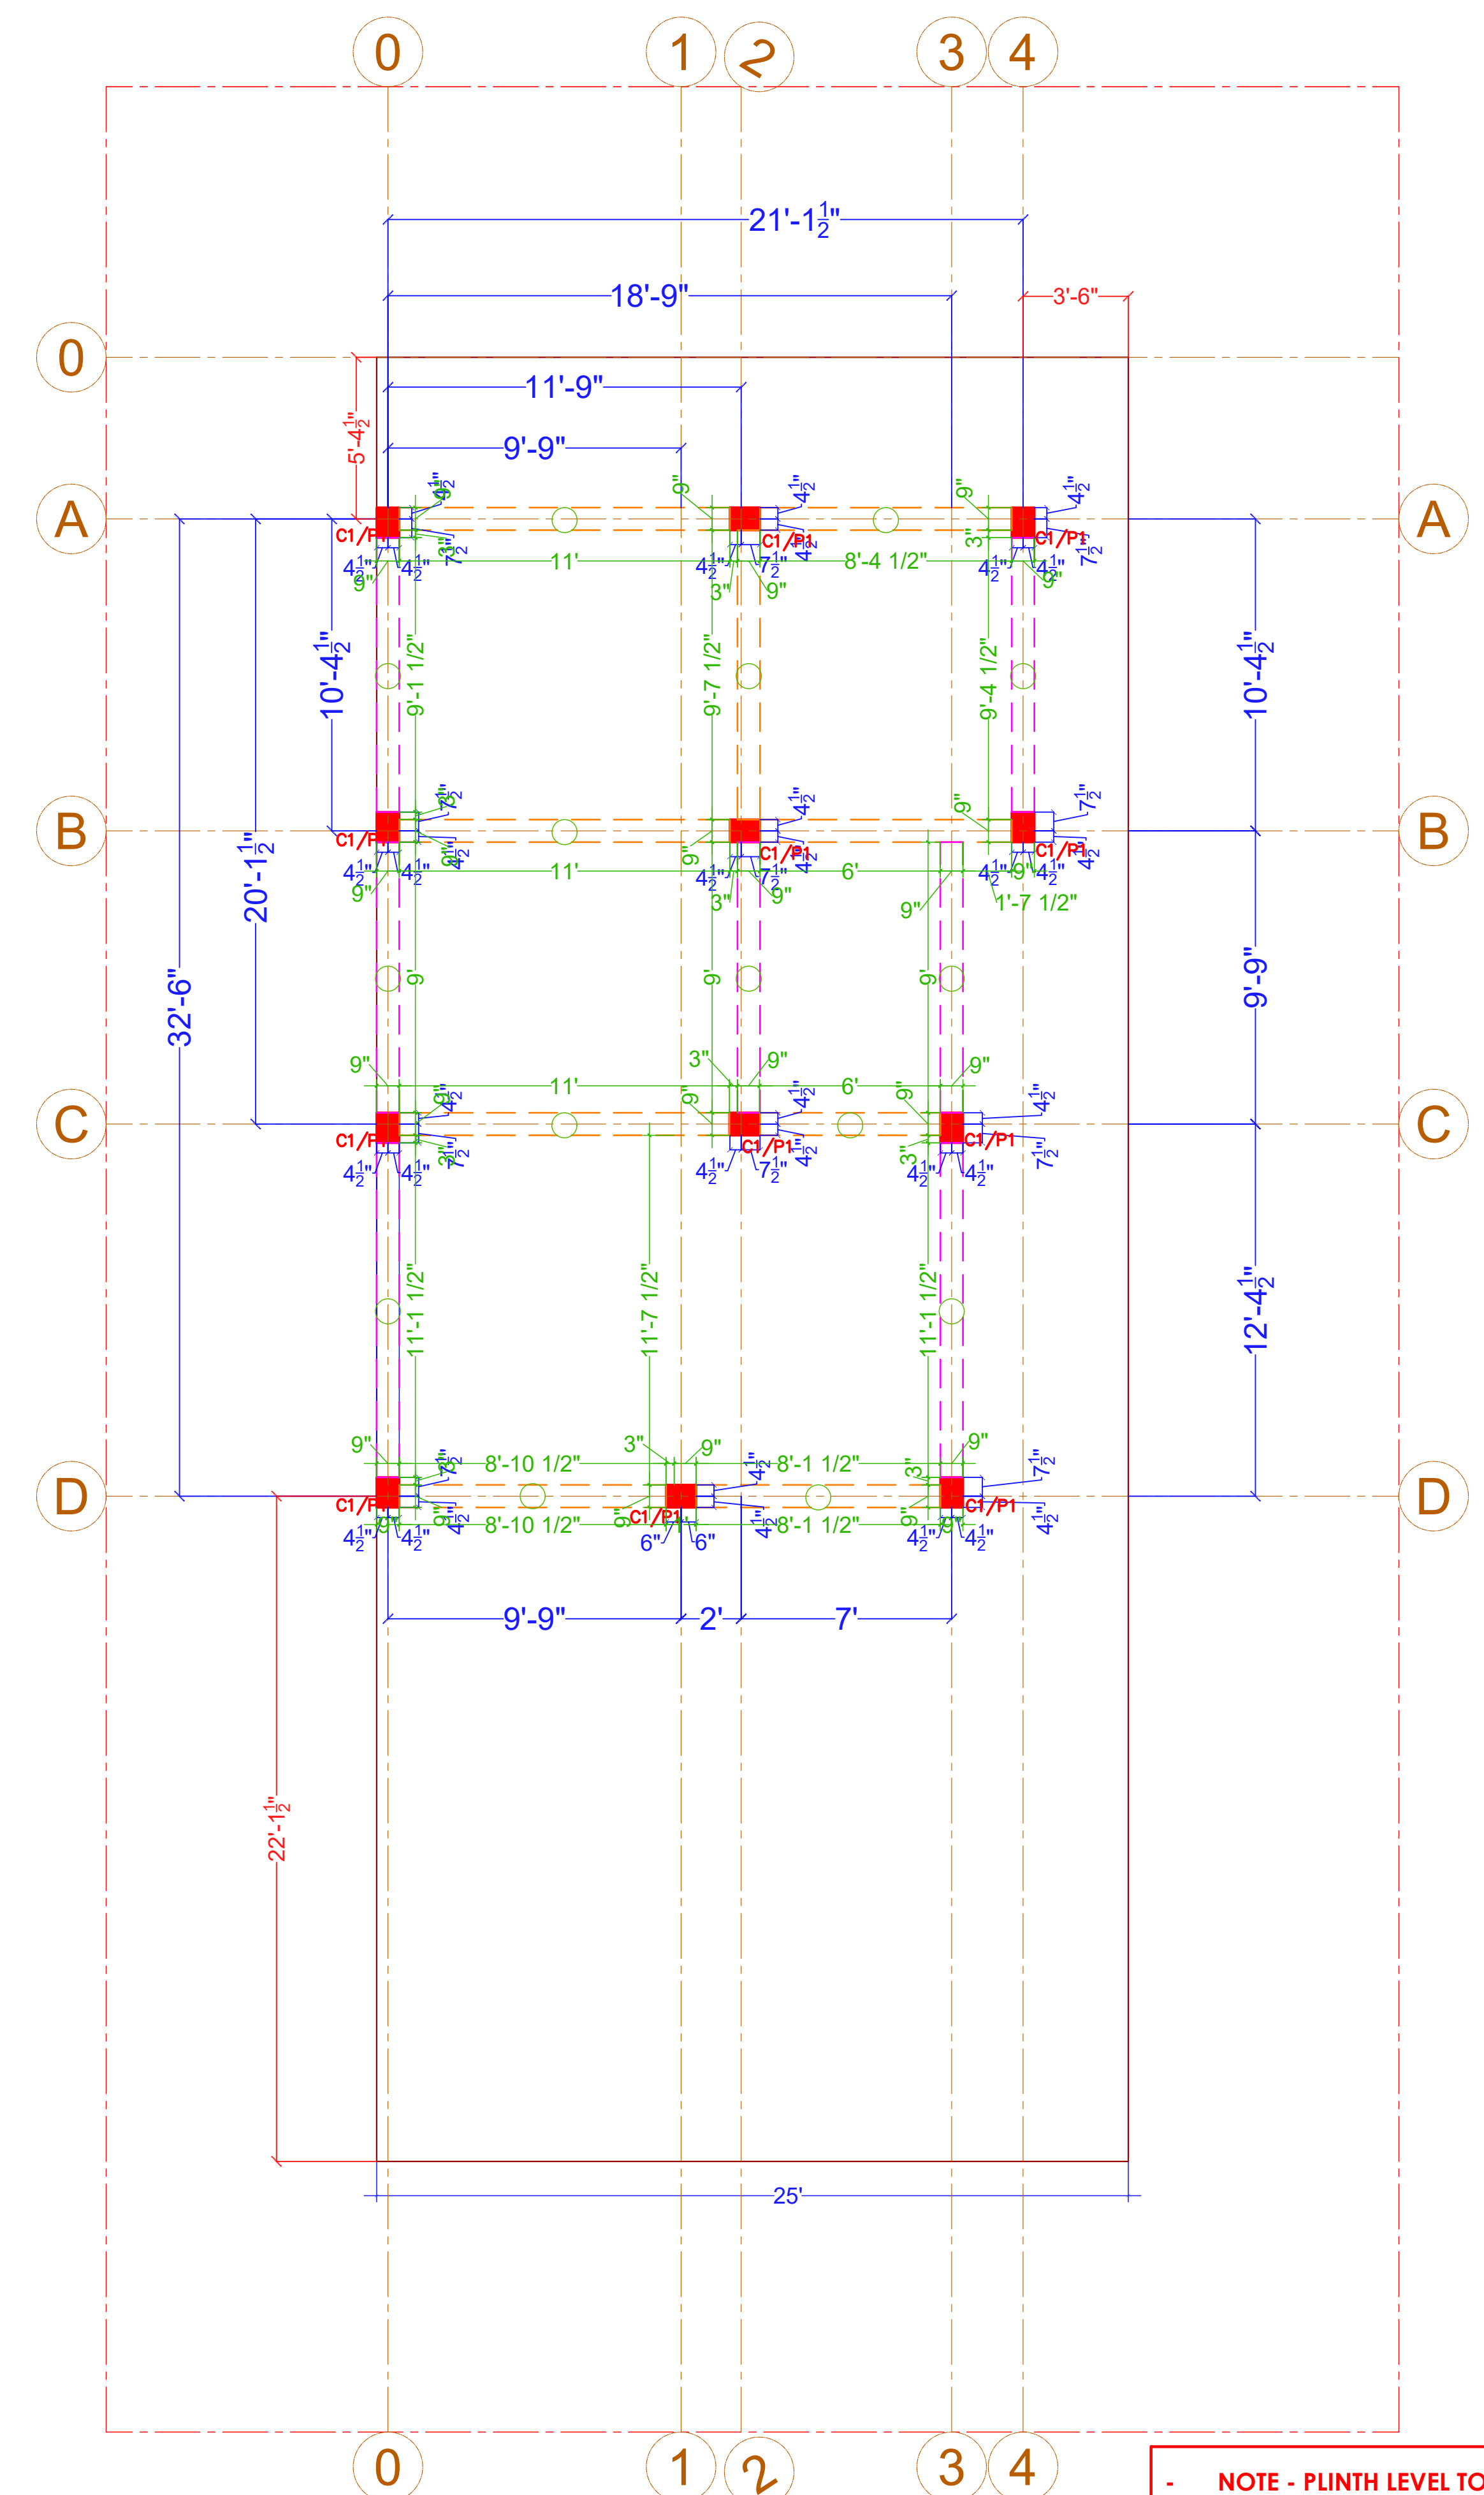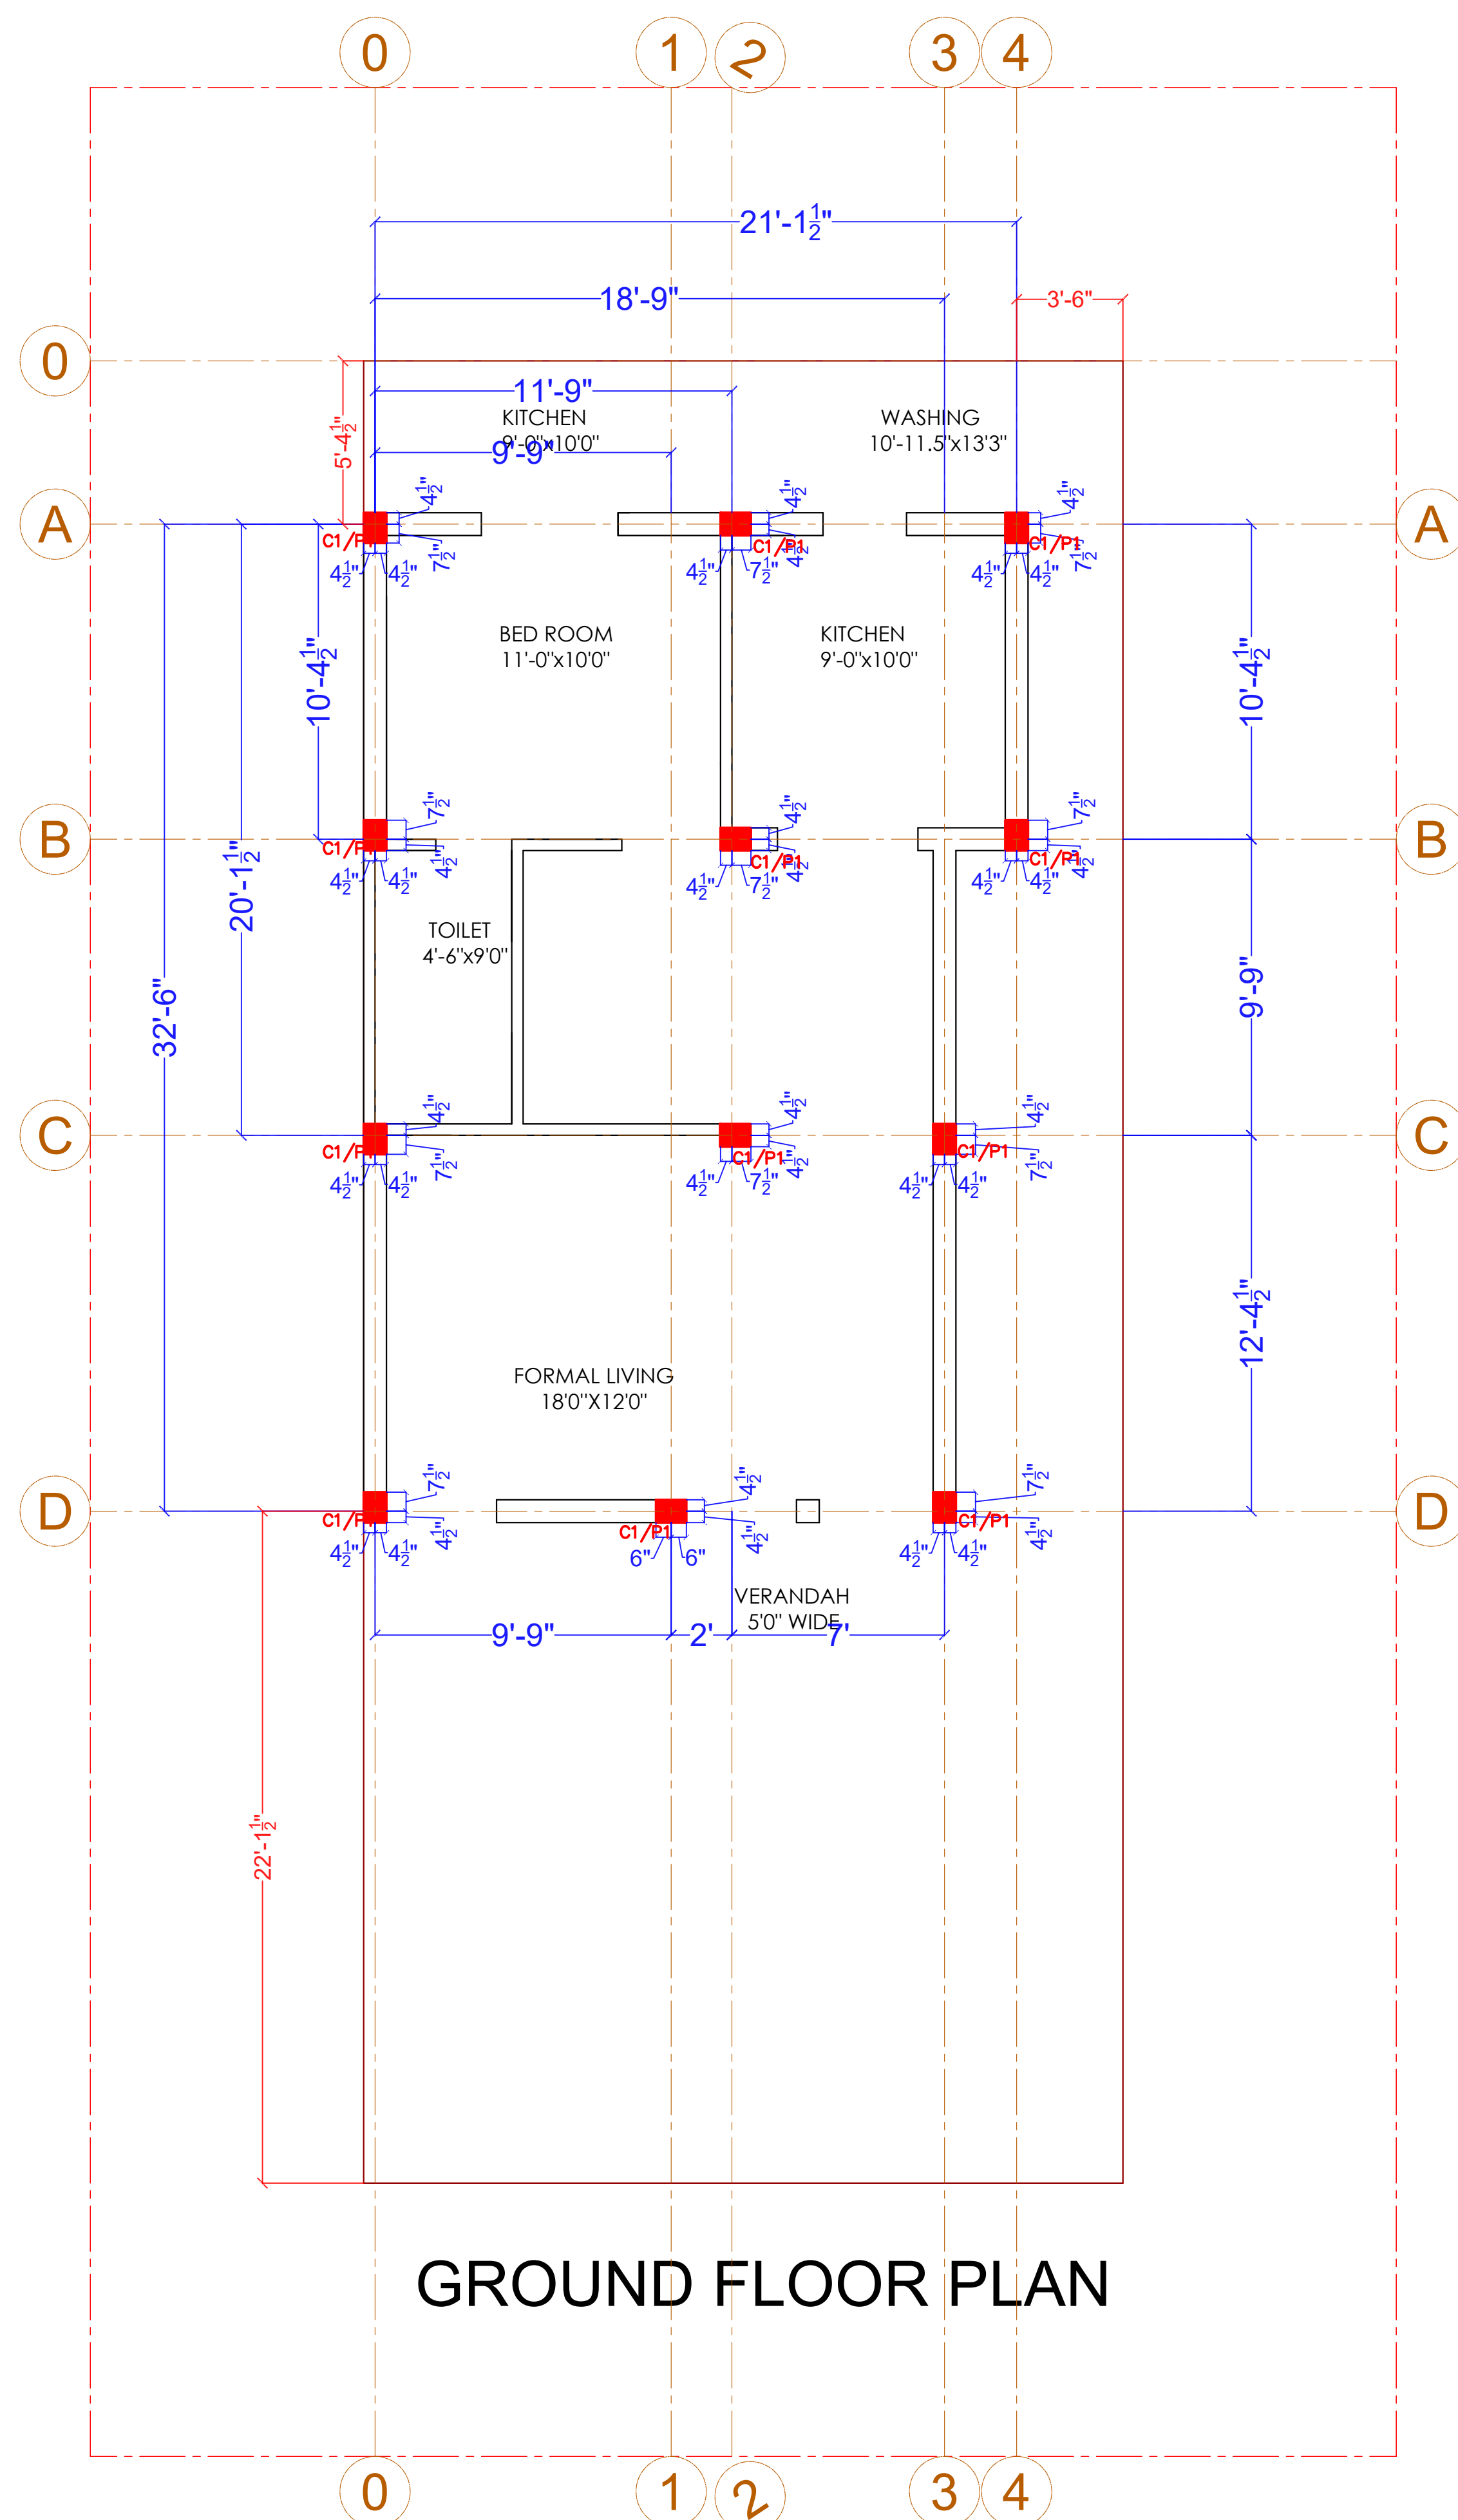

- NOTE - PLINTH LEVEL TO BE TAKEN HERE IS 2' ABOVE ROAD LEVEL

PROJECT NAME -

**DRAWING NAME - WORKING DRAWING -
CENTER LINE PLAN**

- Only written dimension should be followed.
- All dimension should be checked by contractor and any discrepancy in them shall be brought to the notice of Architect before execution.
- Structure details (beam & column) taken here are as given by structural engineer.
- All dimensions are feet & inch.

DRAWN BY - ADITYA

CHECKED BY- DEVENDRA

DATE - 20 - 07 -2022



PROJECT NAME - MR. SARIL UPADHYAY

**DRAWING NAME - WORKING DRAWING -
PLINTH BEAM DETAILS**


- | | |
|---|--|
| <ul style="list-style-type: none"> - Only written dimension should be followed. - All dimension should be checked by contractor and any discrepancy in them shall be brought to the notice of Architect before execution. - Structure details (beam & column) taken here are as given by structural engineer. - All dimensions are feet & inch. | |
|---|--|

DRAWN BY - ADITYA


CHECKED BY -DEVENDRA

DATE - 20 - 07 -2022



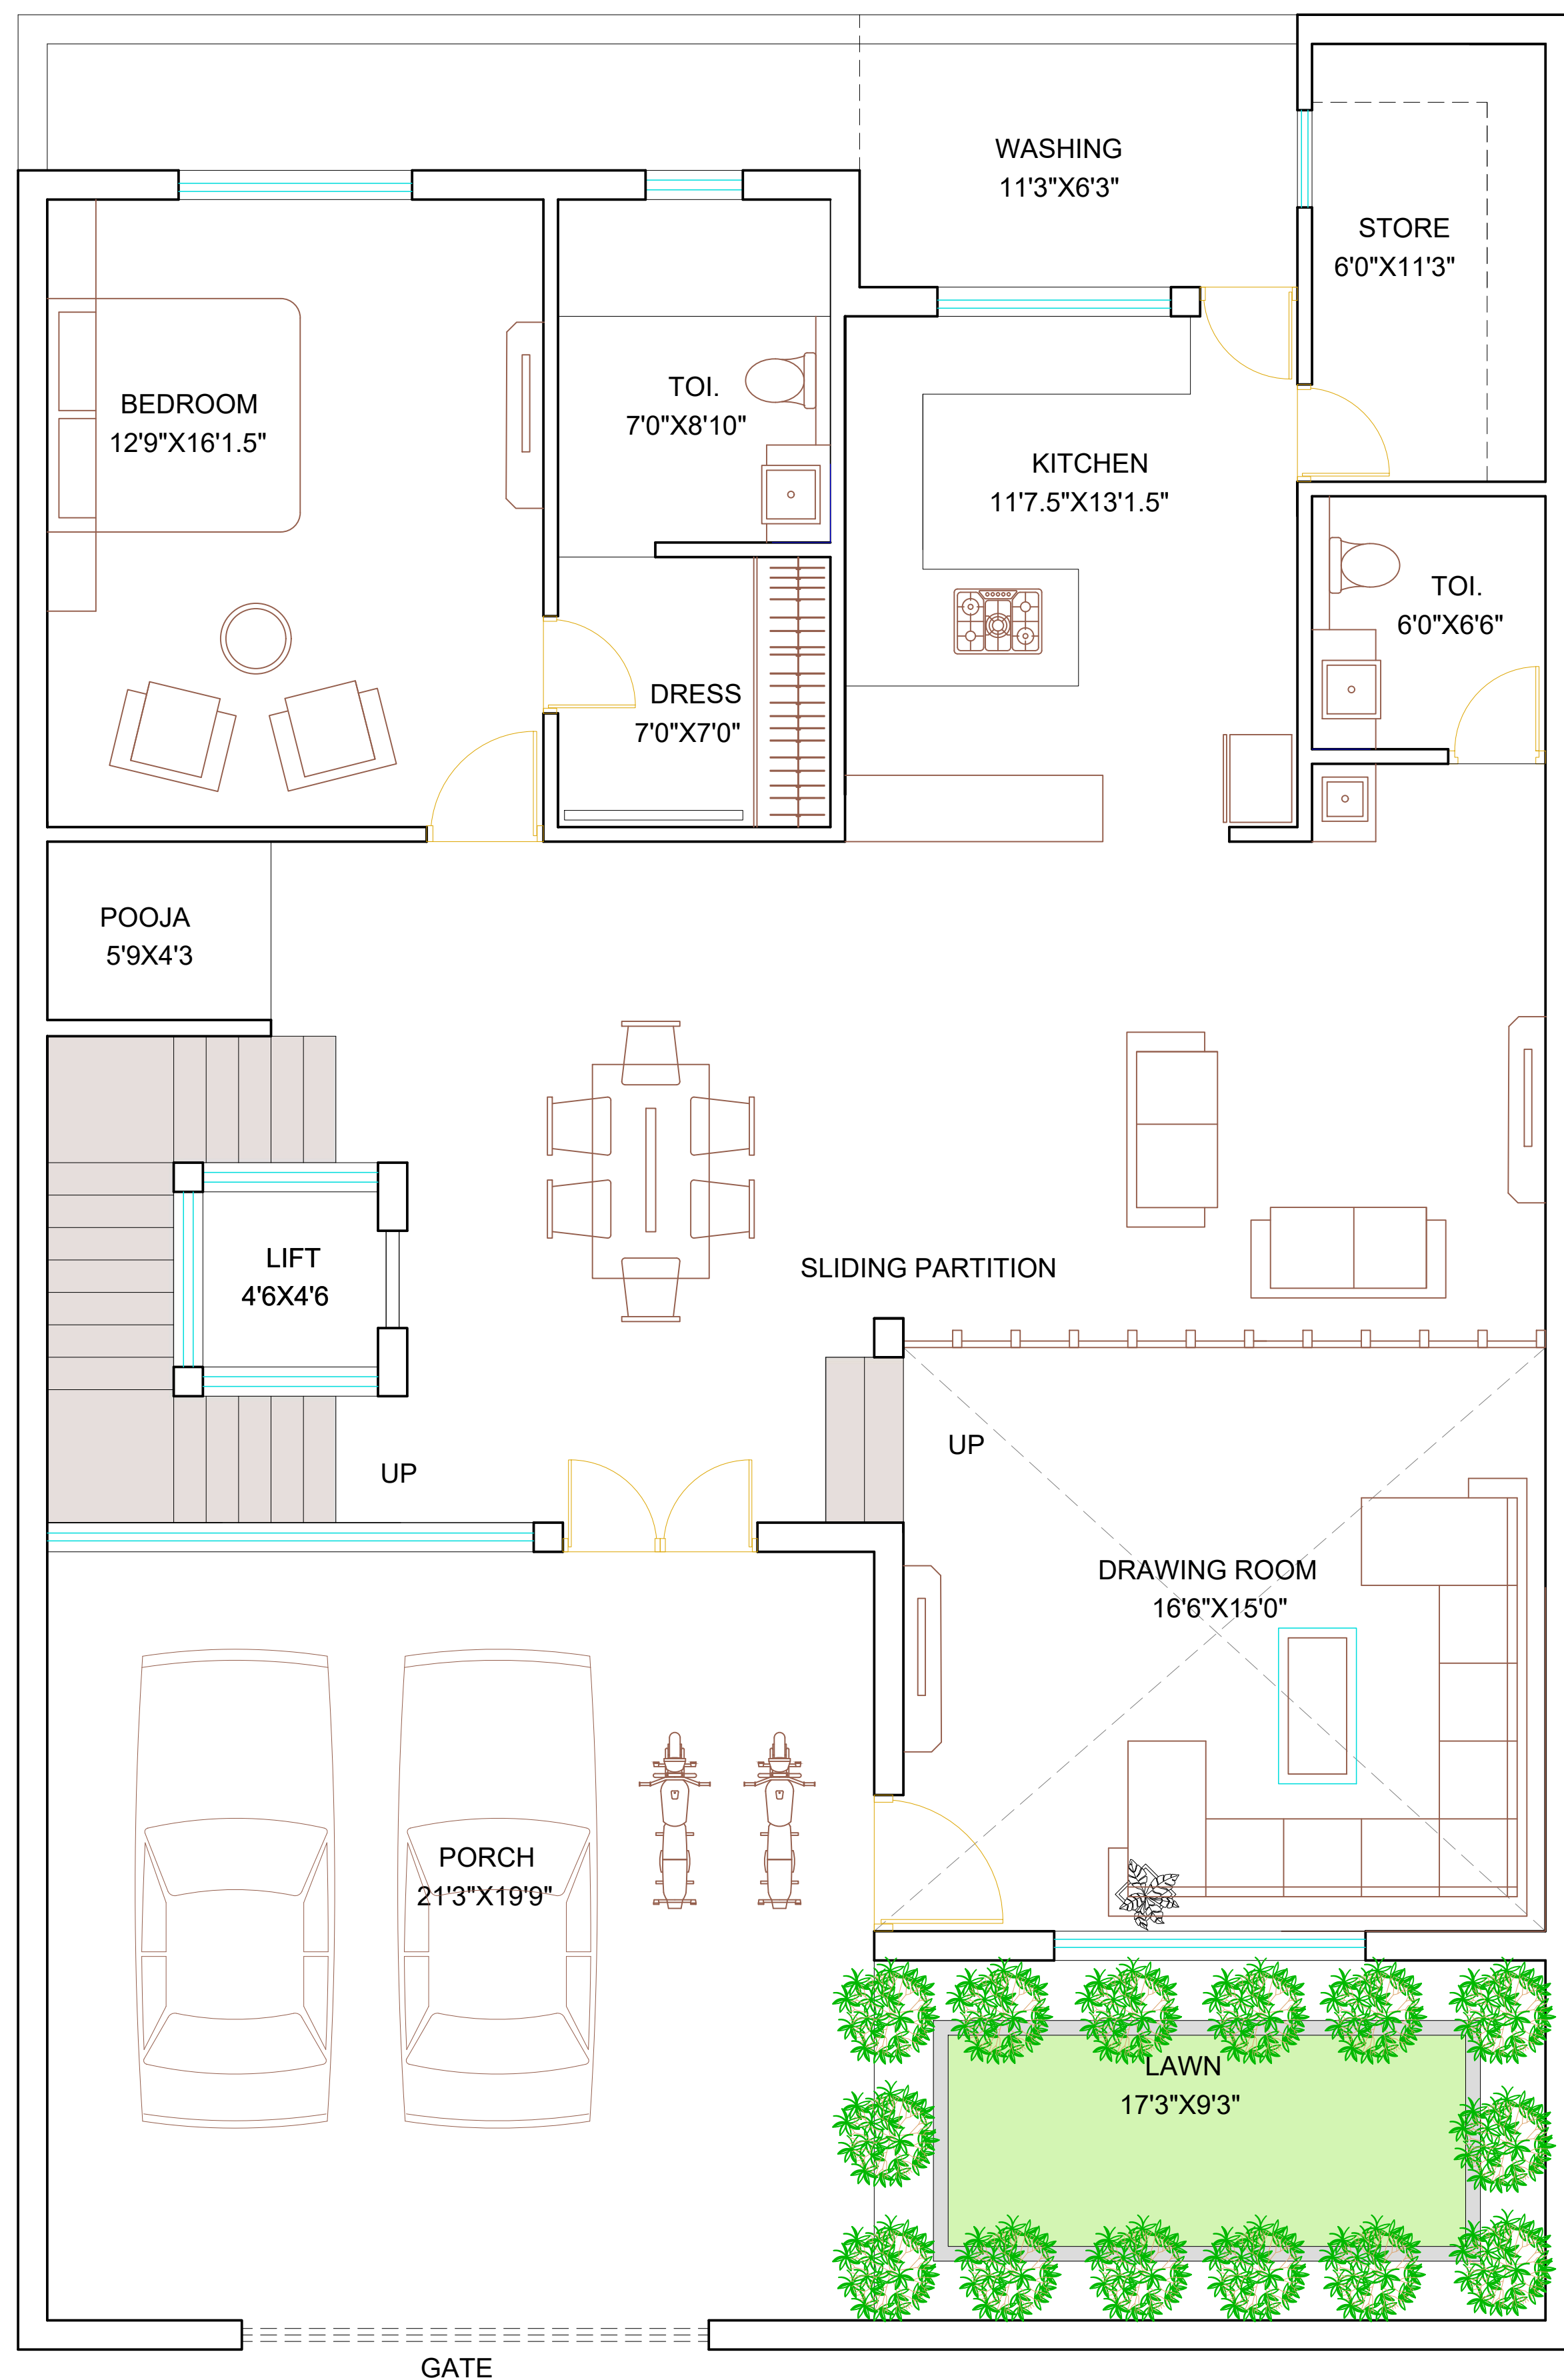

GROUND FLOOR

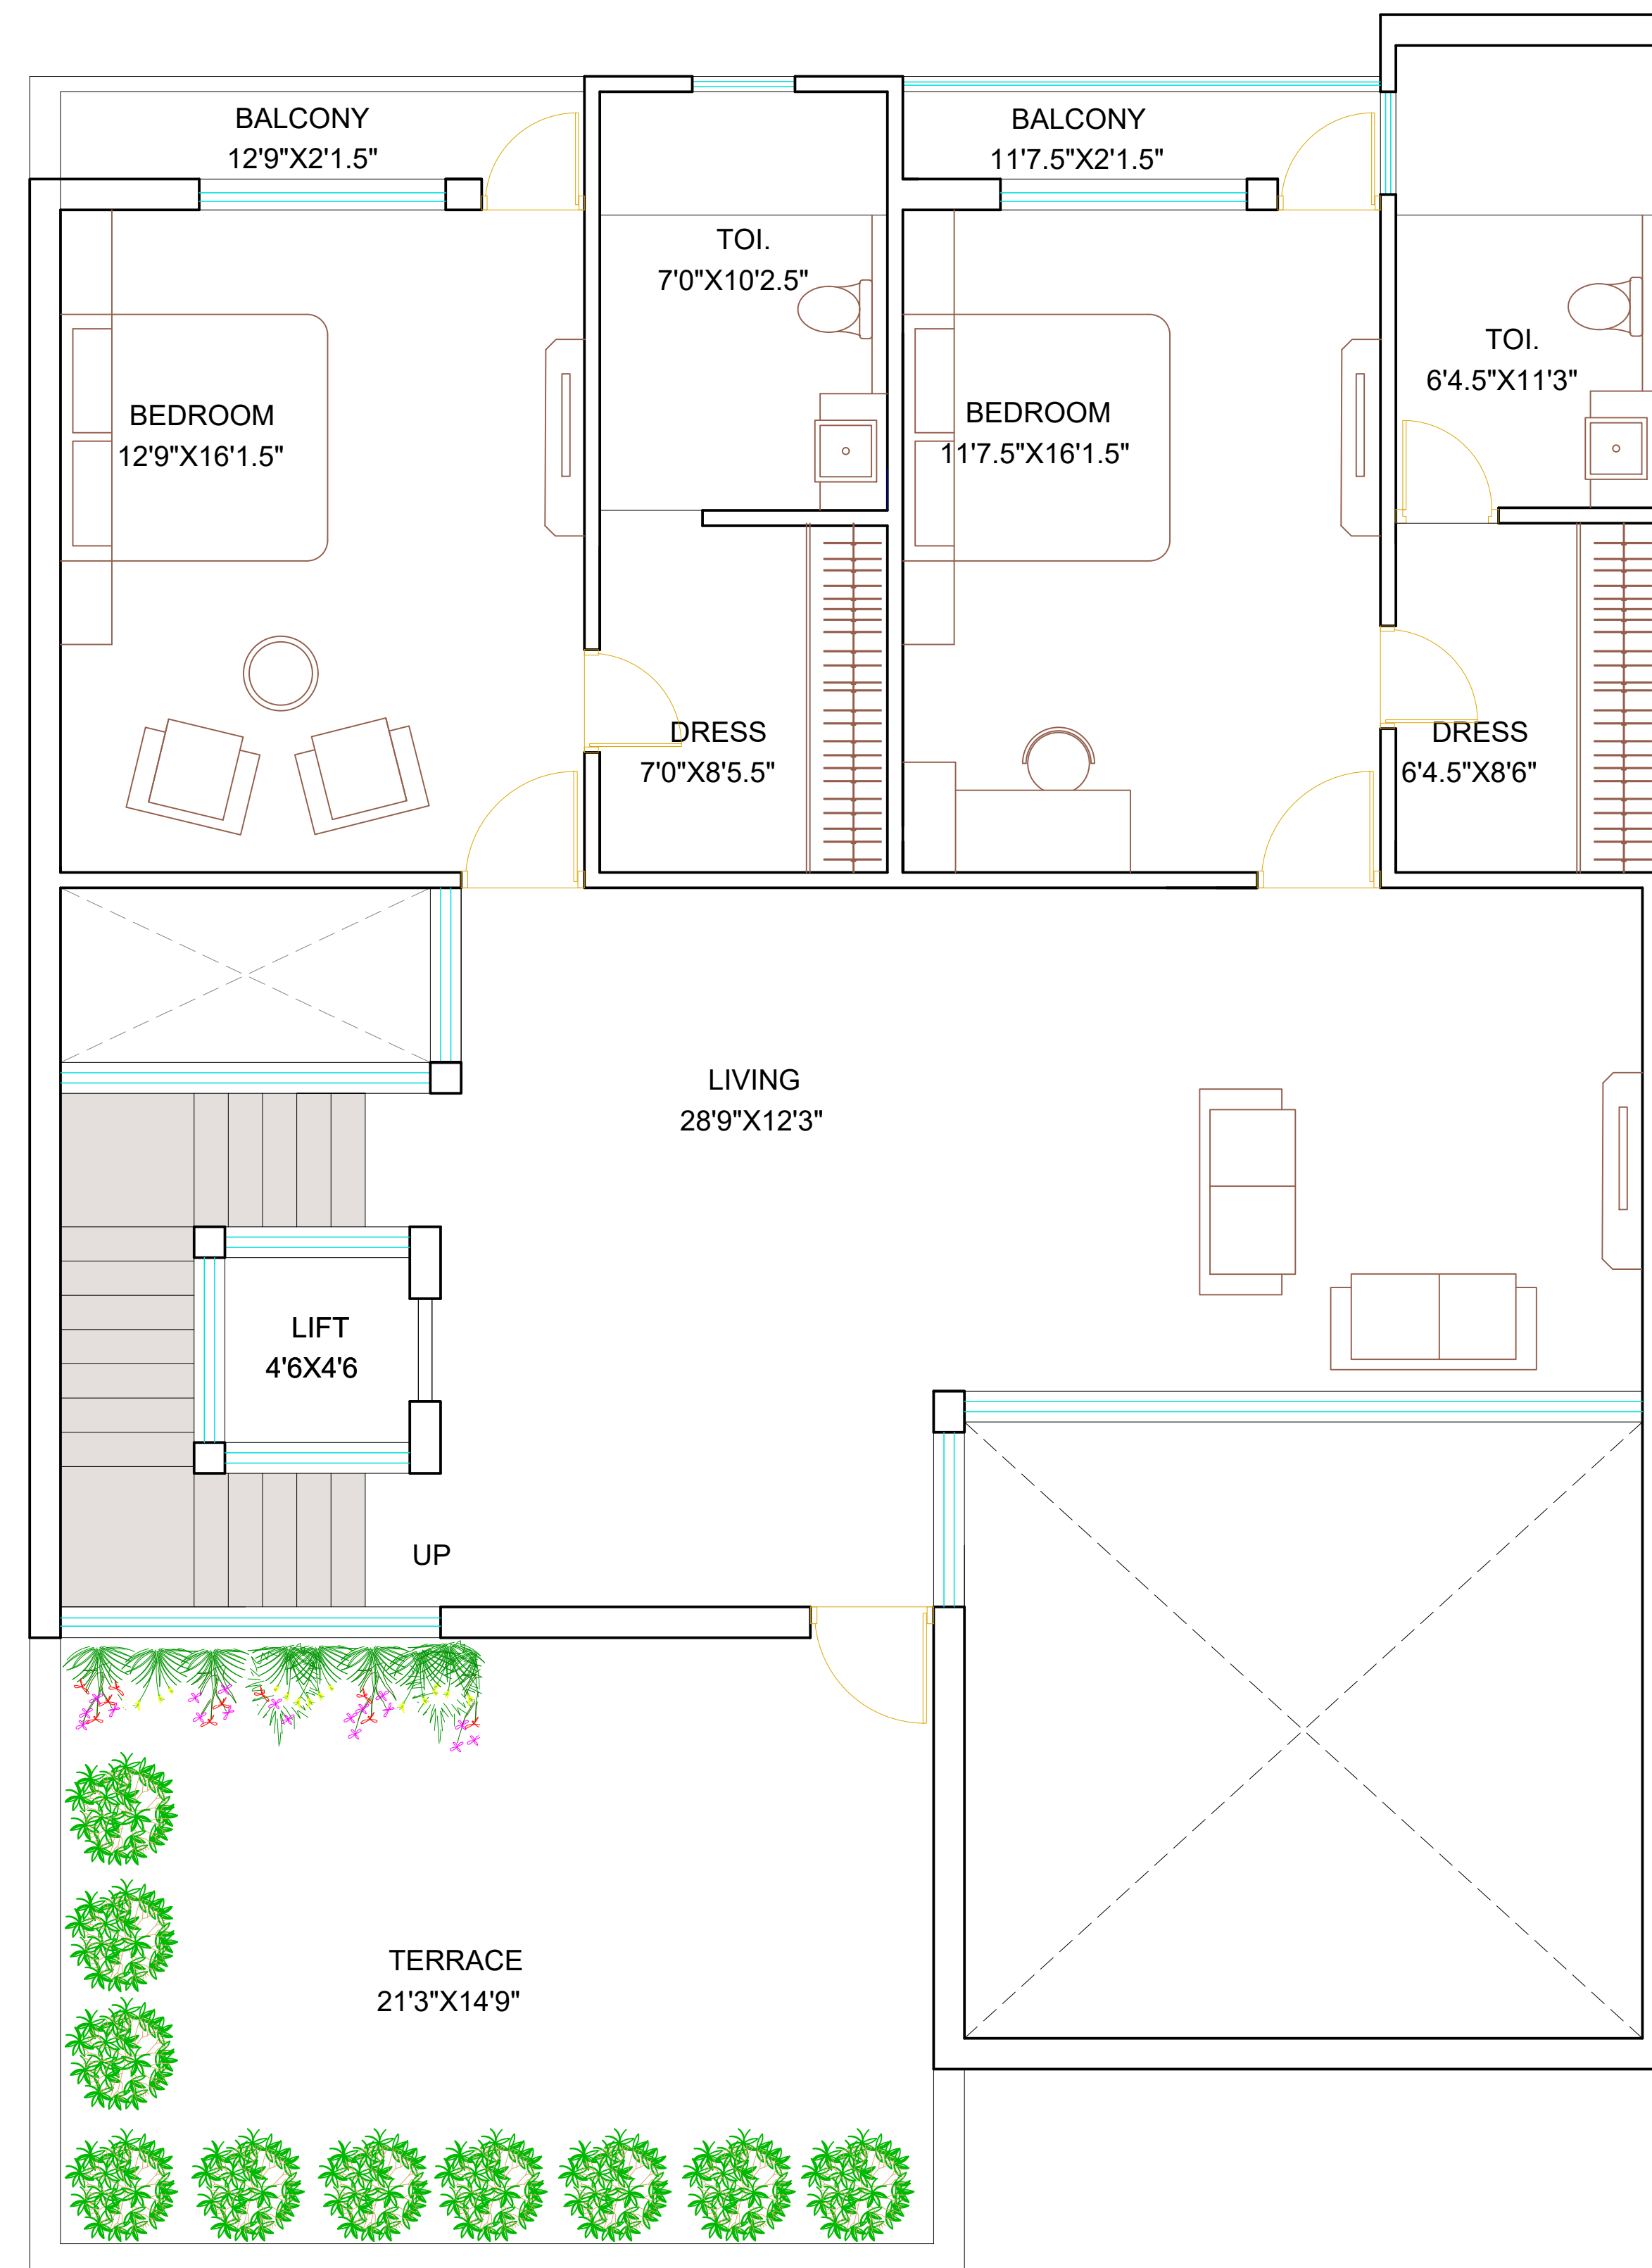


FIRST FLOOR

PROJECT NAME - MR. RAWAT
DRAWING NAME - PROPOSED PLAN

- Only written dimension should be followed.
- All dimension should be checked by contractor and any discrepancy in them shall be brought to the notice of Architect before execution.
- Structure details (beam & column) taken here are as given by structural engineer.
- All dimensions are feet & inch.


DRAWN BY - ADITYA
CHECKED BY - VINITA
DATE - 03 - 08 -2022

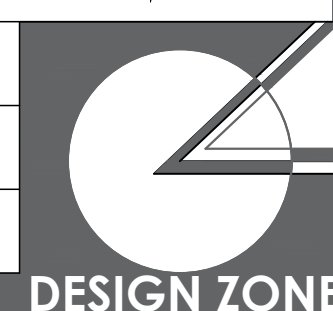


PROJECT NAME - MR. RAWAT
DRAWING NAME - PROPOSED PLAN

- Only written dimension should be followed.
- All dimension should be checked by contractor and any discrepancy in them shall be brought to the notice of Architect before execution.
- Structure details (beam & column) taken here are as given by structural engineer.
- All dimensions are feet & inch.

DRAWN BY - ADITYA
CHECKED BY - VINITA
DATE - 03 - 08 -2022

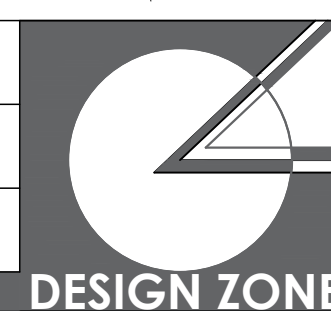

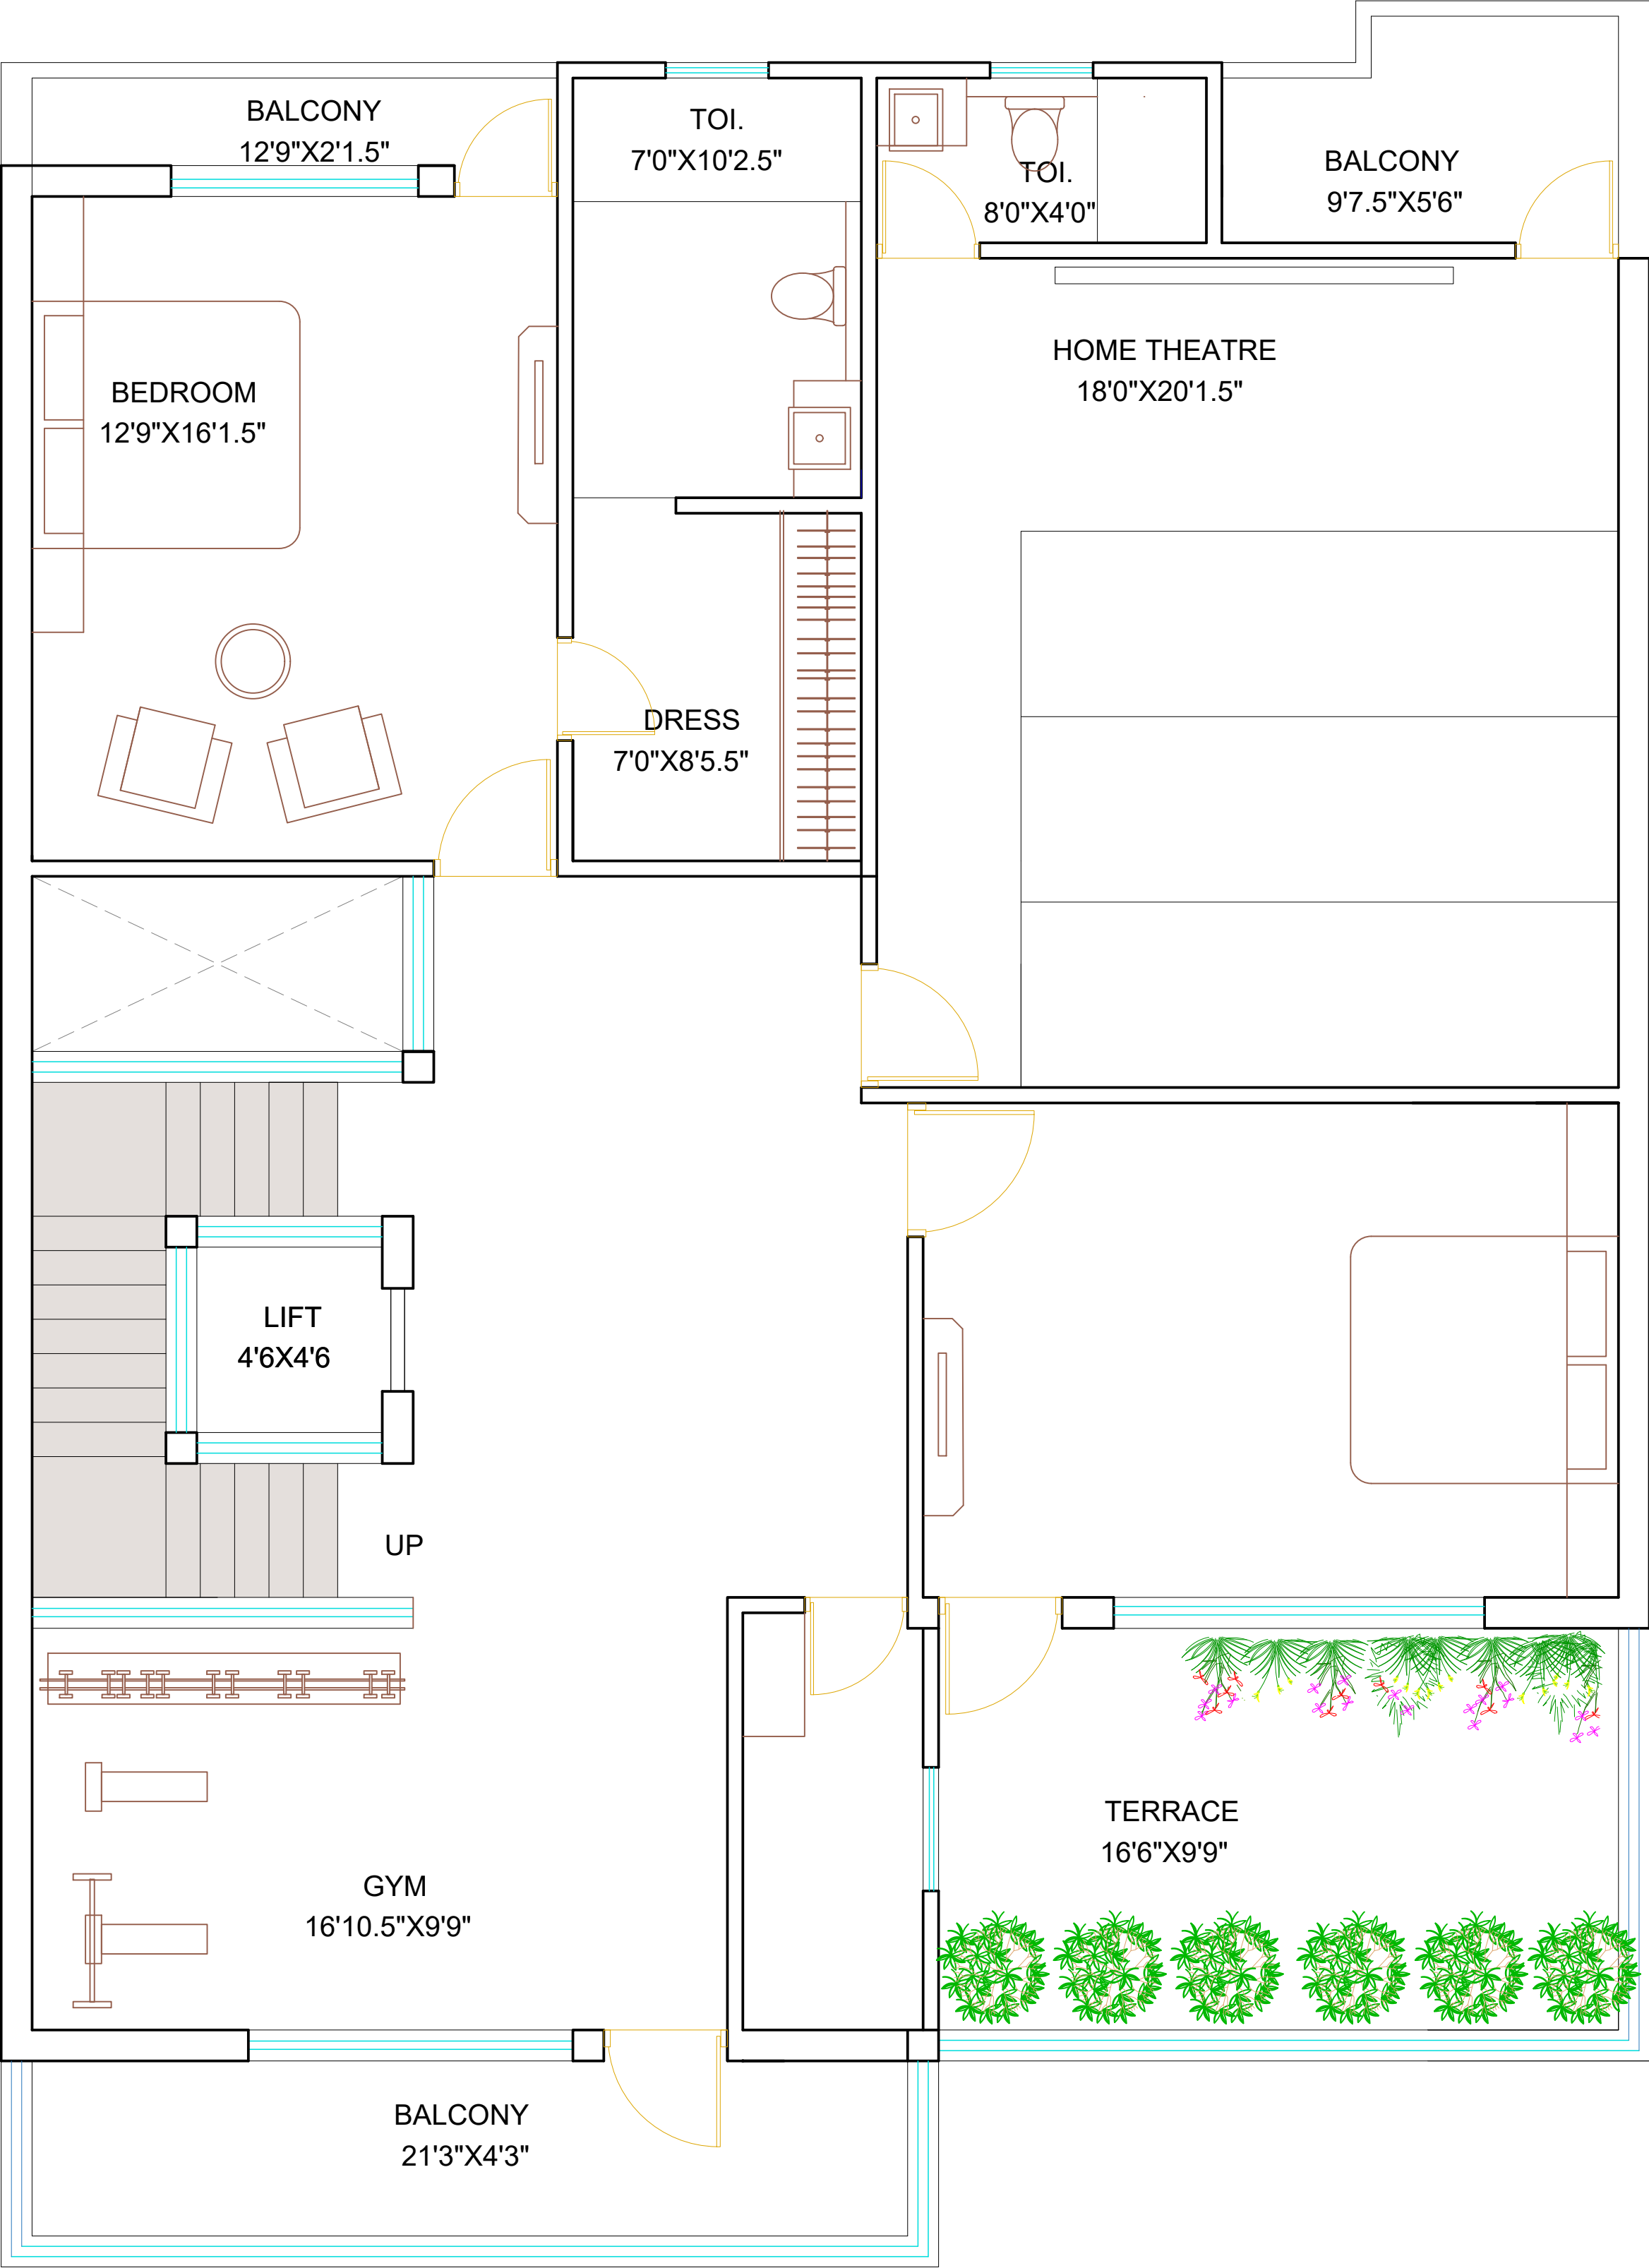

SECOND FLOOR

PROJECT NAME - MR. RAWAT

DRAWING NAME - PROPOSED PLAN






- Only written dimension should be followed.
- All dimension should be checked by contractor and any discrepancy in them shall be brought to the notice of Architect before execution.
- Structure details (beam & column) taken here are as given by structural engineer.
- All dimensions are feet & inch.

DRAWN BY - ADITYA

CHECKED BY - VINITA

DATE - 03 - 08 -2022



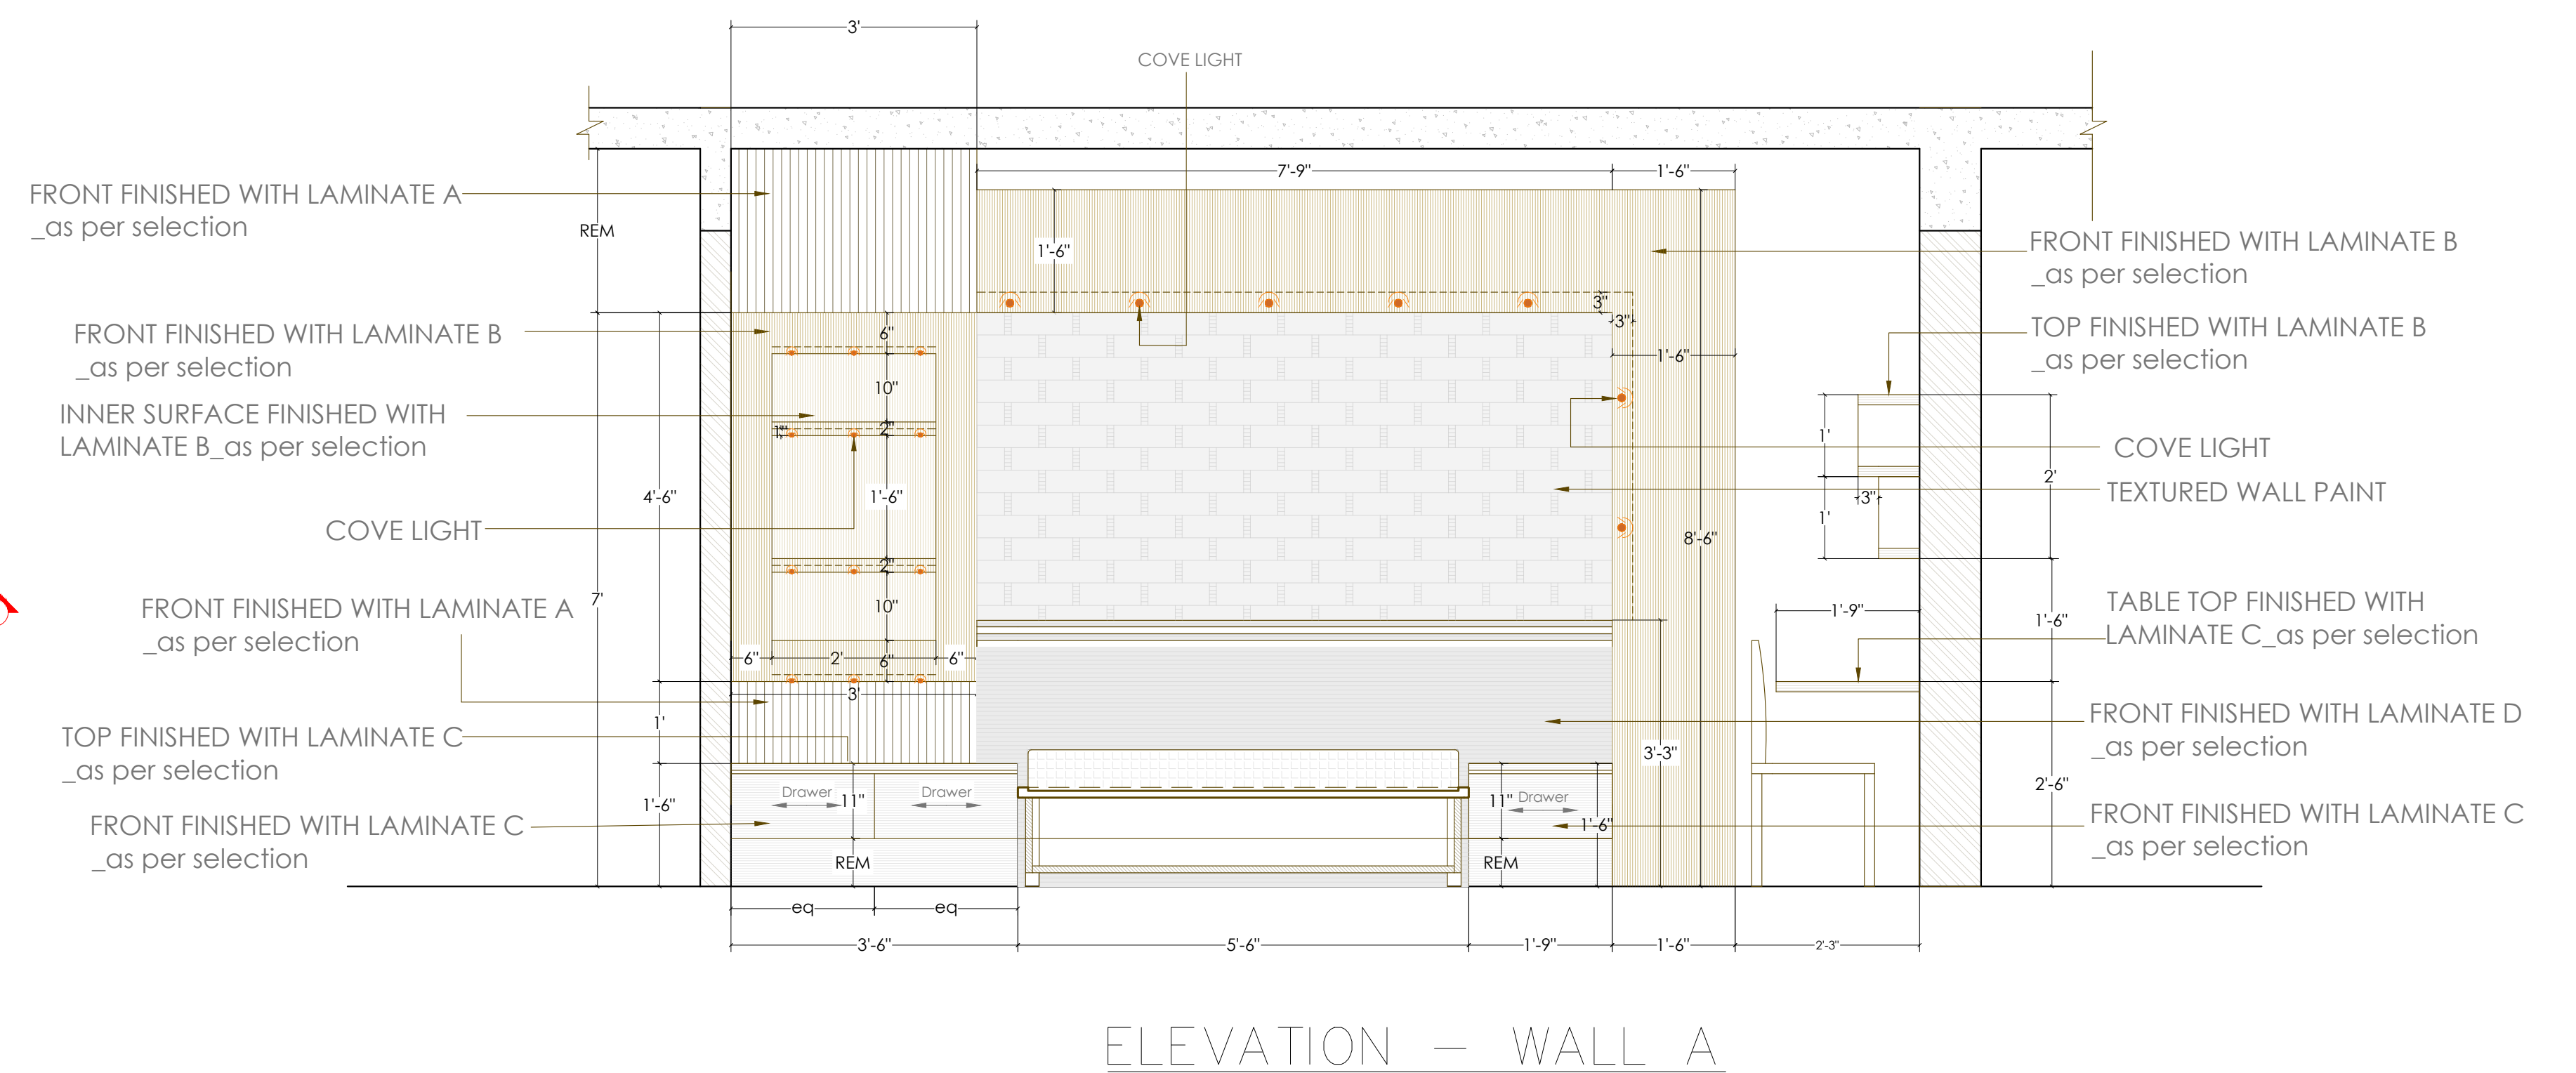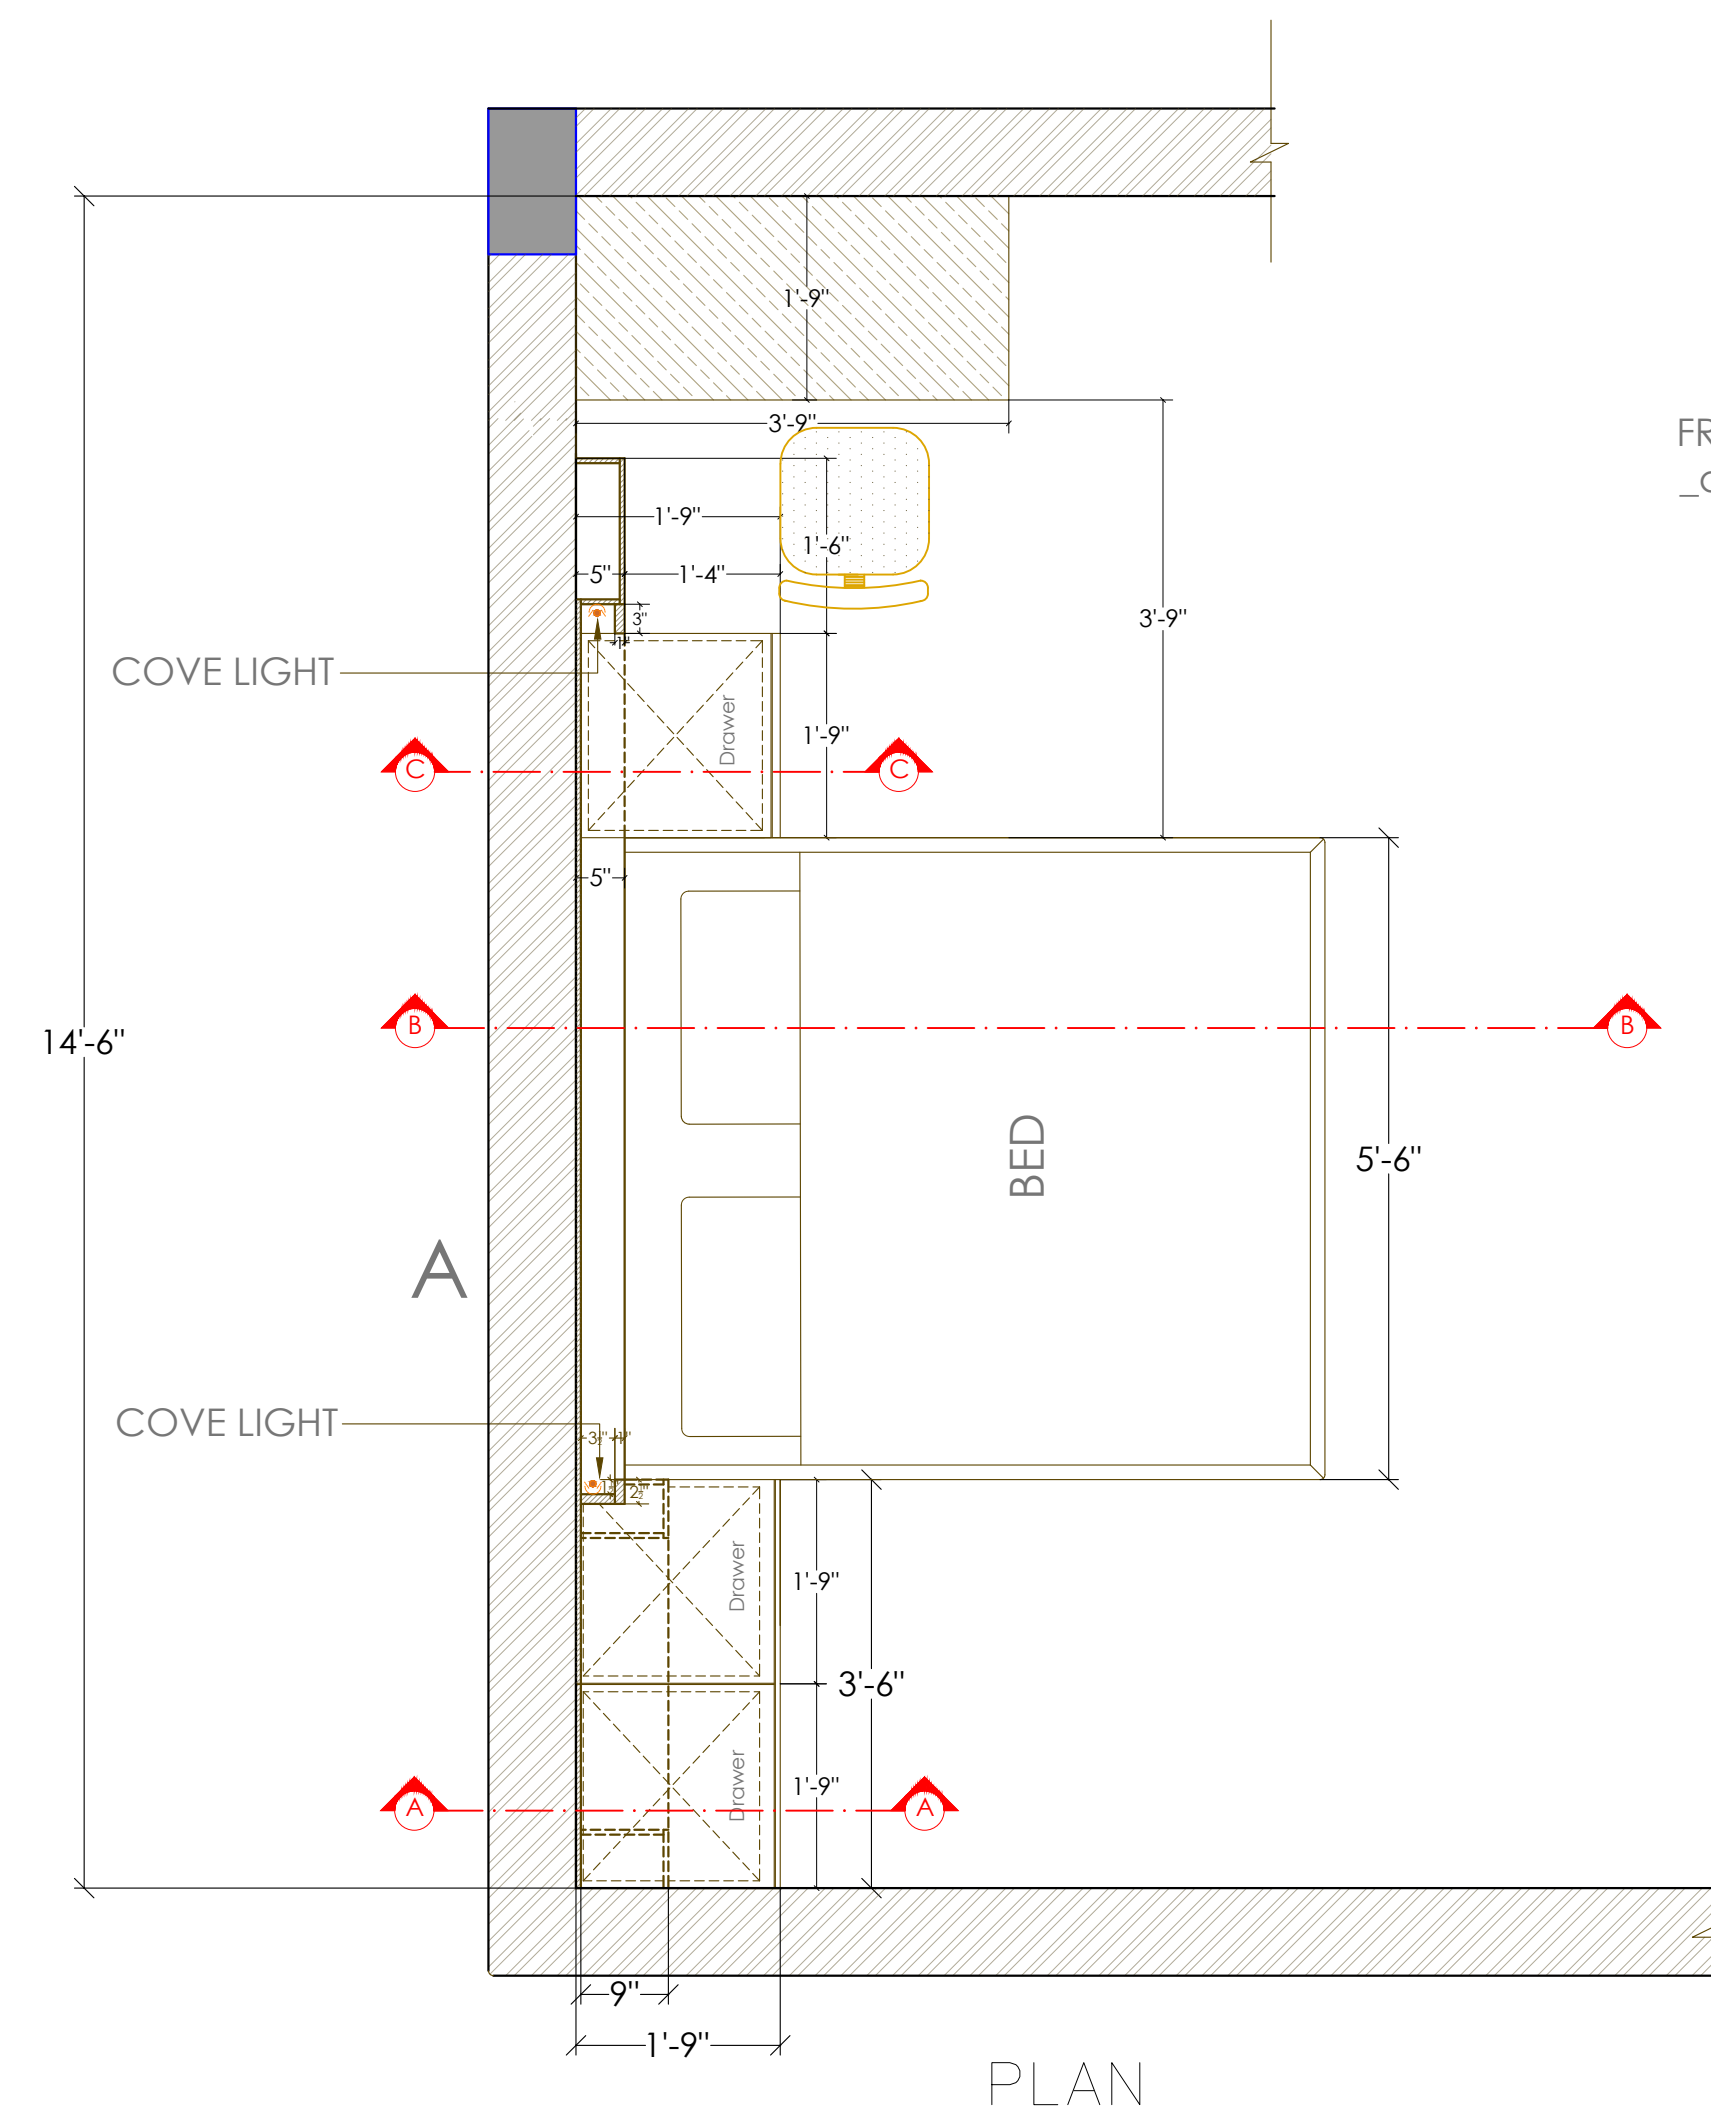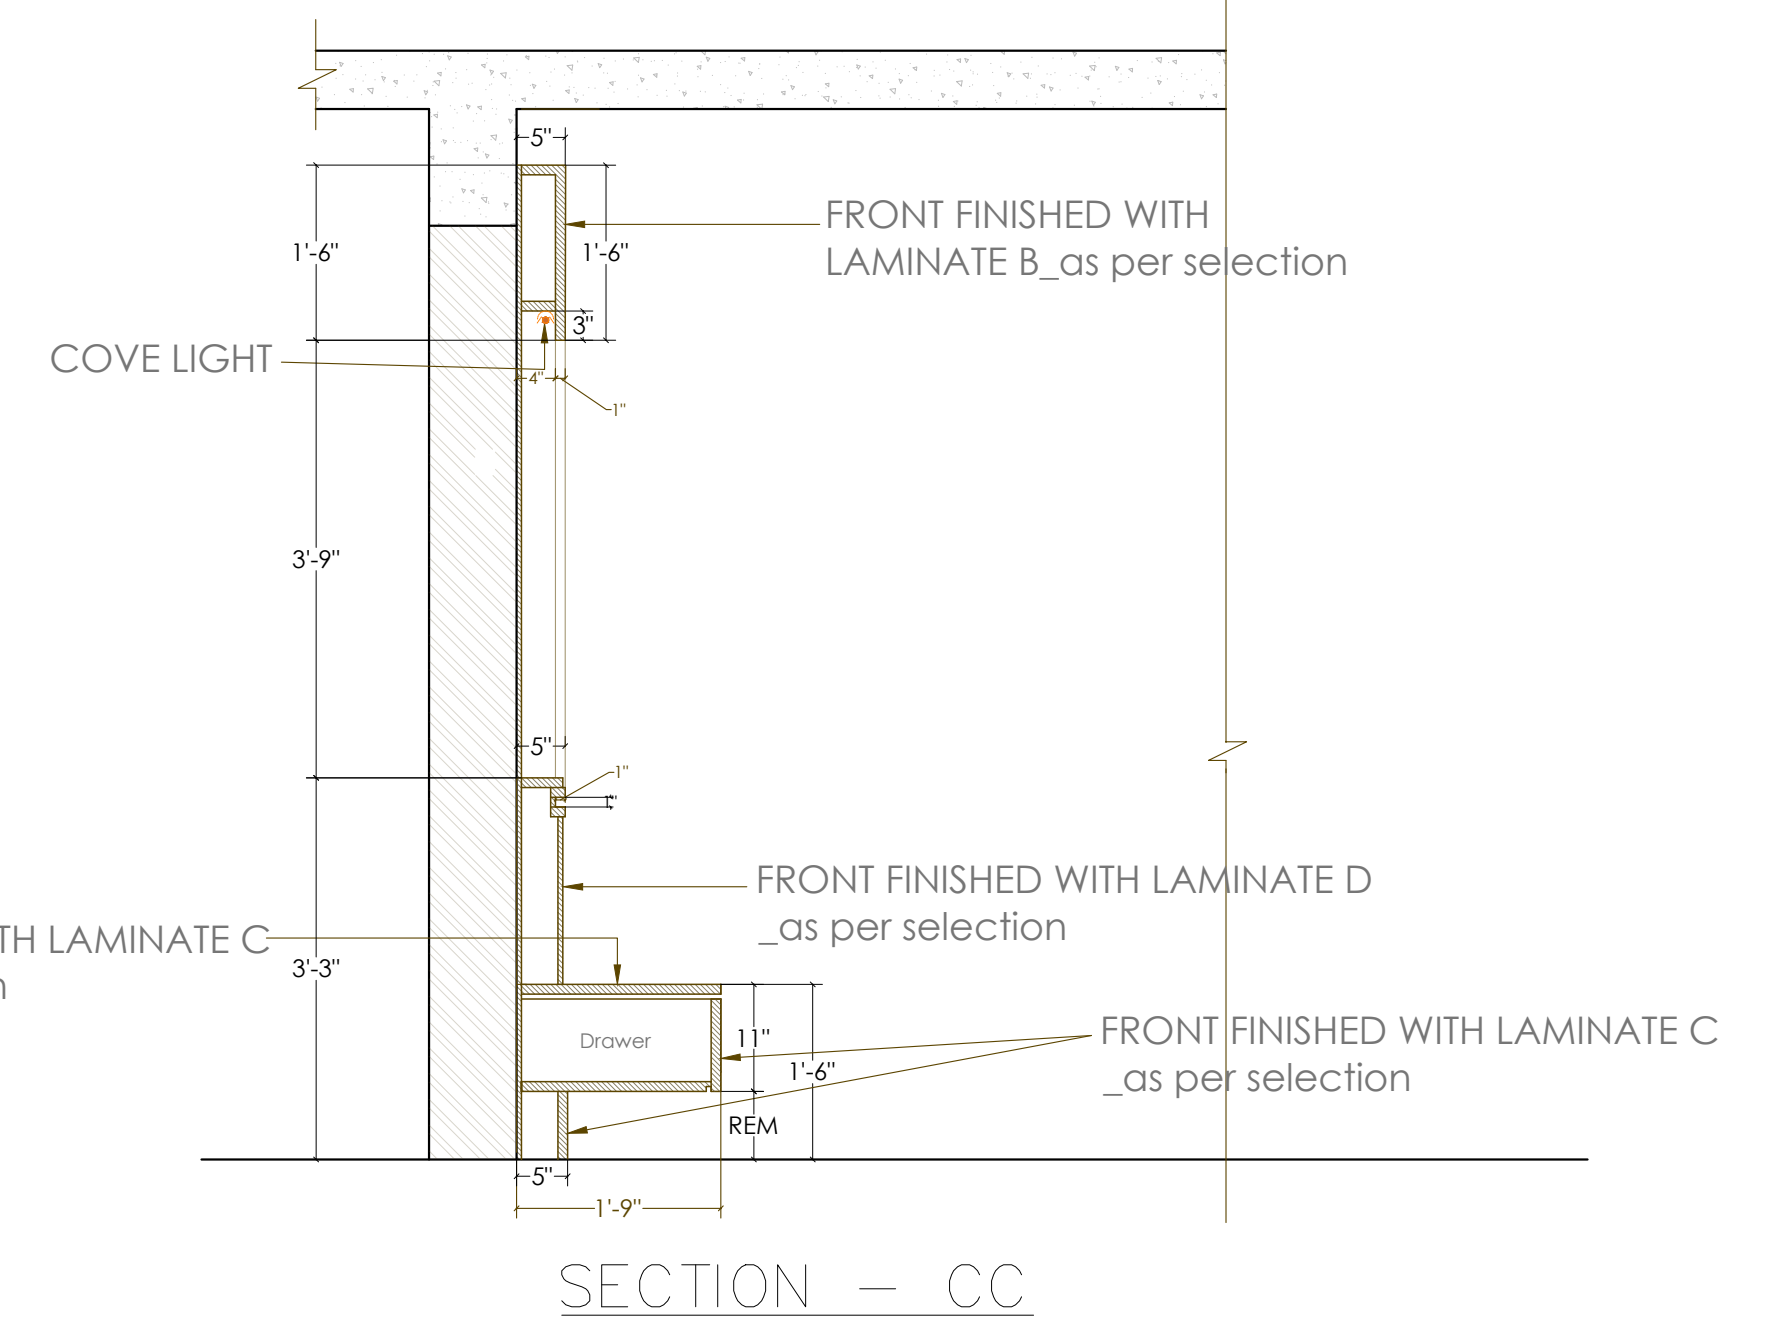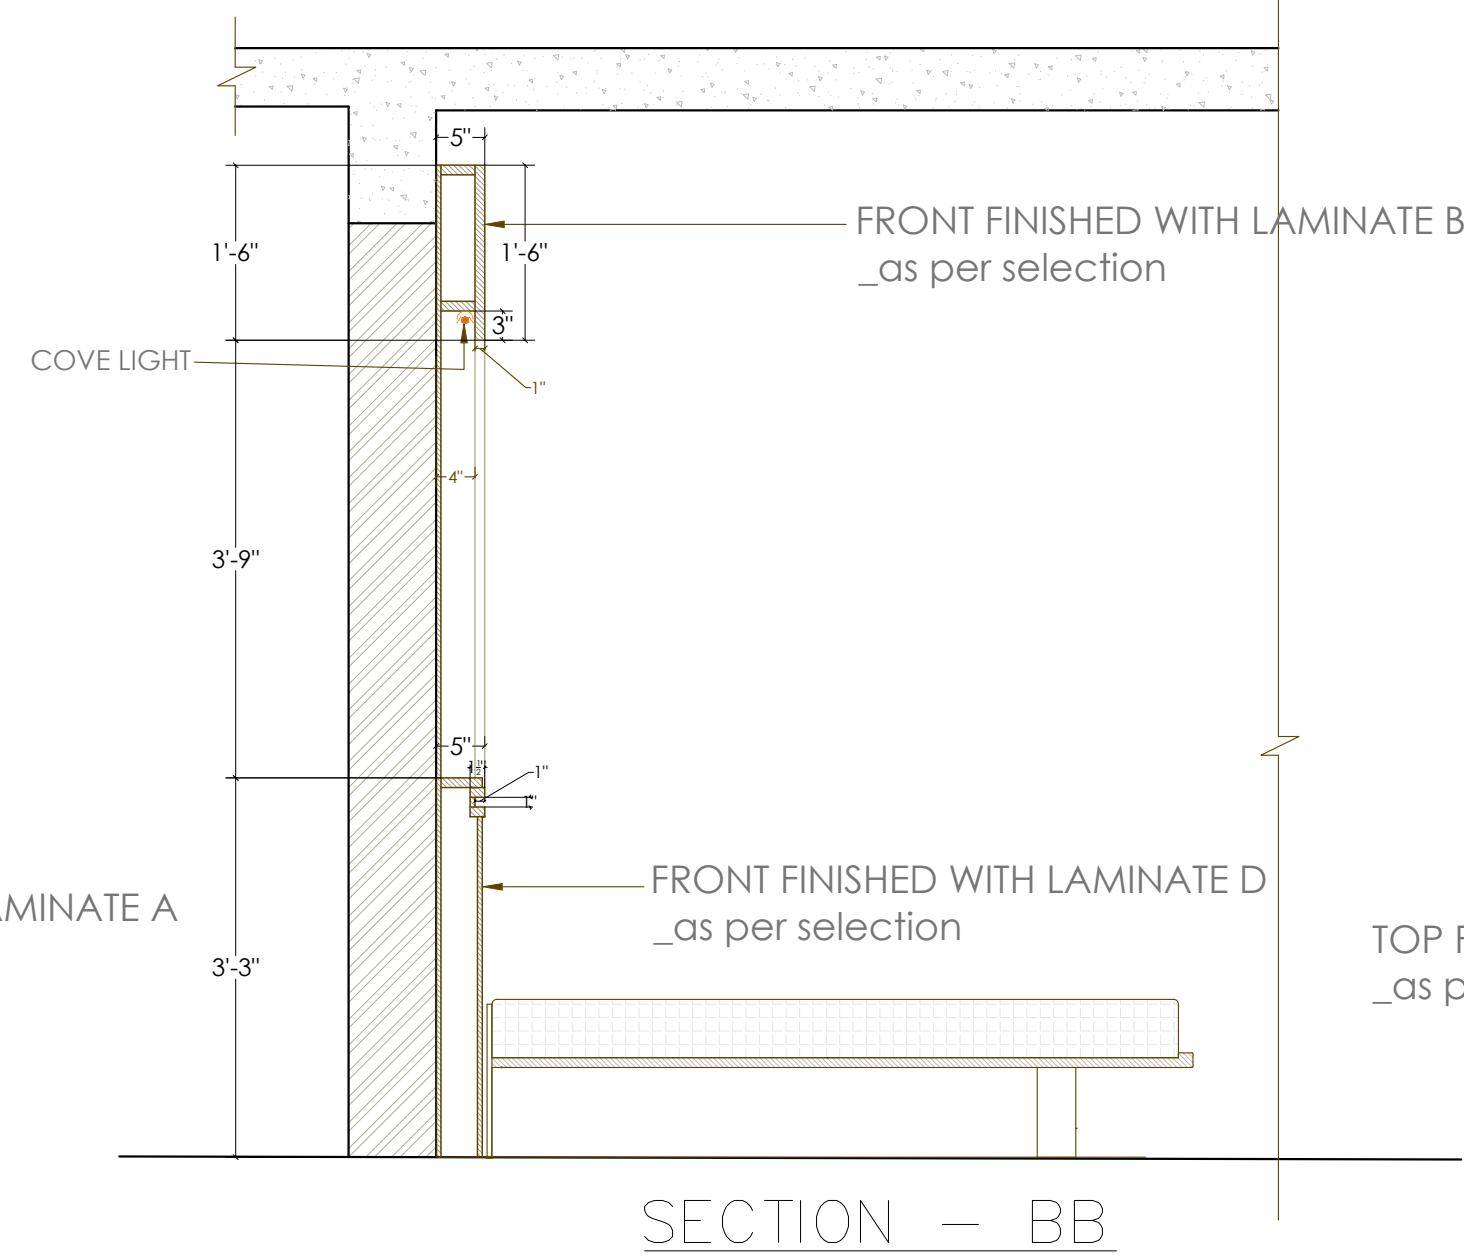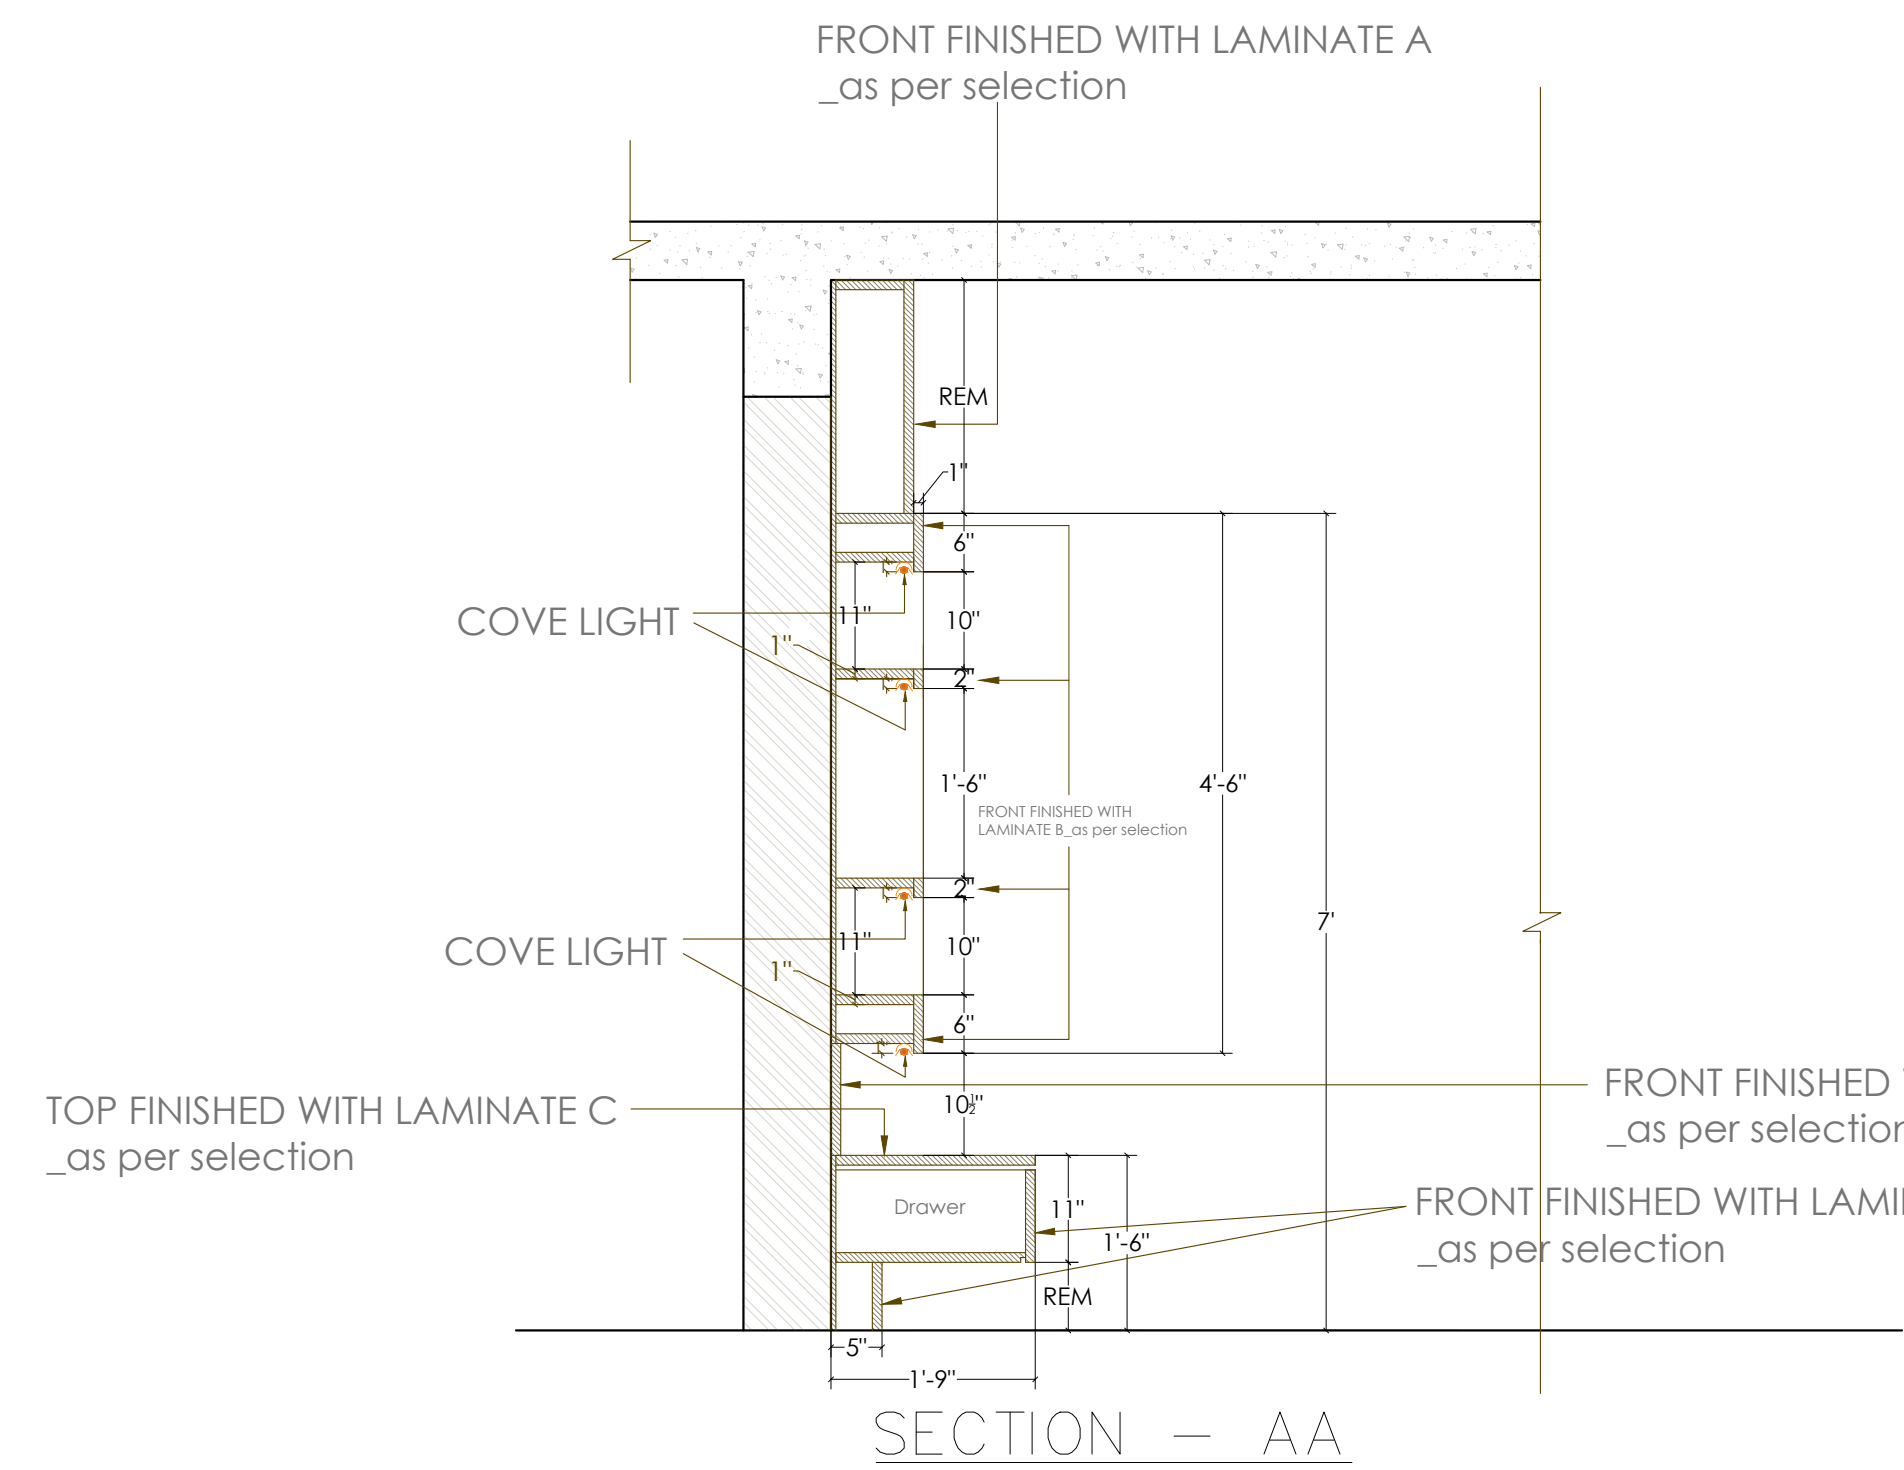

PROJECT NAME -MR. PRASHIV SHARMA

DRAWING NAME - WORKING DRAWINGS - BEDROOM


- Only written dimension should be followed.
- All dimension should be checked by contractor and any discrepancy in them shall be brought to the notice of Architect before execution.
- Structure details (beam & column) taken here are as given by structural engineer.
- All dimensions are feet & inch.

DRAWN BY - ADITYA


CHECKED BY -

DATE - 14 - 08 - 2022




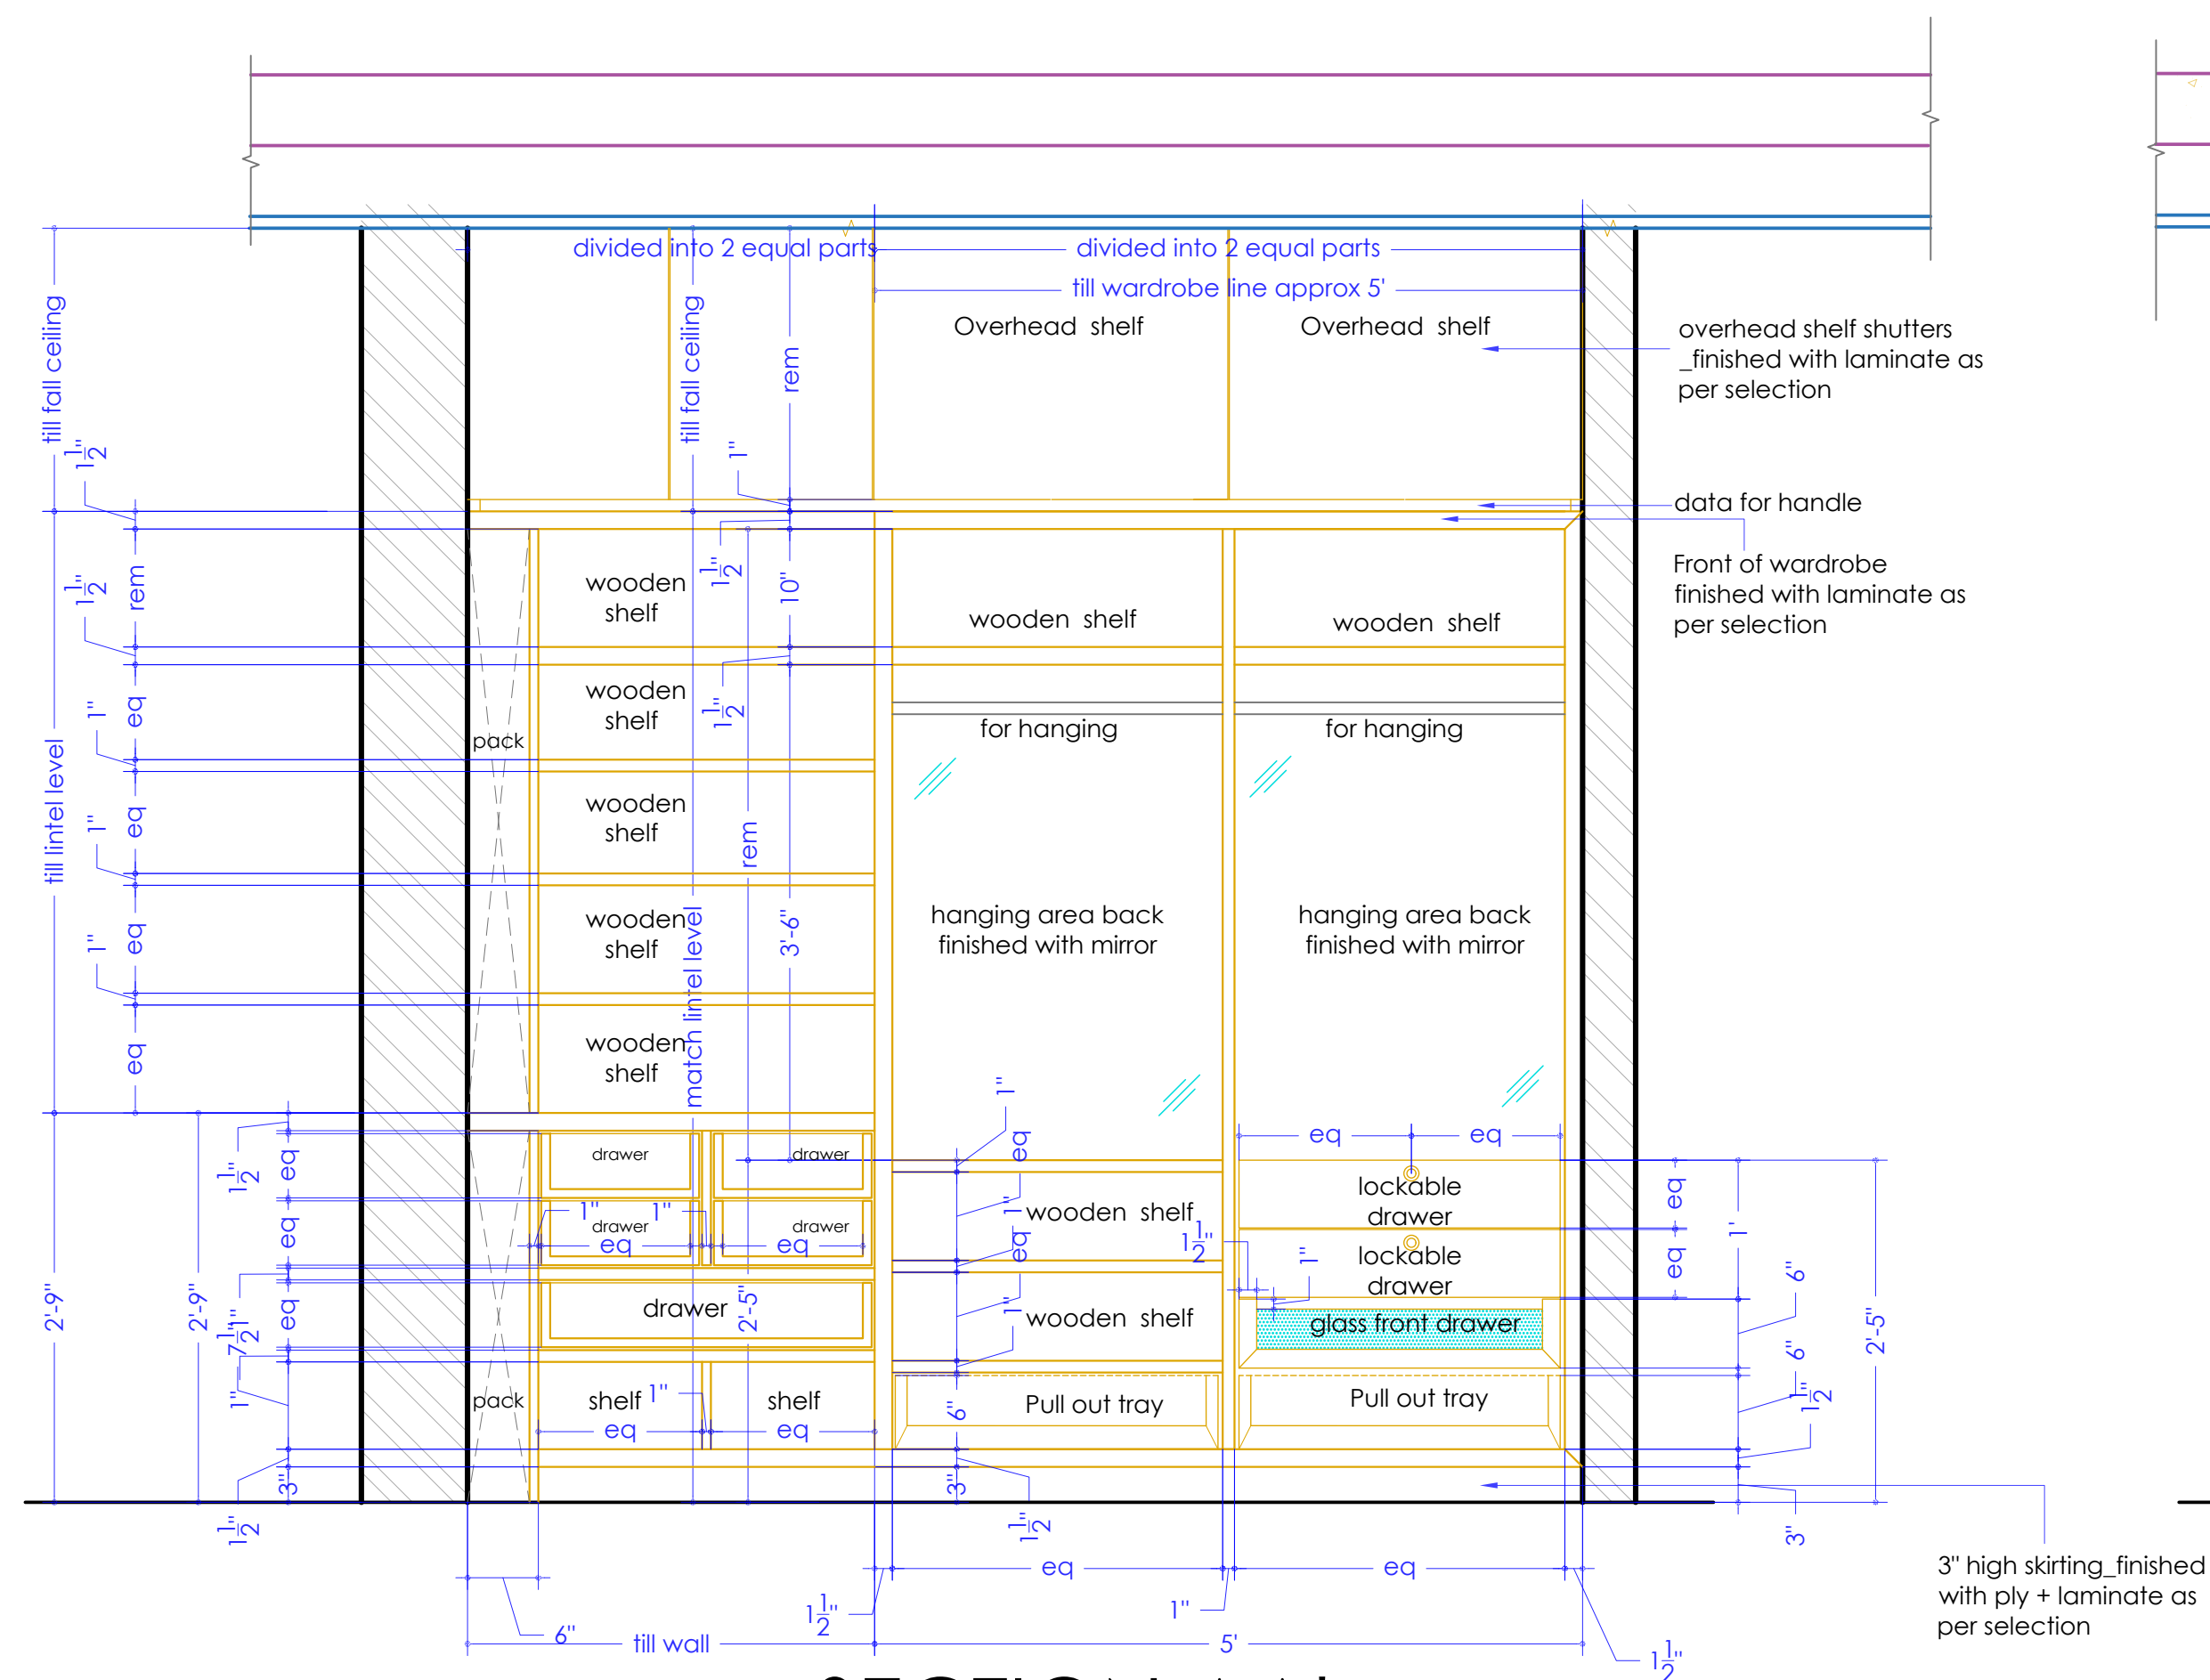


SECTION AA'

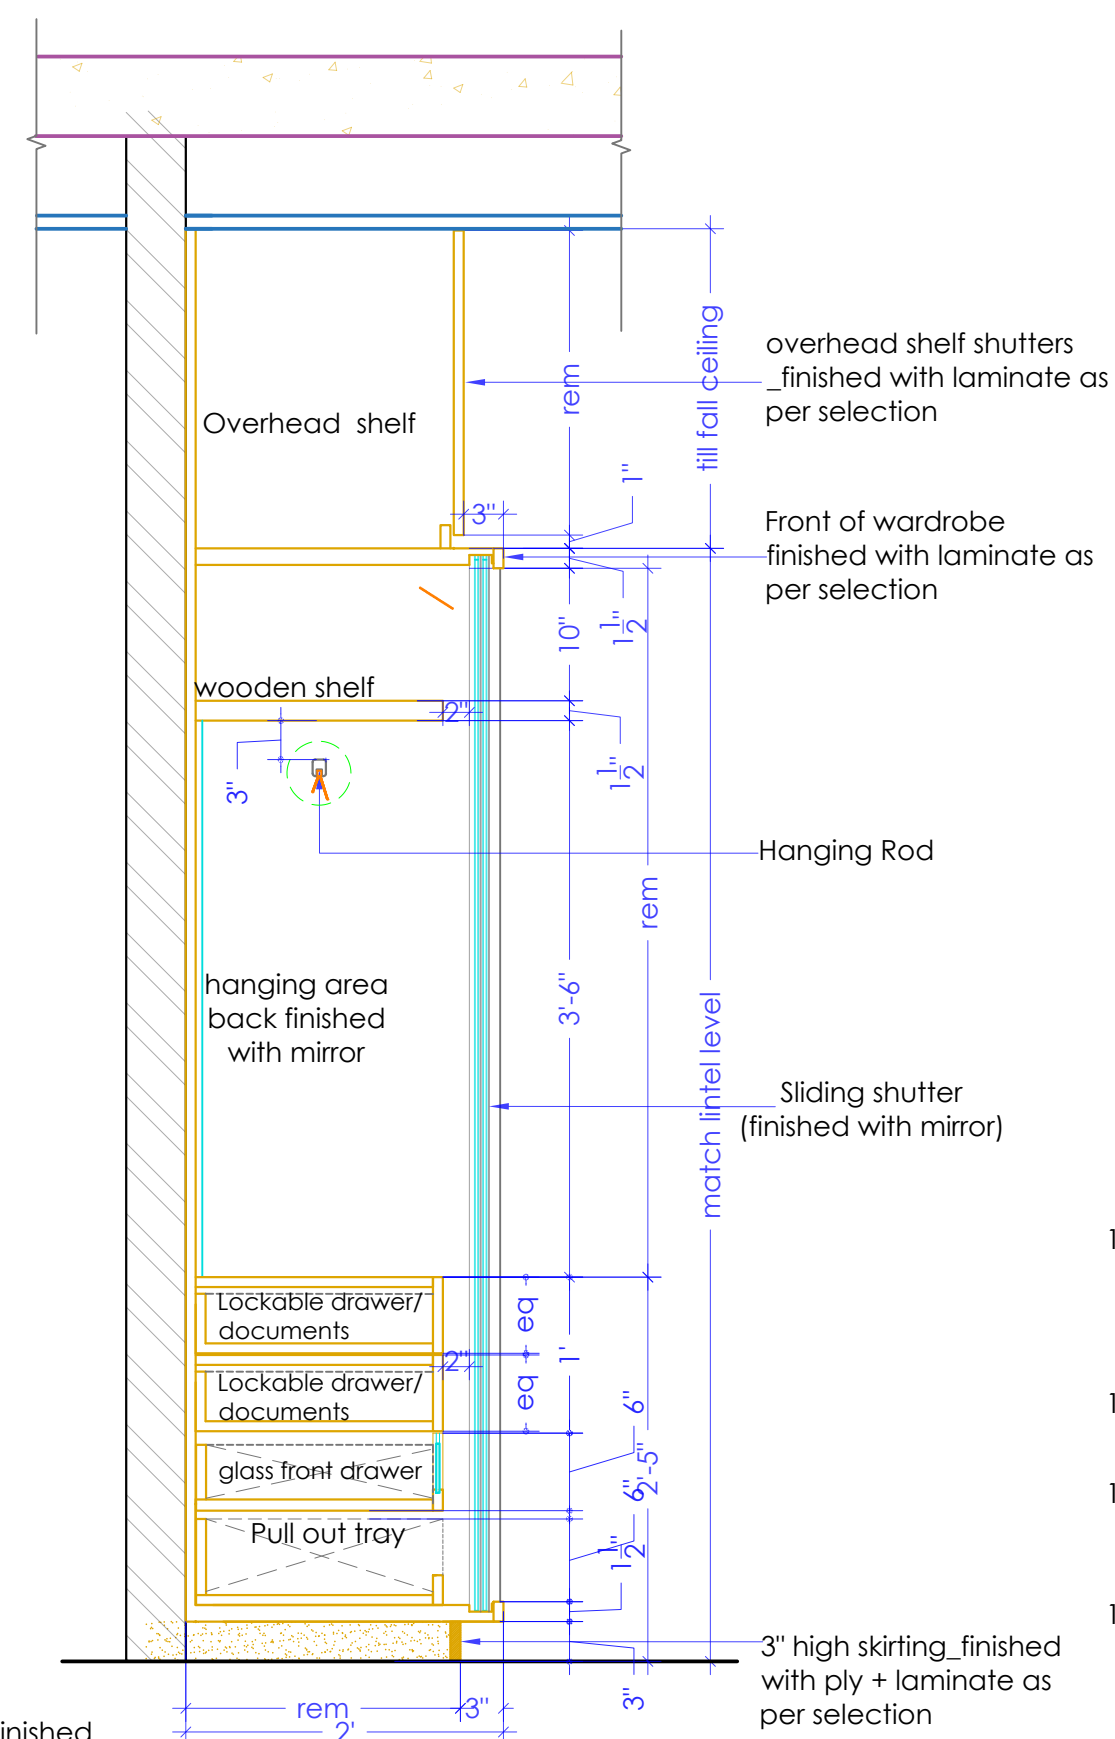

SECTION BB'

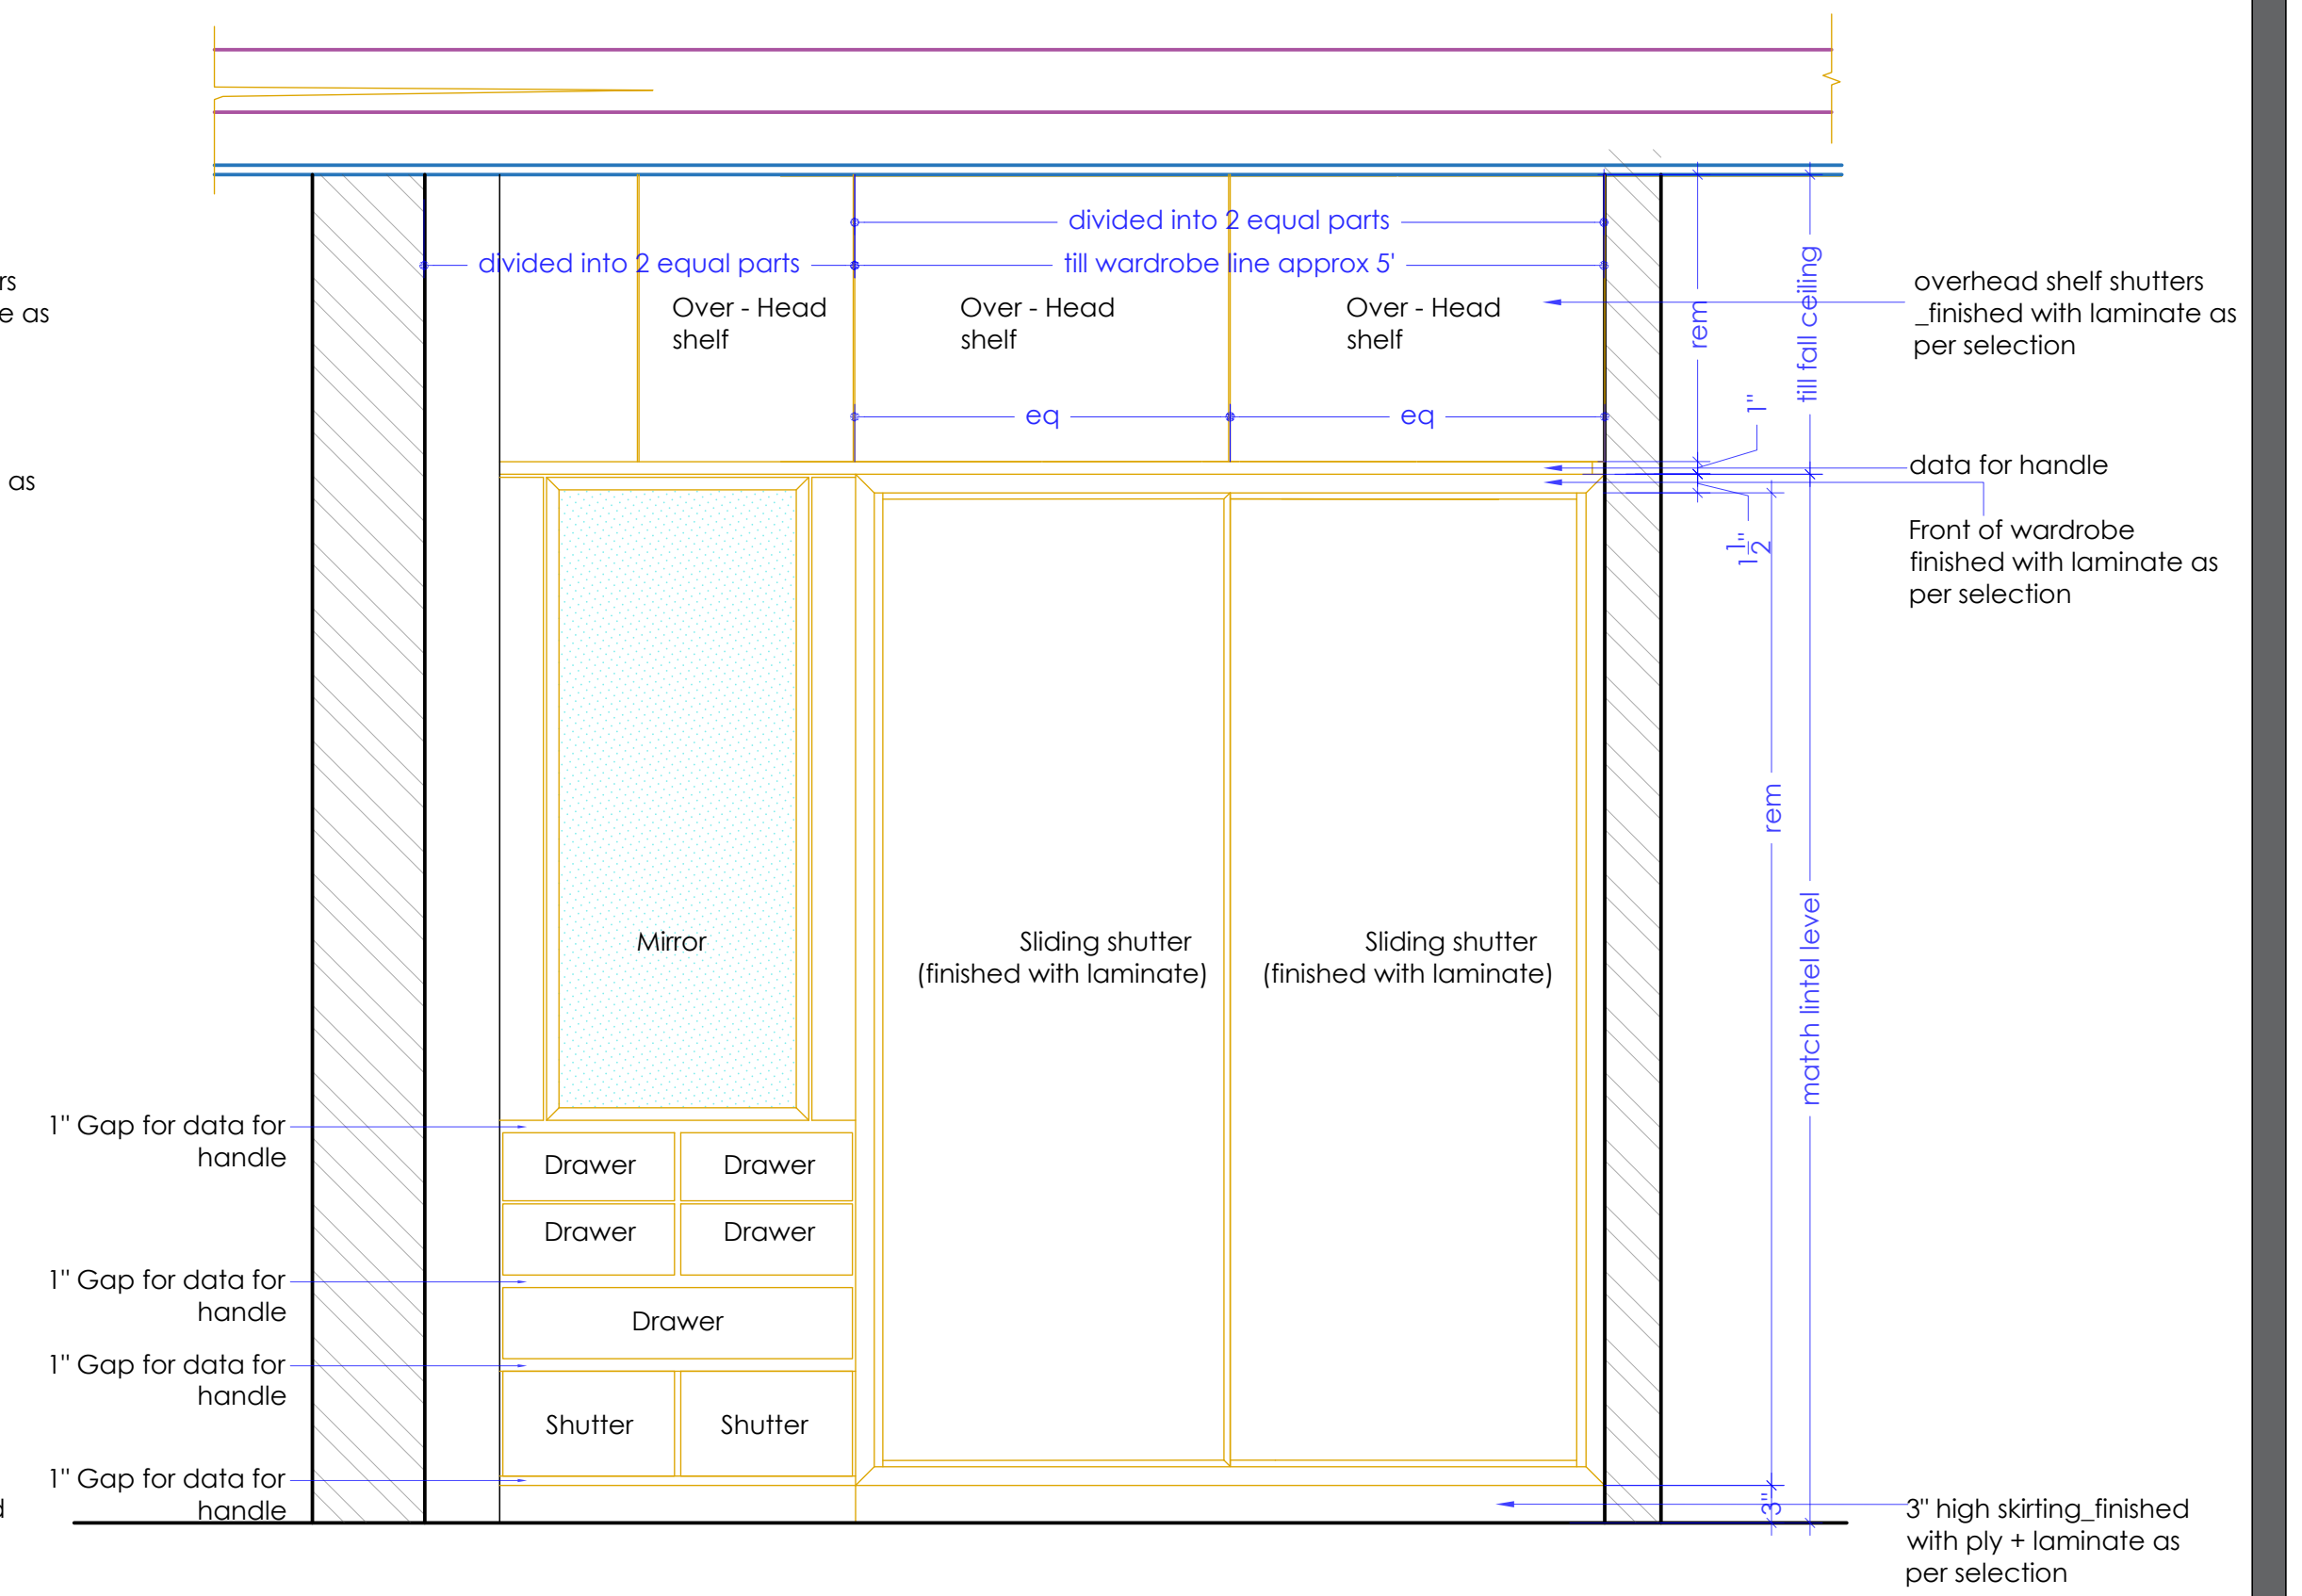

ELEVATION

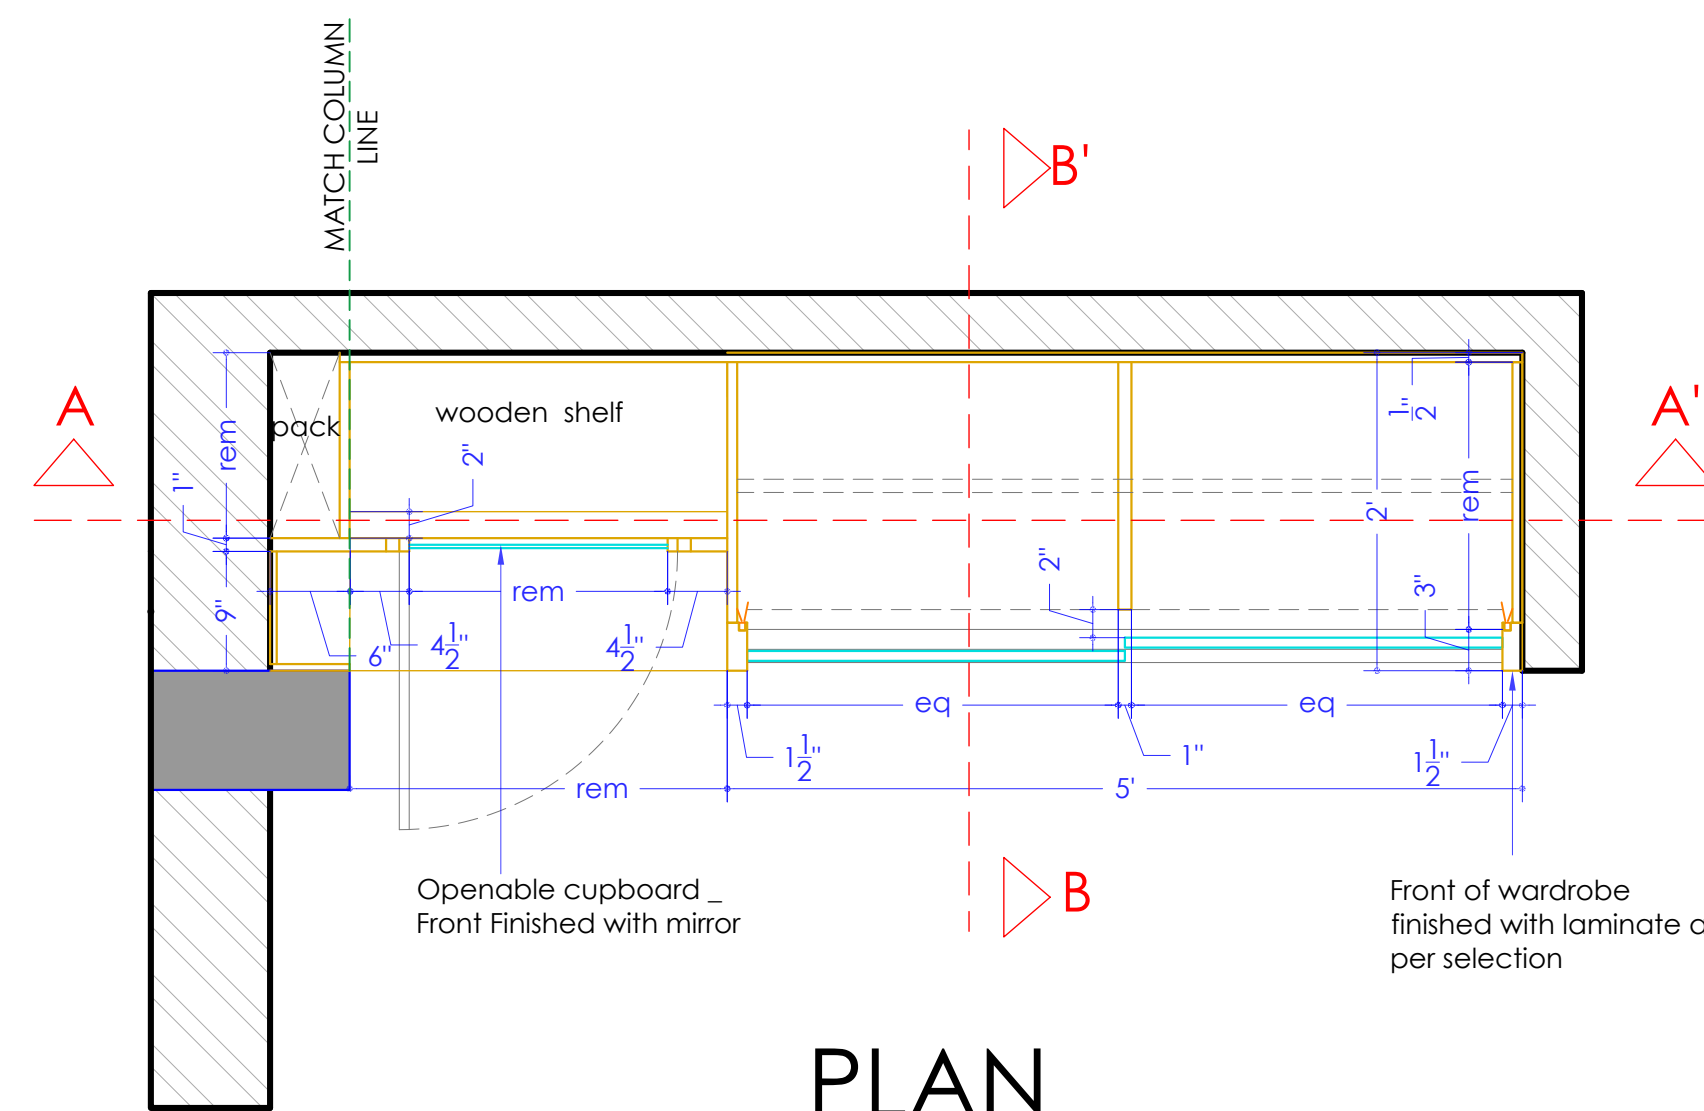

PLAN

PROJECT NAME - MR. PRASHIV SHARMA

DRAWING NAME - WARDROBE DETAILS
GUEST BEDROOM


- Only written dimension should be followed.
- All dimension should be checked by contractor and any discrepancy in them shall be brought to the notice of Architect before execution.
- Structure details (beam & column) taken here are as given by structural engineer.
- All dimensions are feet & inch.

DRAWN BY - ADITYA


CHECKED BY -

DATE - 03 - 09 - 2022




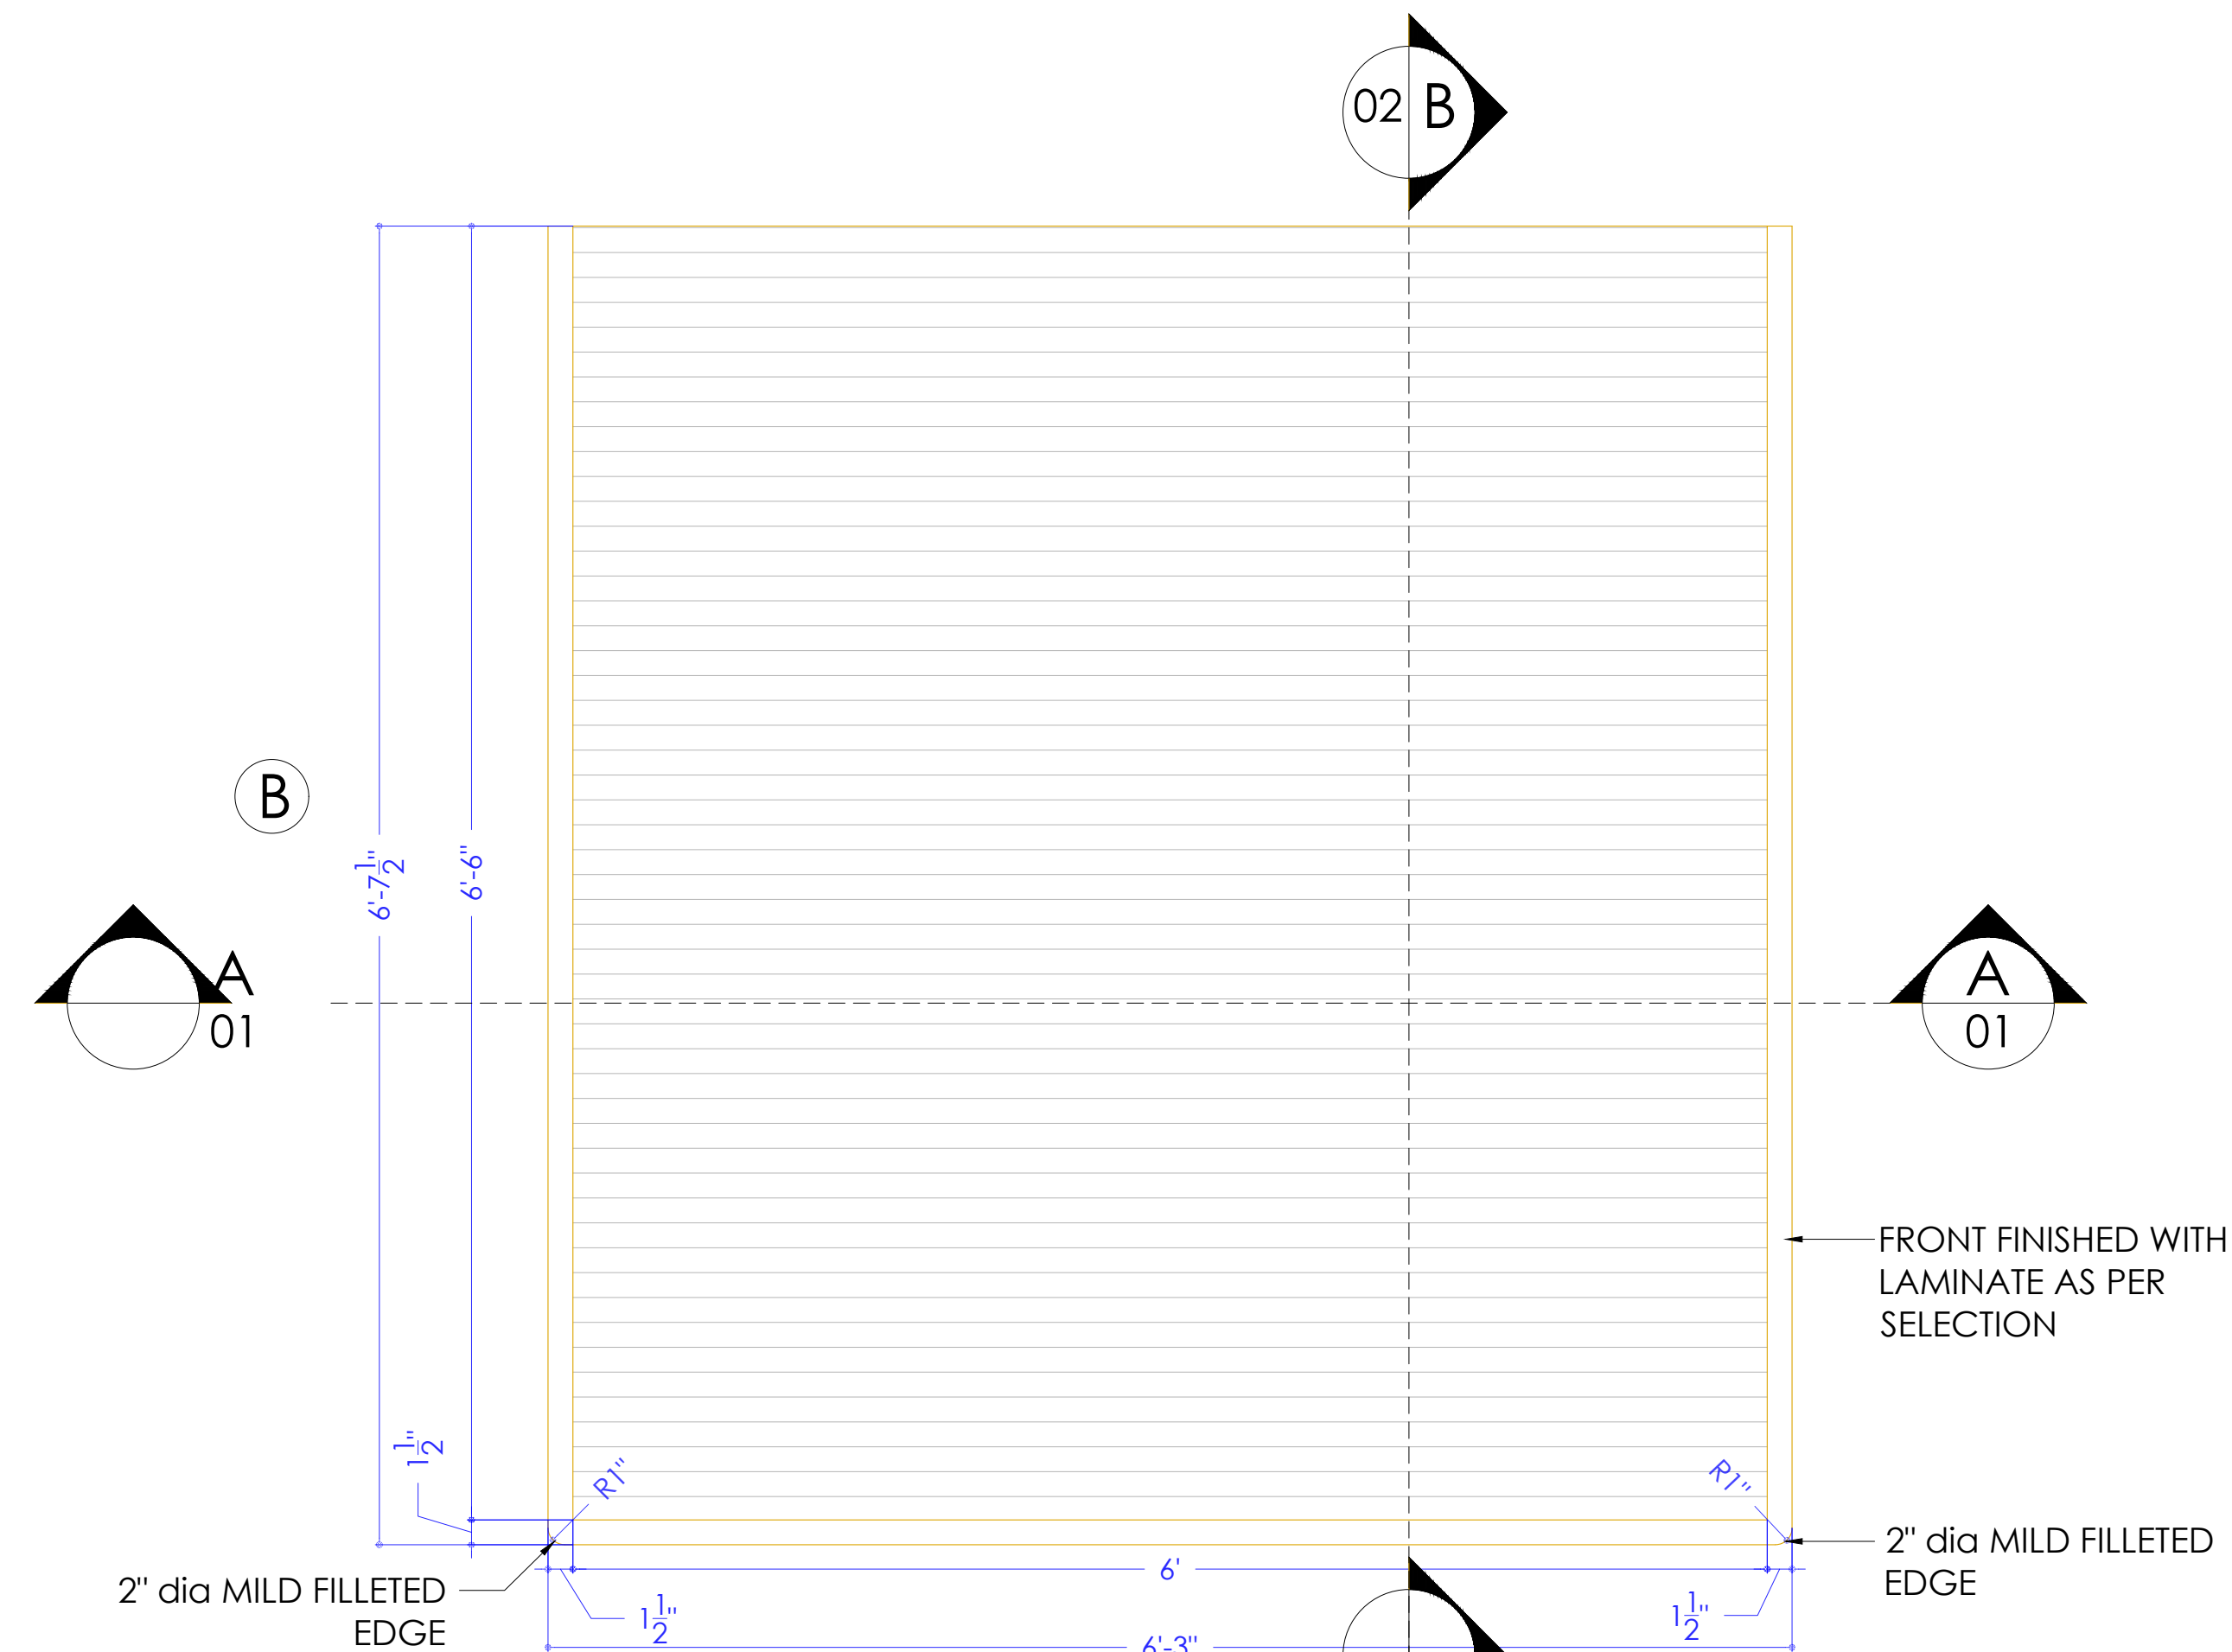


PLAN

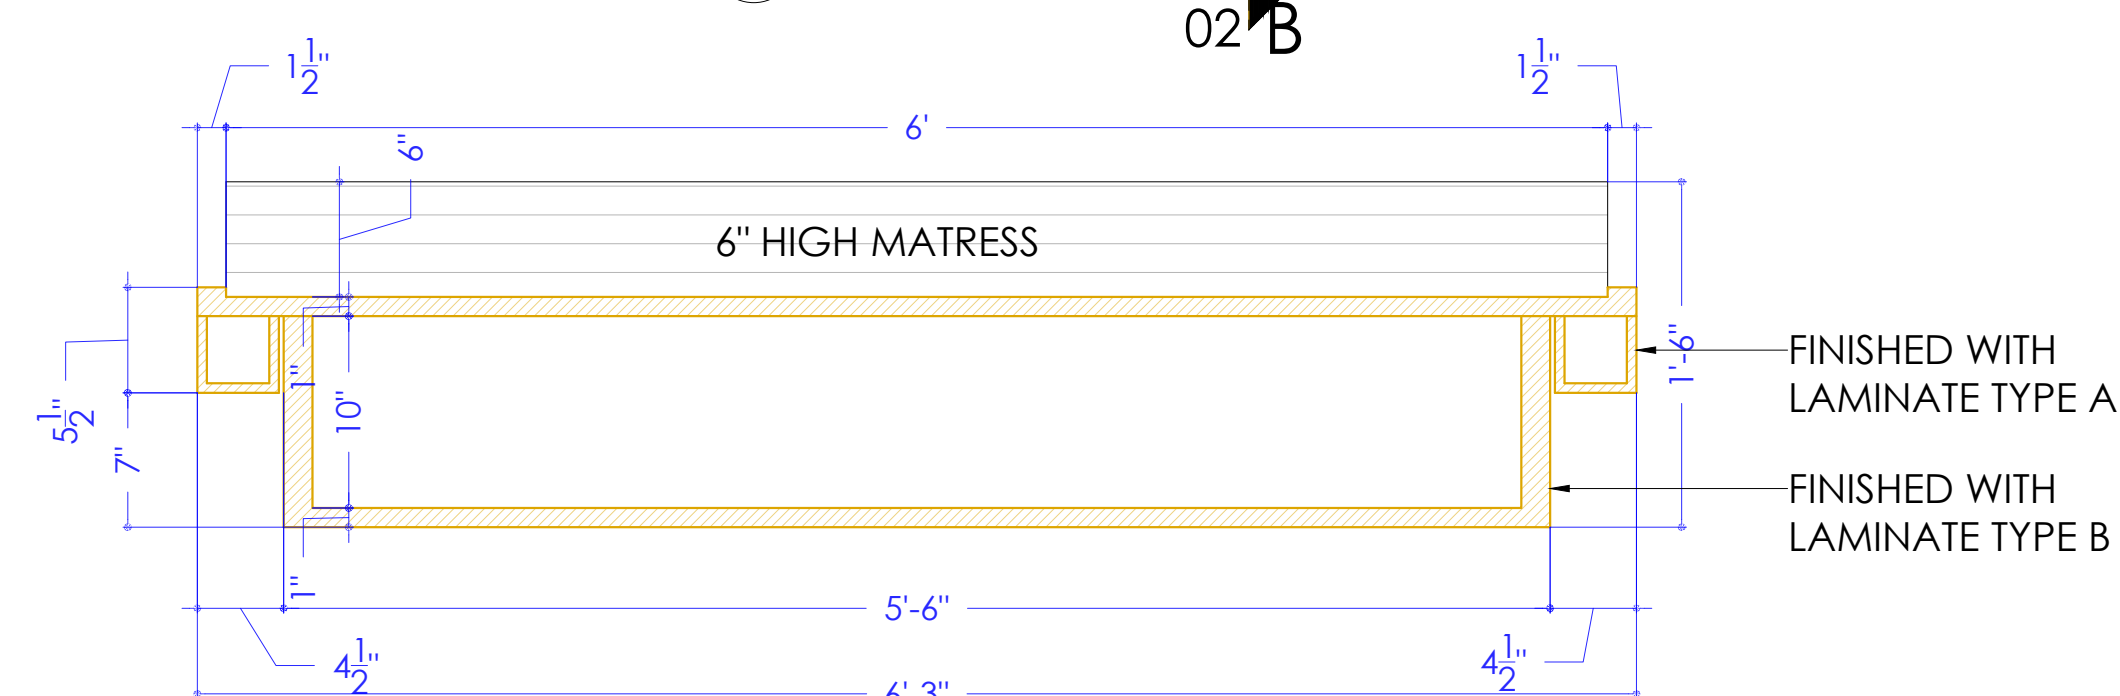


SECTION AA

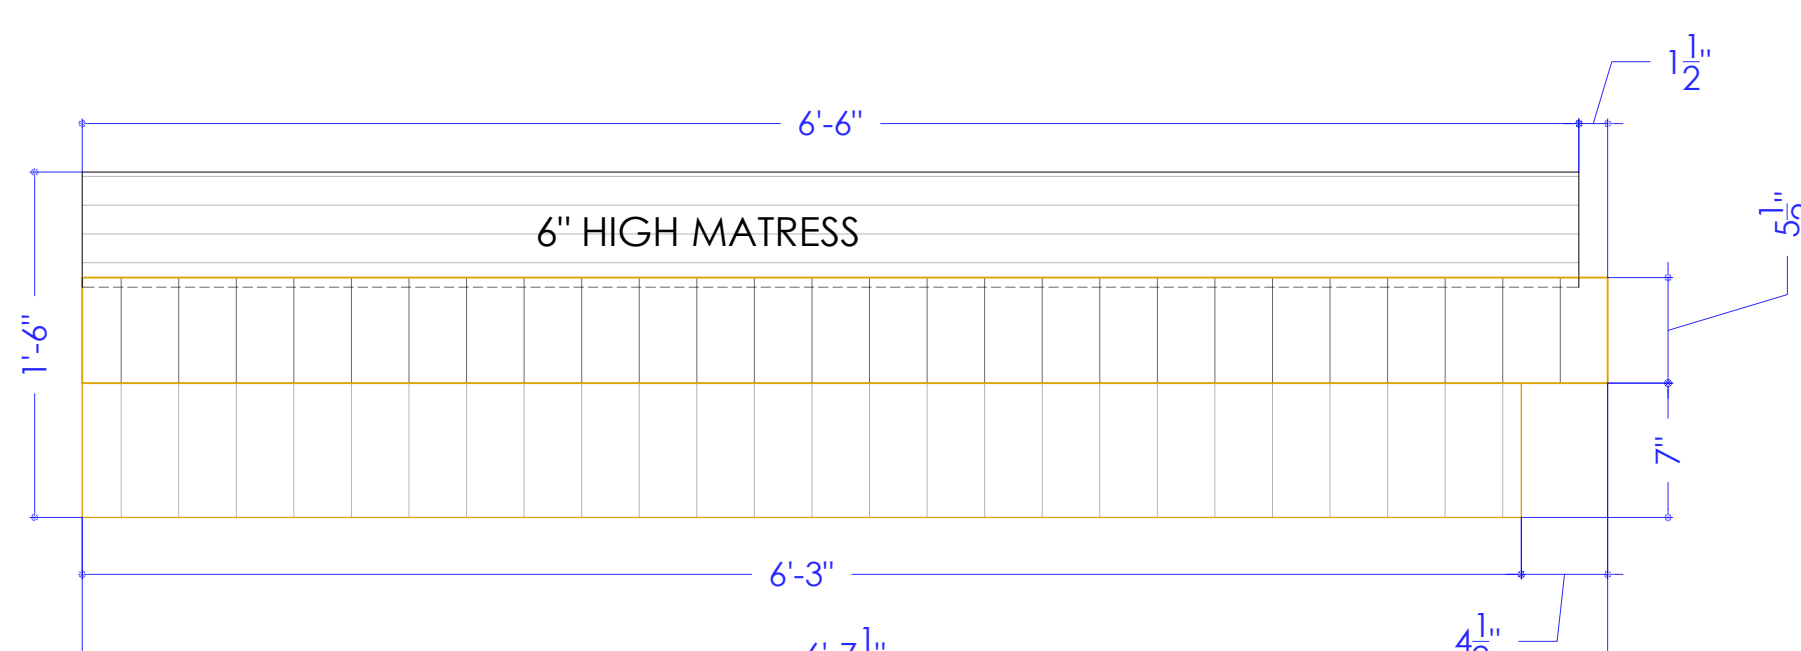


ELEVATION B

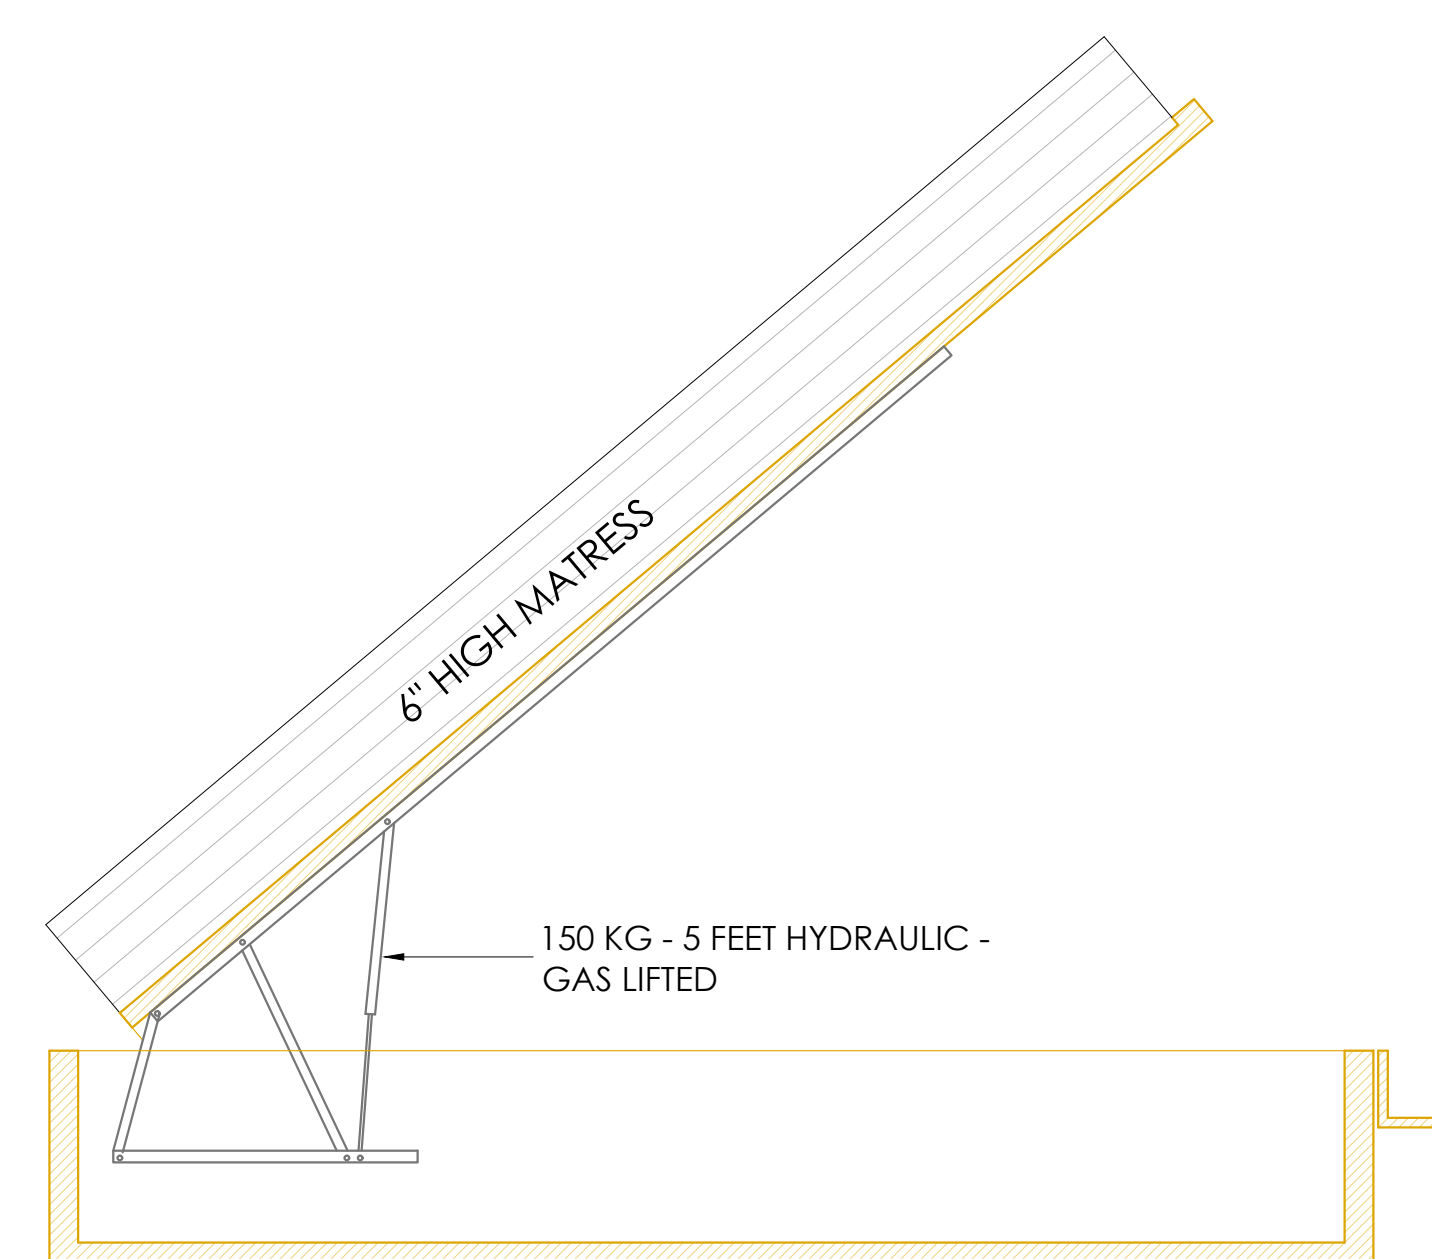

SECTION BB

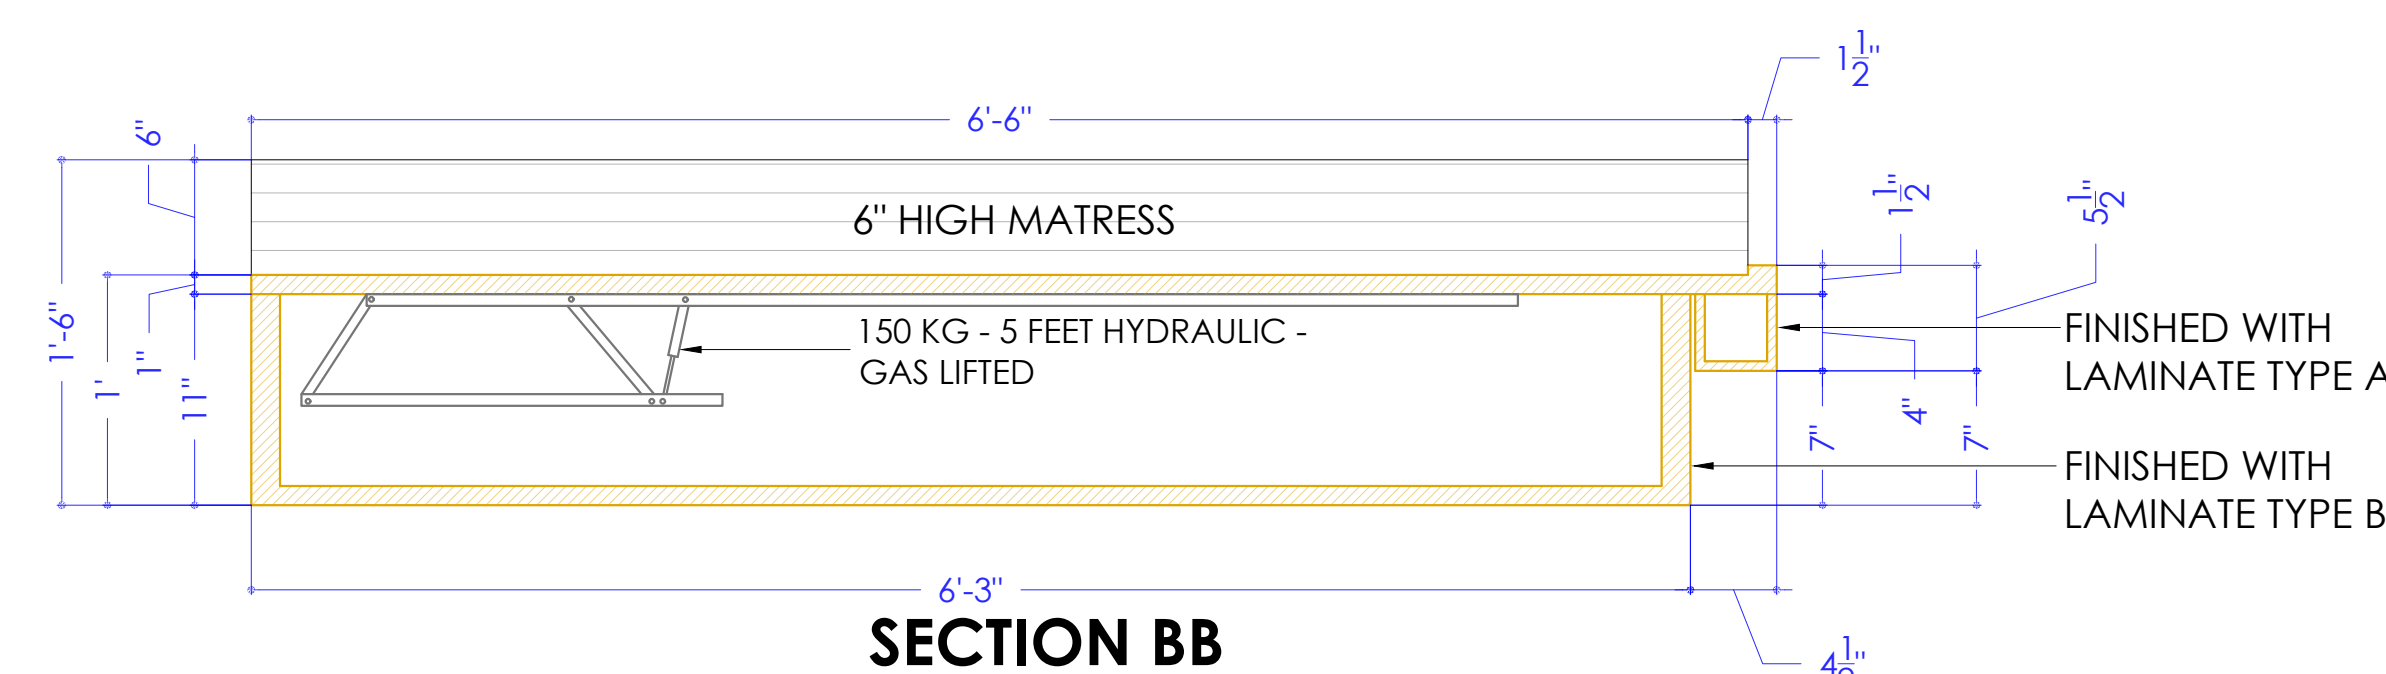

SECTION BB

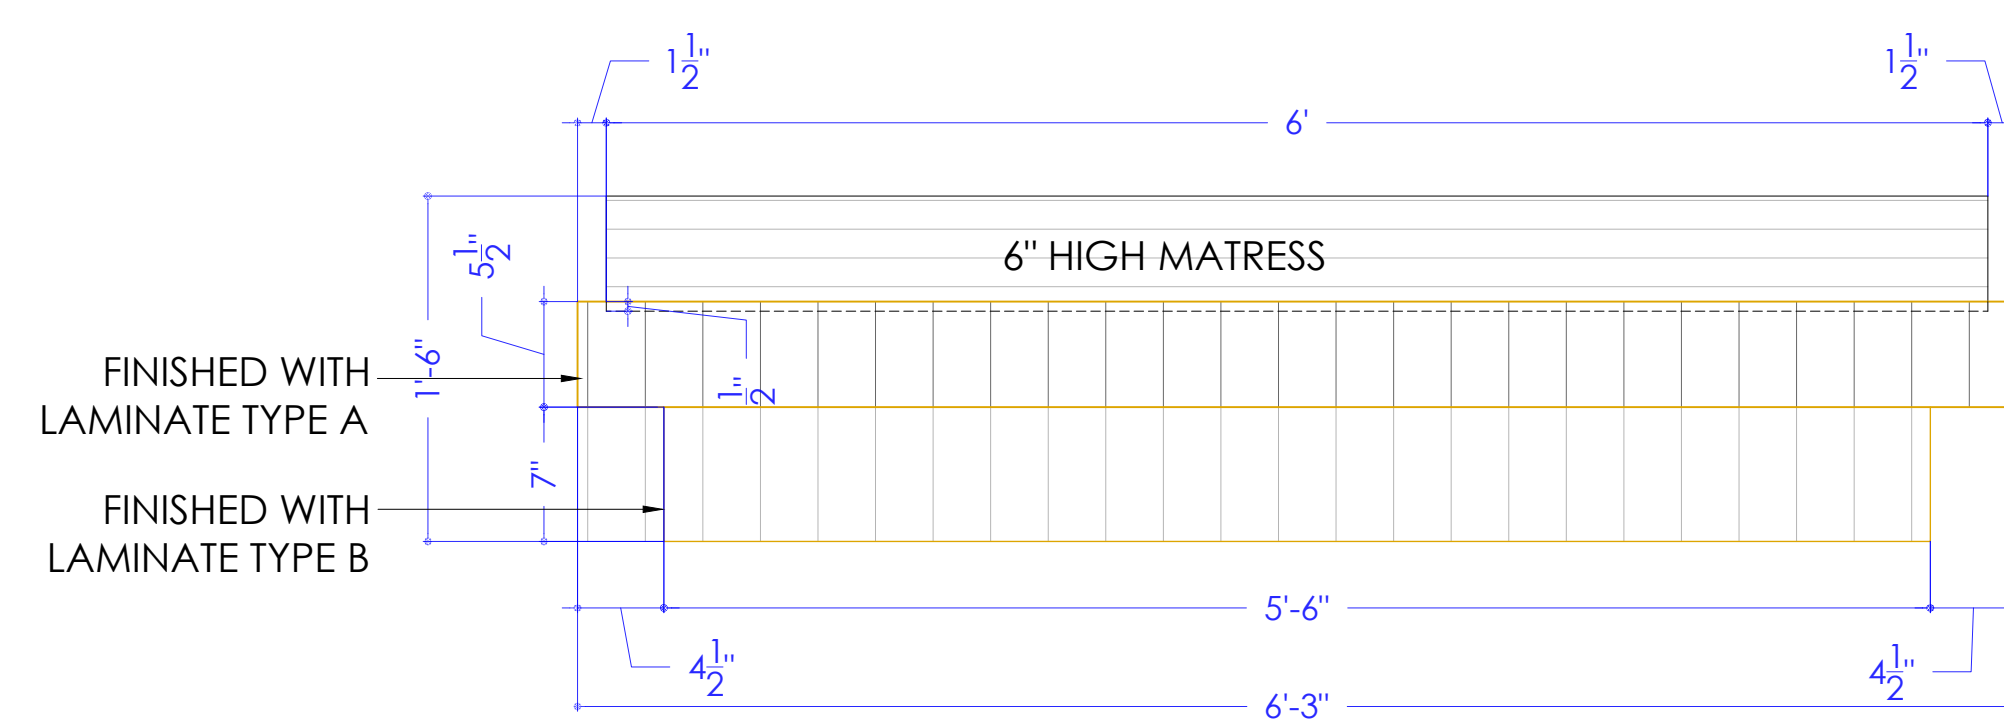

ELEVATION A

PROJECT NAME - MR. GOSWAMI


DRAWING NAME - BED WORKING DETAILS
MASTER BEDROOM


- Only written dimension should be followed.
- All dimension should be checked by contractor and any discrepancy in them shall be brought to the notice of Architect before execution.
- Structure details (beam & column) taken here are as given by structural engineer.
- All dimensions are feet & inch.

DRAWN BY - ADITYA


CHECKED BY -

DATE - 15 - 10 - 2022

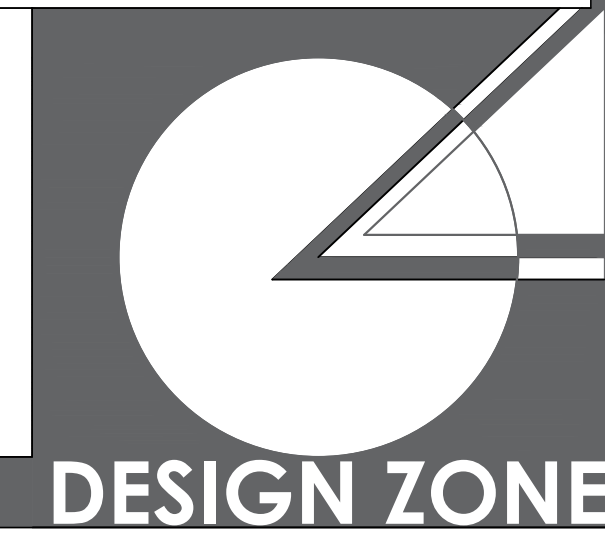


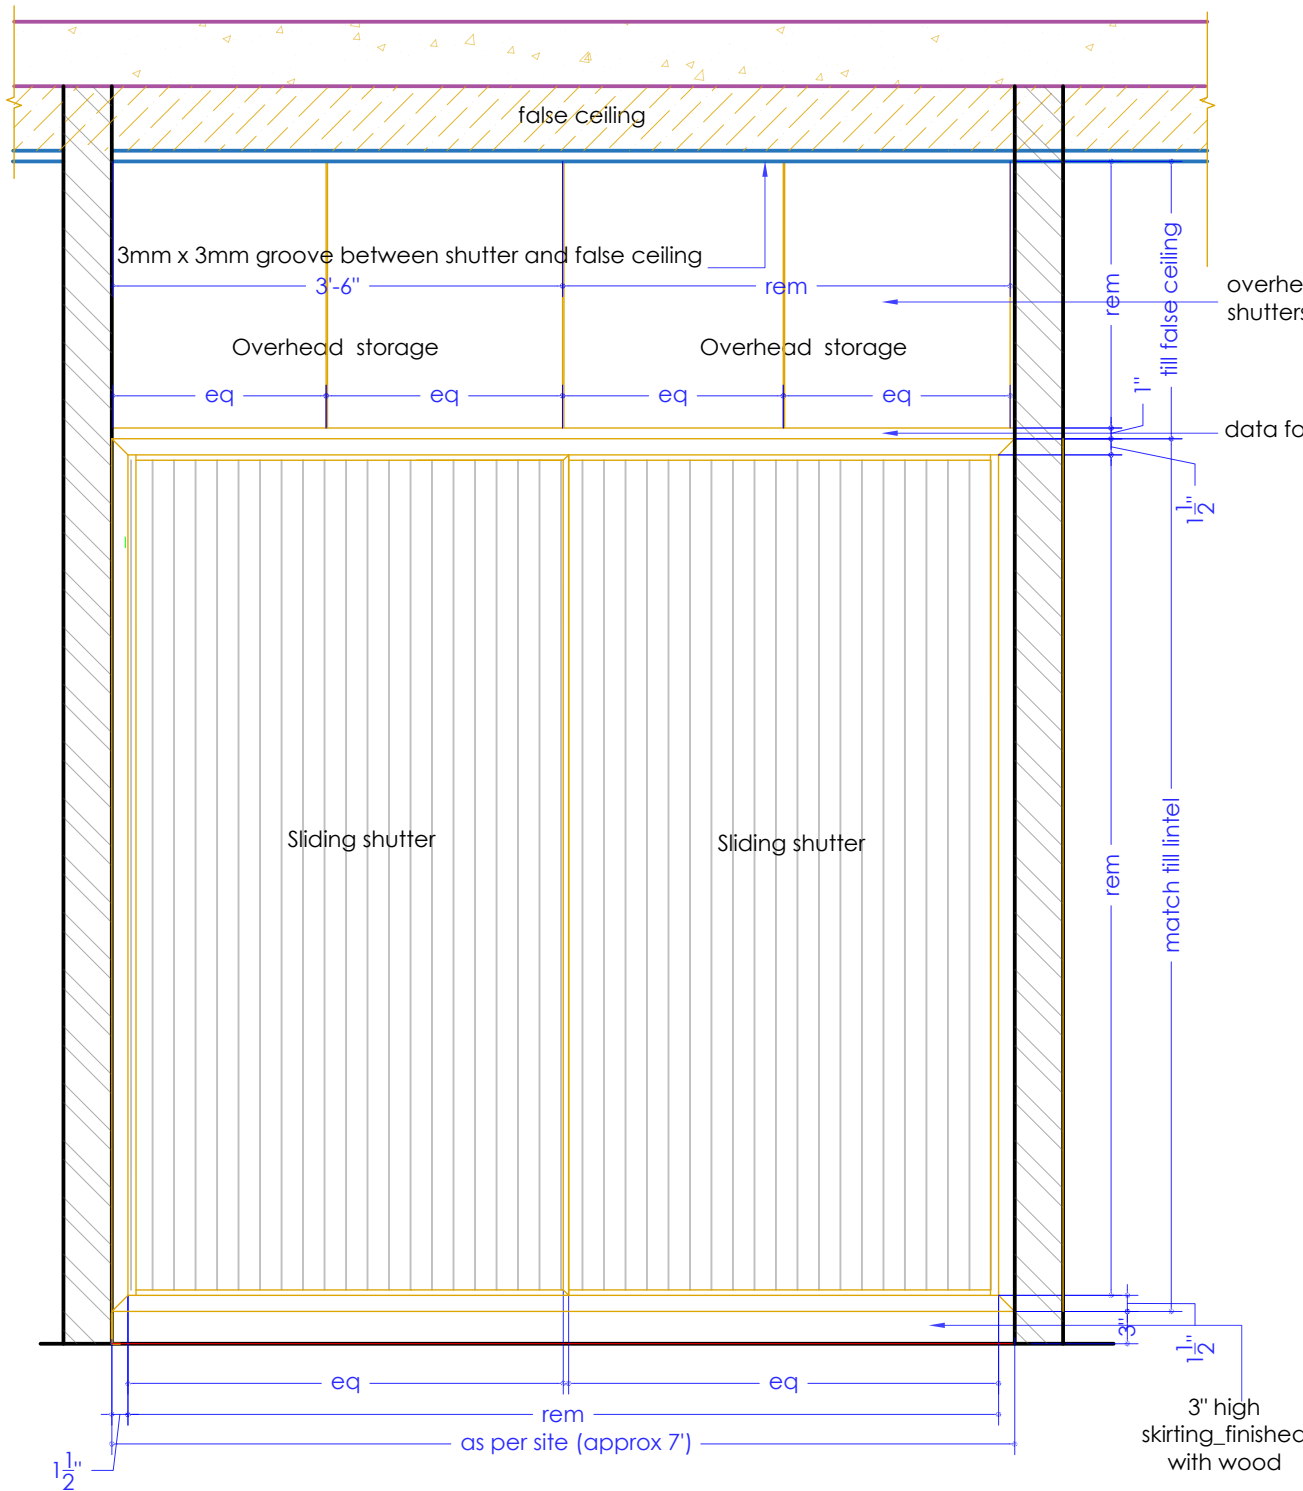


FRONT ELEVATION

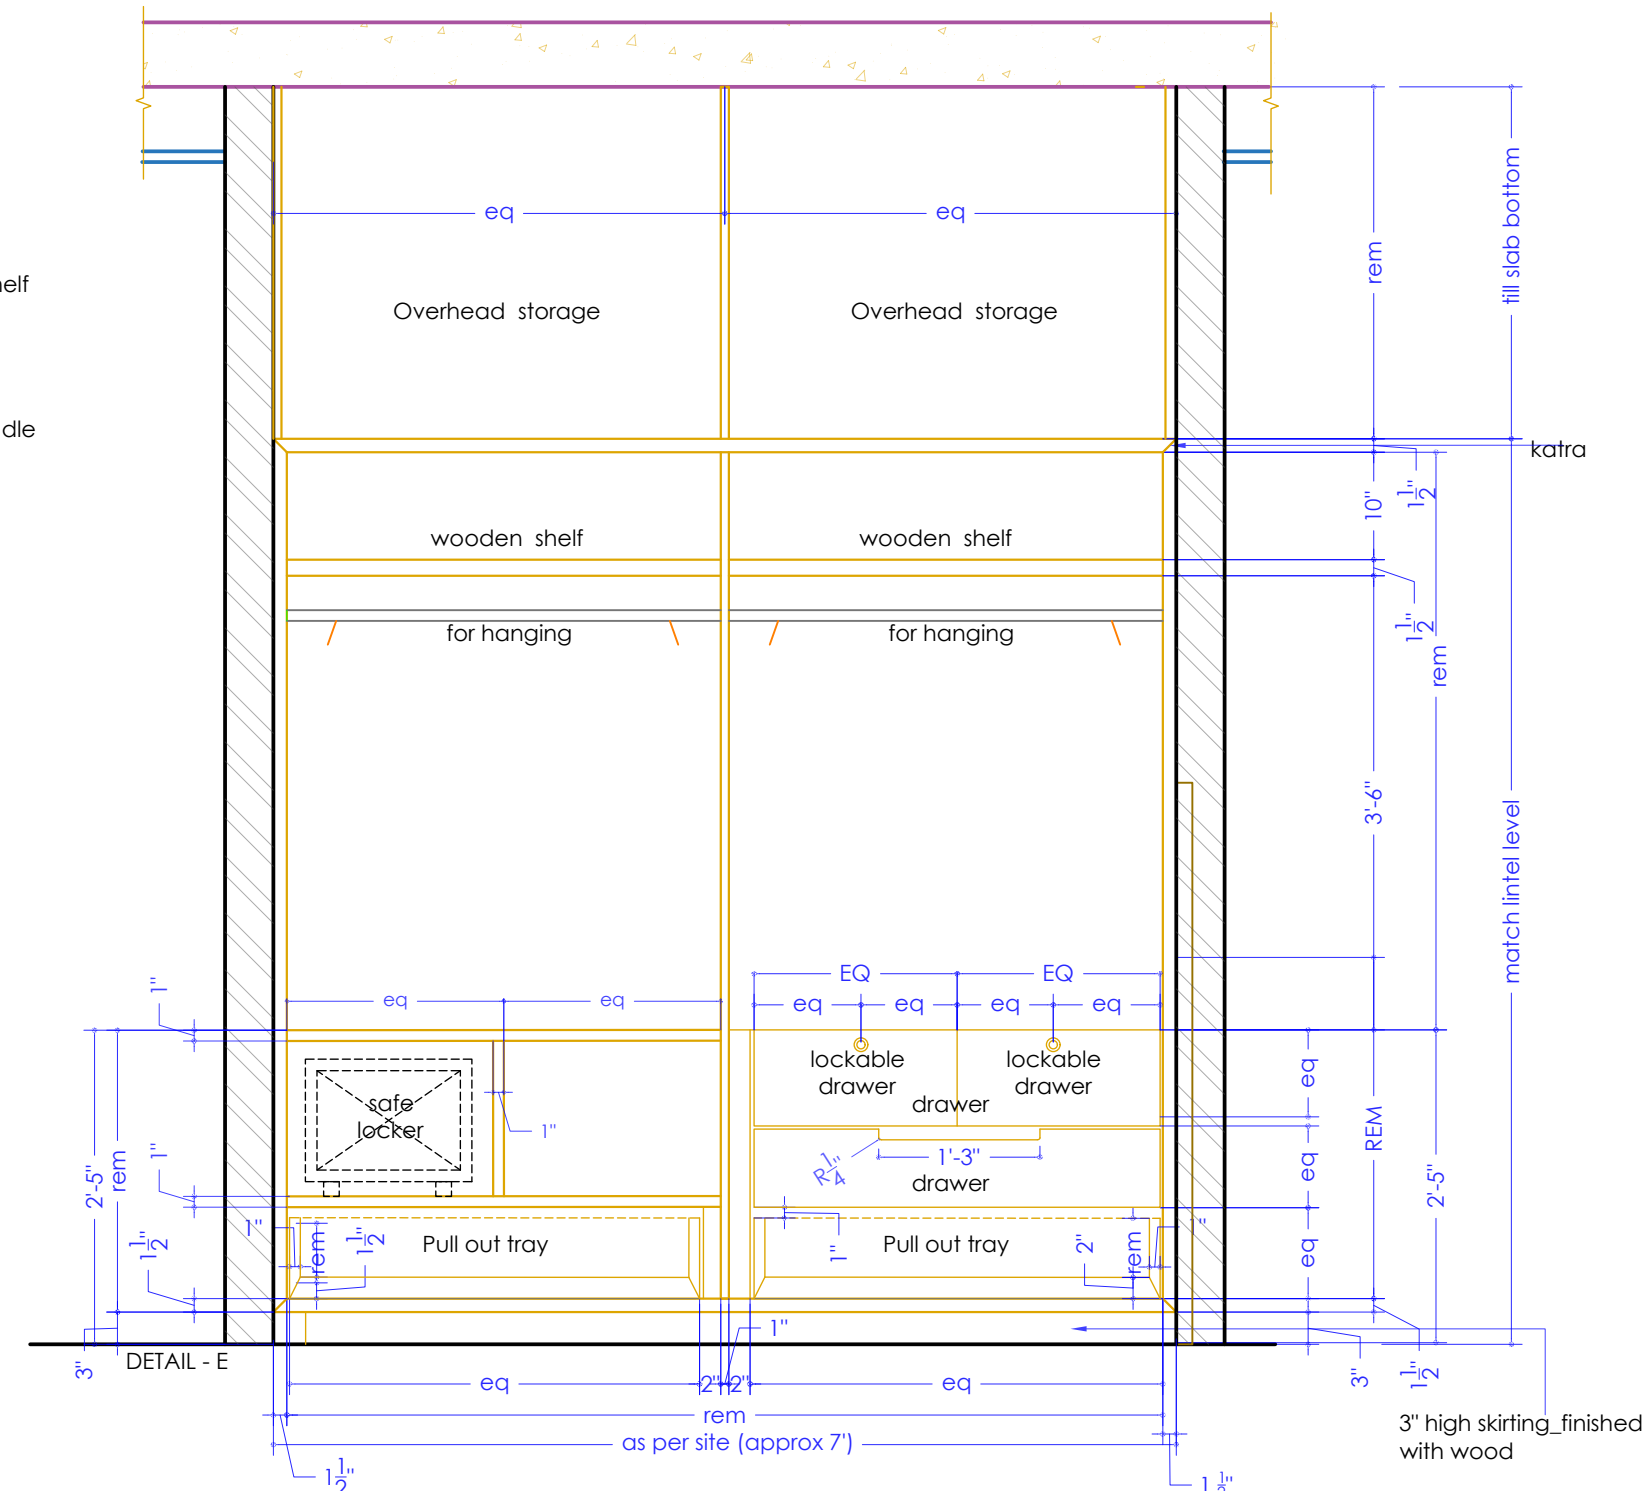


SECTION AA'

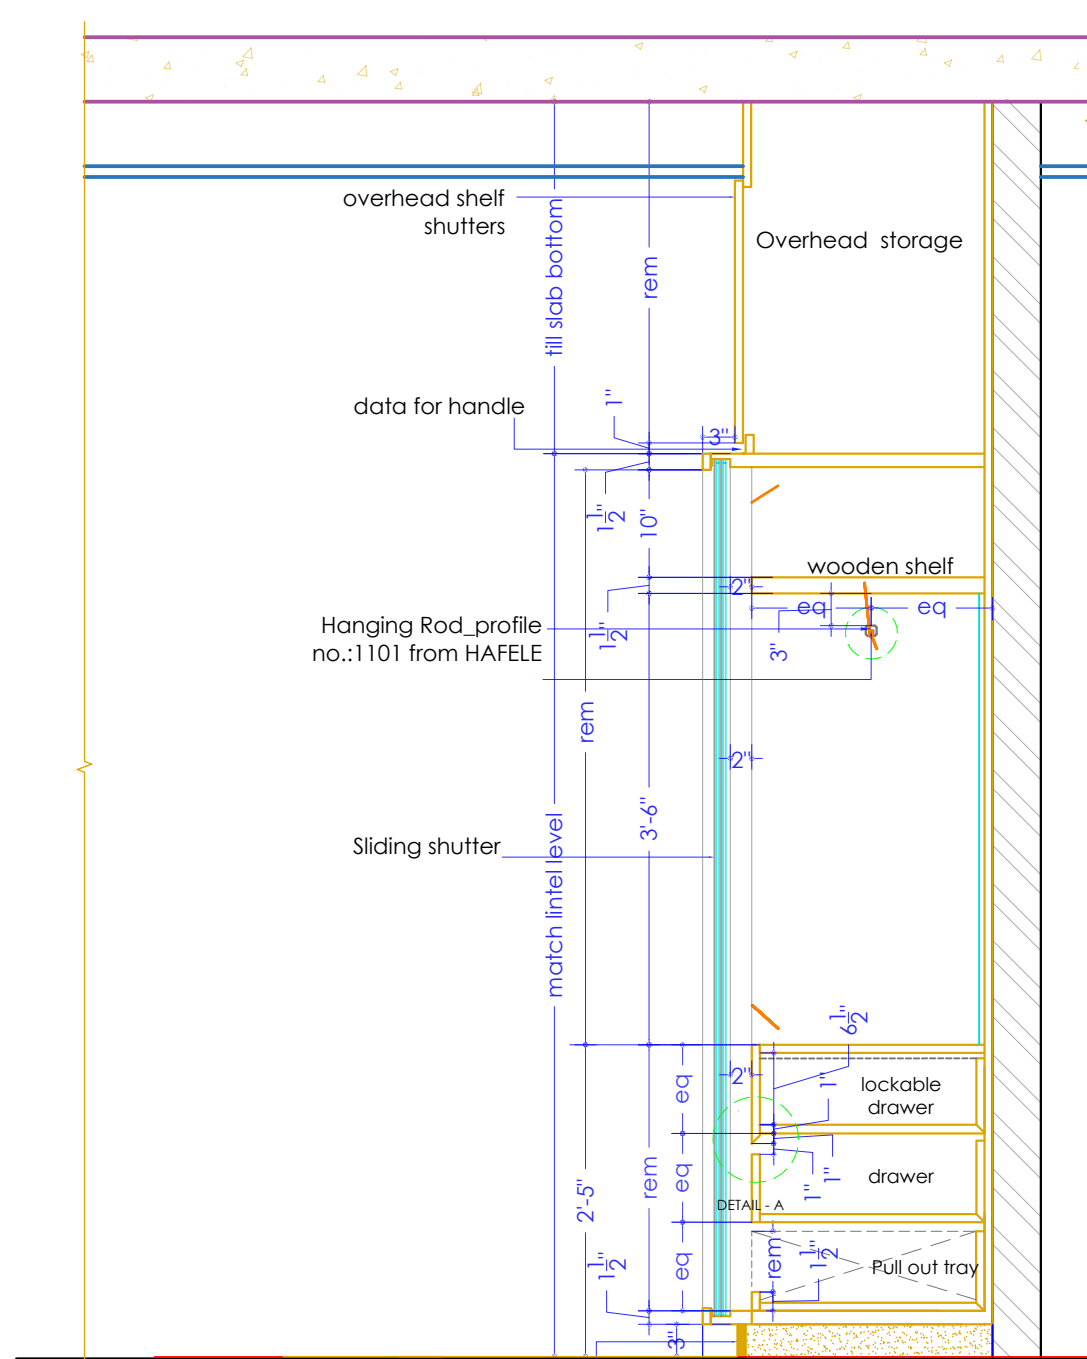

SECTION BB'

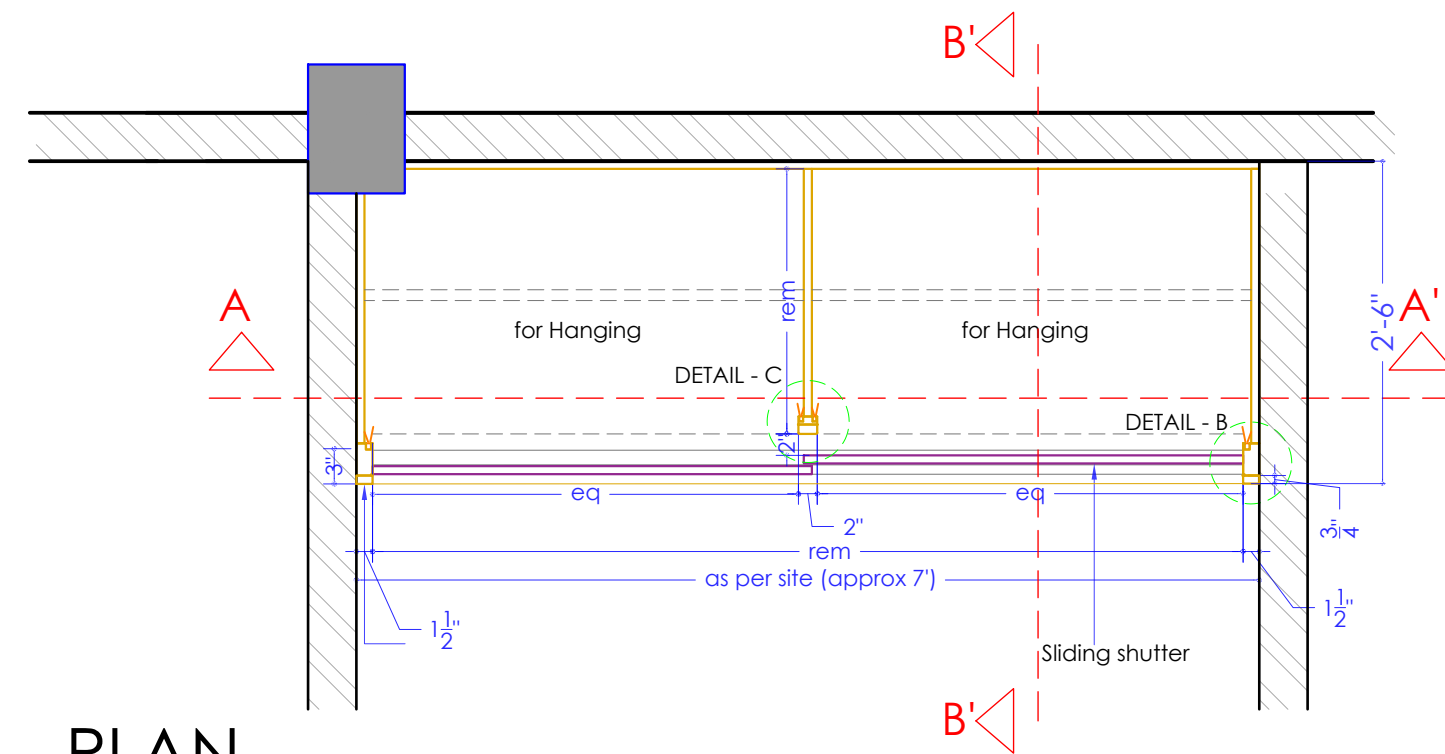


PLAN

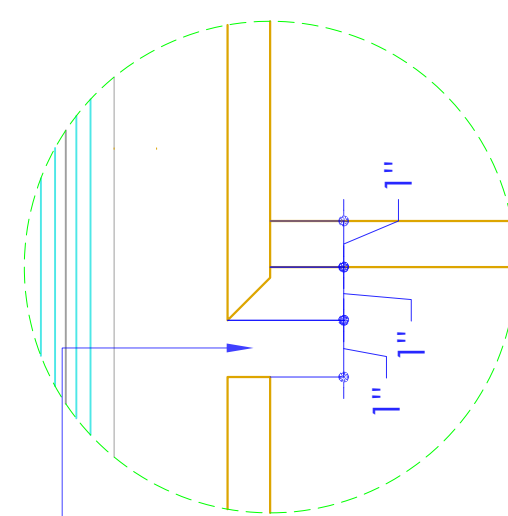


Data For Handle

DETAIL - A

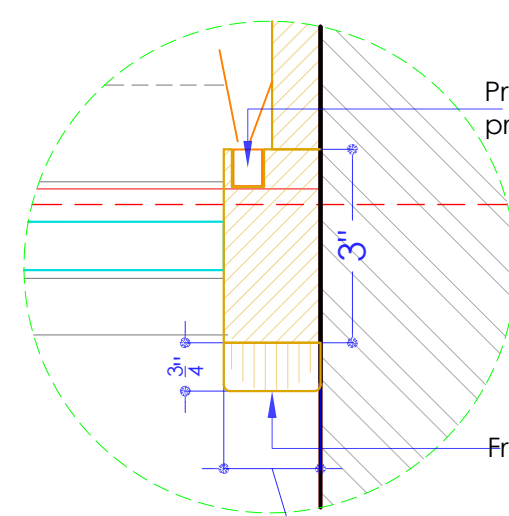

DETAIL - B

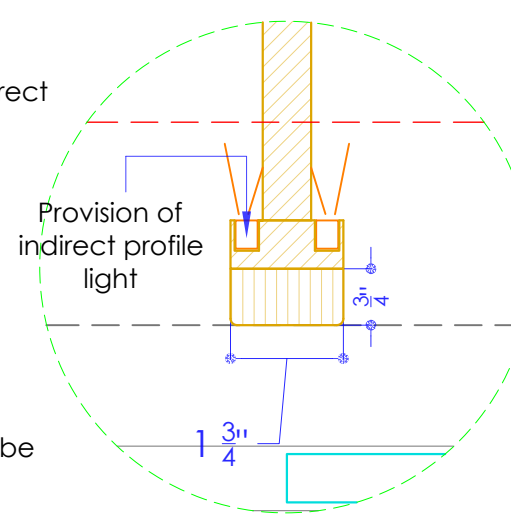

DETAIL - C

PROJECT NAME - MR. PRASHIV SHARMA



DRAWING NAME - REVISED WARDROBE DETAILS 1

DRAWN BY - ADITYA

CHECKED BY -

CHECKED BY - 12 - 09 - 2022



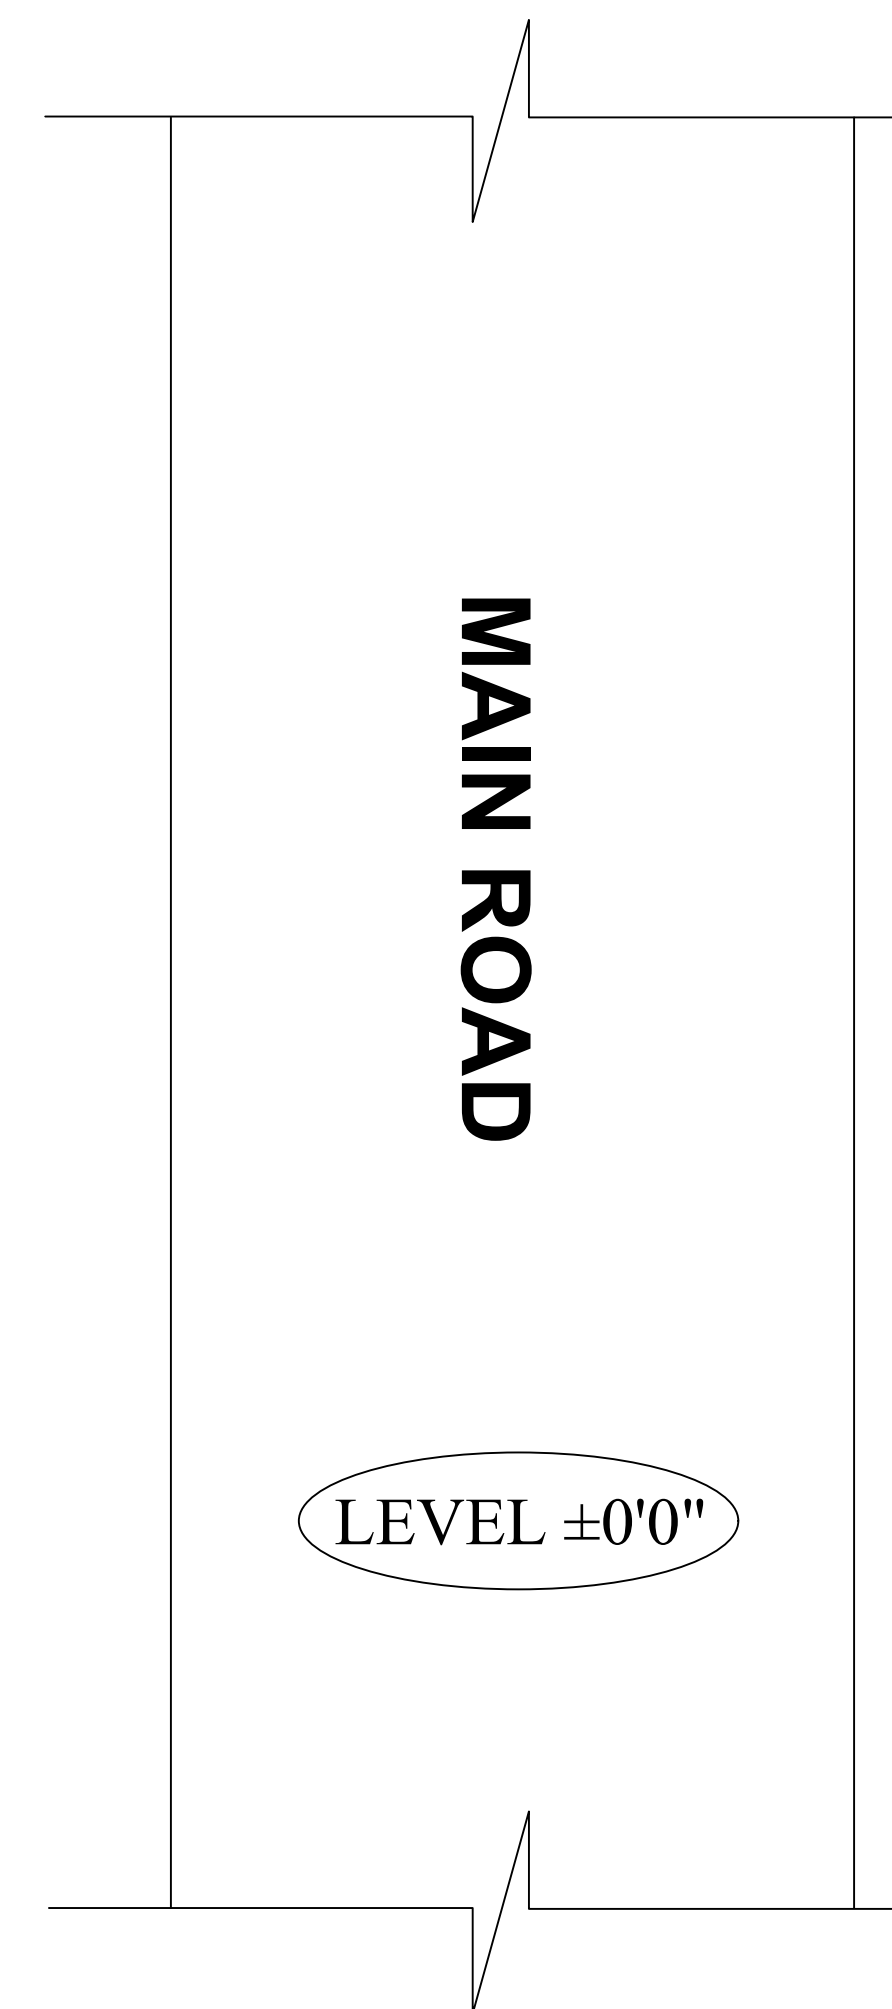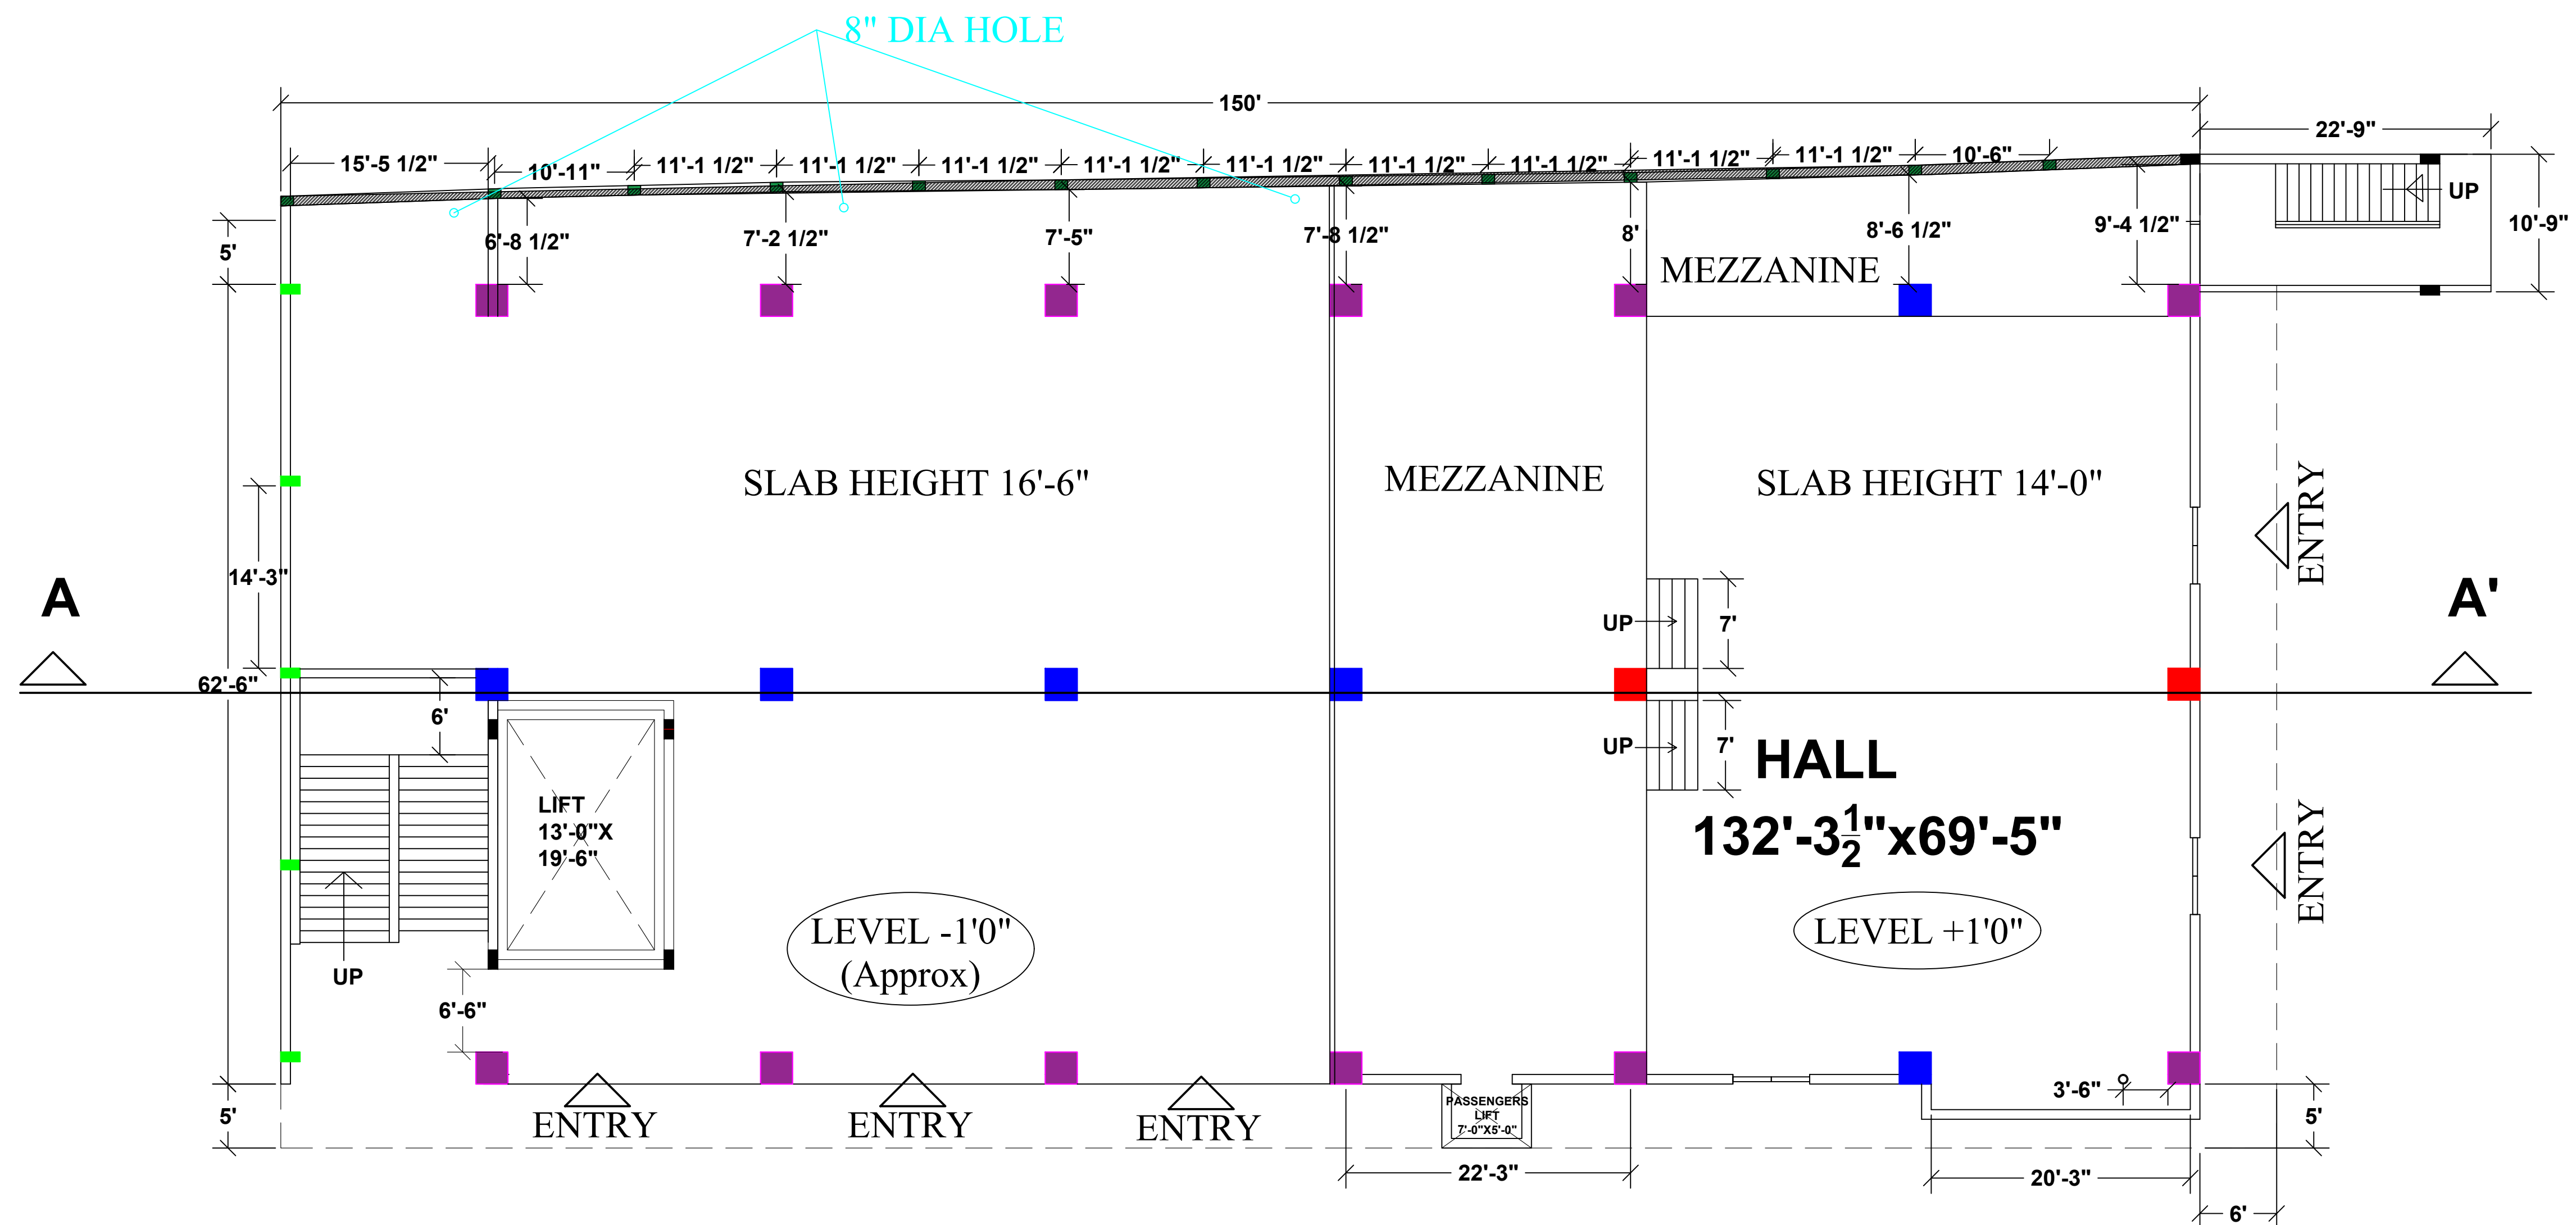

GROUND FL. PLAN

DRAWINGS
FOR
STUDY ONLY

PROJECT NAME - MR. ANMOL WADHWA

DRAWING NAME - GROUND FL. PLAN

- Only written dimension should be followed.
- All dimension should be checked by contractor and any discrepancy in them shall be brought to the notice of Architect before execution.
- Structure details (beam & column) taken here are as given by structural engineer.
- All dimensions are feet & inch.


DRAWN BY - ADITYA

CHECKED BY - DEVENDRA

DATE - 15 - 10 - 2022



DESIGN ZONE

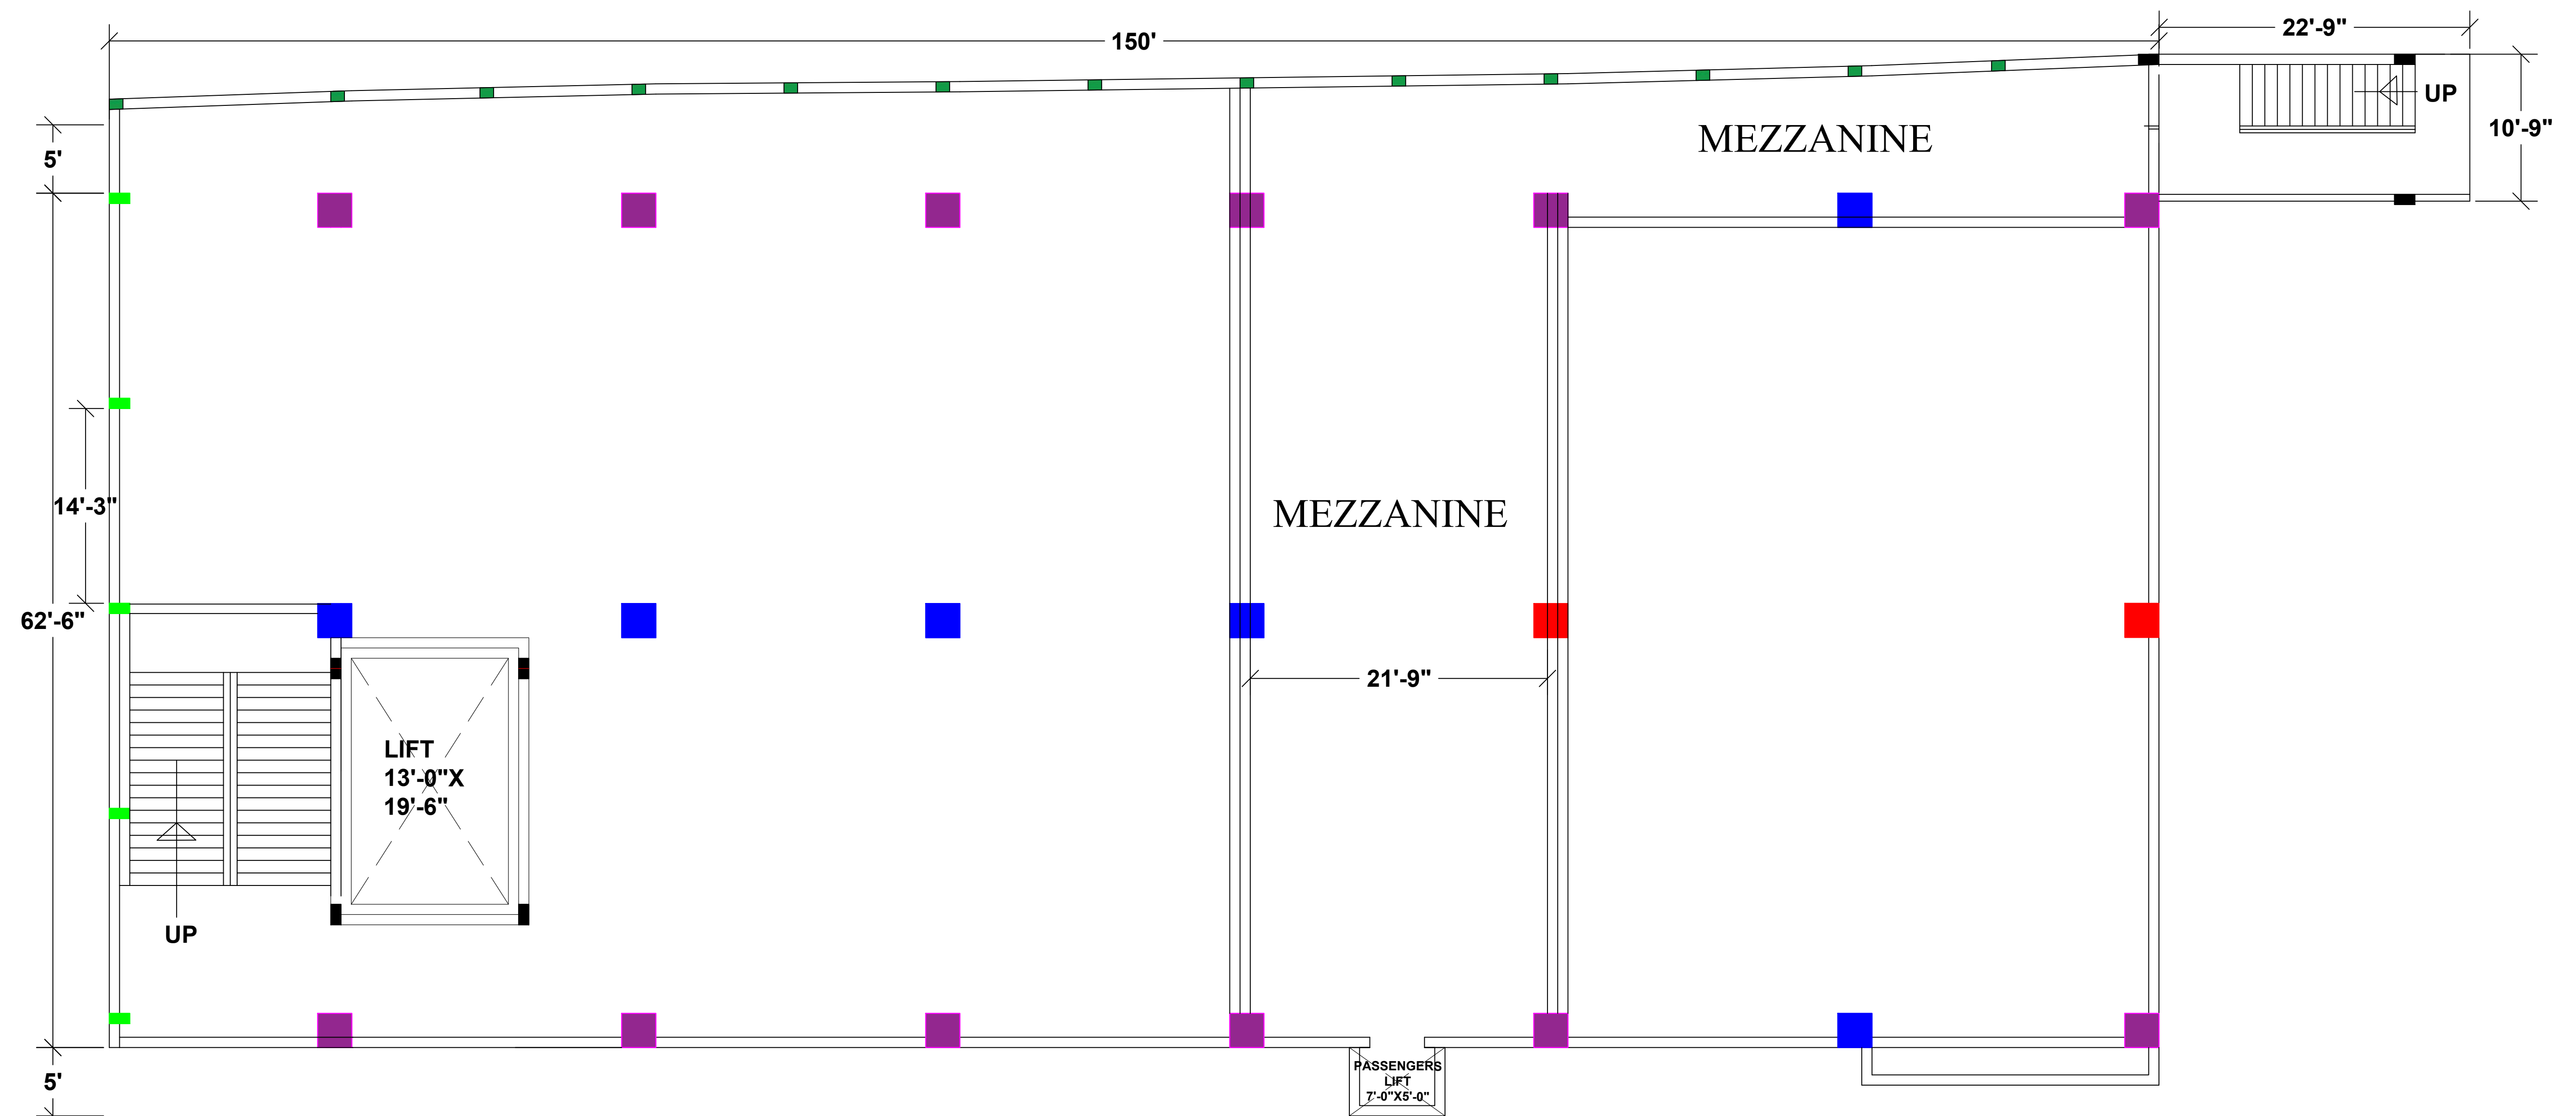

PROJECT NAME - MR. ANMOL WADHWA

DRAWING NAME - GROUND FL. PLAN

- Only written dimension should be followed.
- All dimension should be checked by contractor and any discrepancy in them shall be brought to the notice of Architect before execution.
- Structure details (beam & column) taken here are as given by structural engineer.
- All dimensions are feet & inch.


DRAWN BY - ADITYA

CHECKED BY - DEVENDRA

DATE - 15 - 10 - 2022



DESIGN ZONE

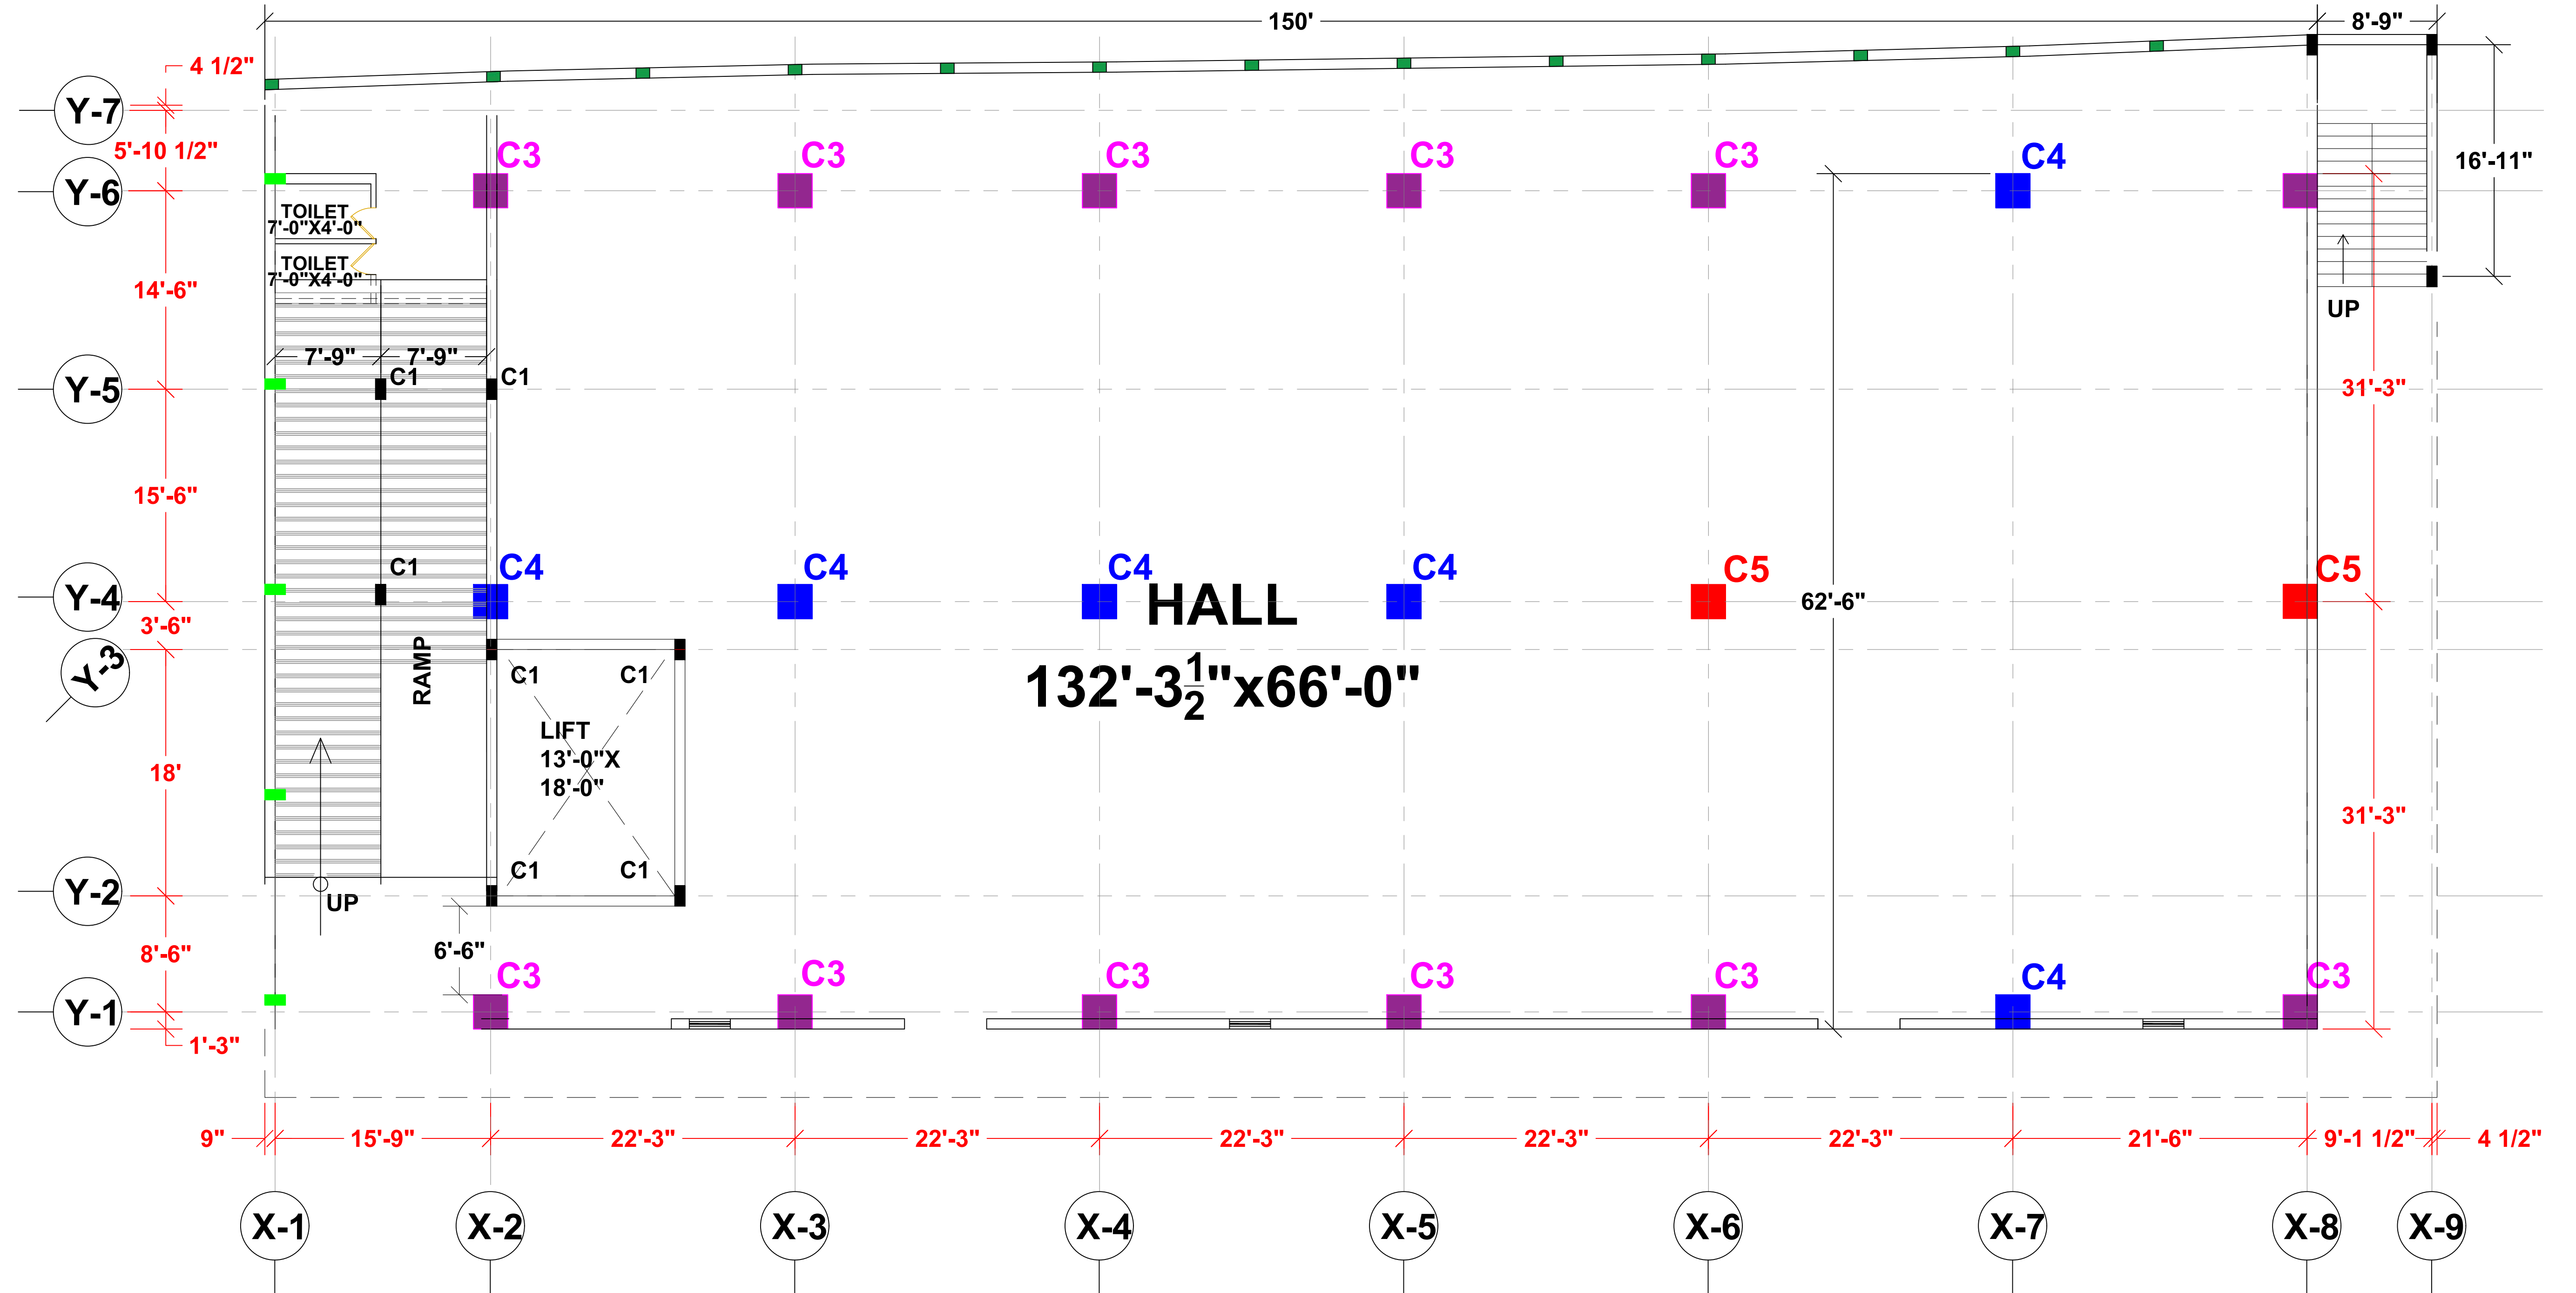

PROJECT NAME - MR. ANMOL WADHWA

DRAWING NAME - COLUMN DETAILS

- Only written dimension should be followed.
- All dimension should be checked by contractor and any discrepancy in them shall be brought to the notice of Architect before execution.
- Structure details (beam & column) taken here are as given by structural engineer.
- All dimensions are feet & inch.


DRAWN BY - ADITYA

CHECKED BY - DEVENDRA

DATE - 11 - 11 - 2022



DESIGN ZONE

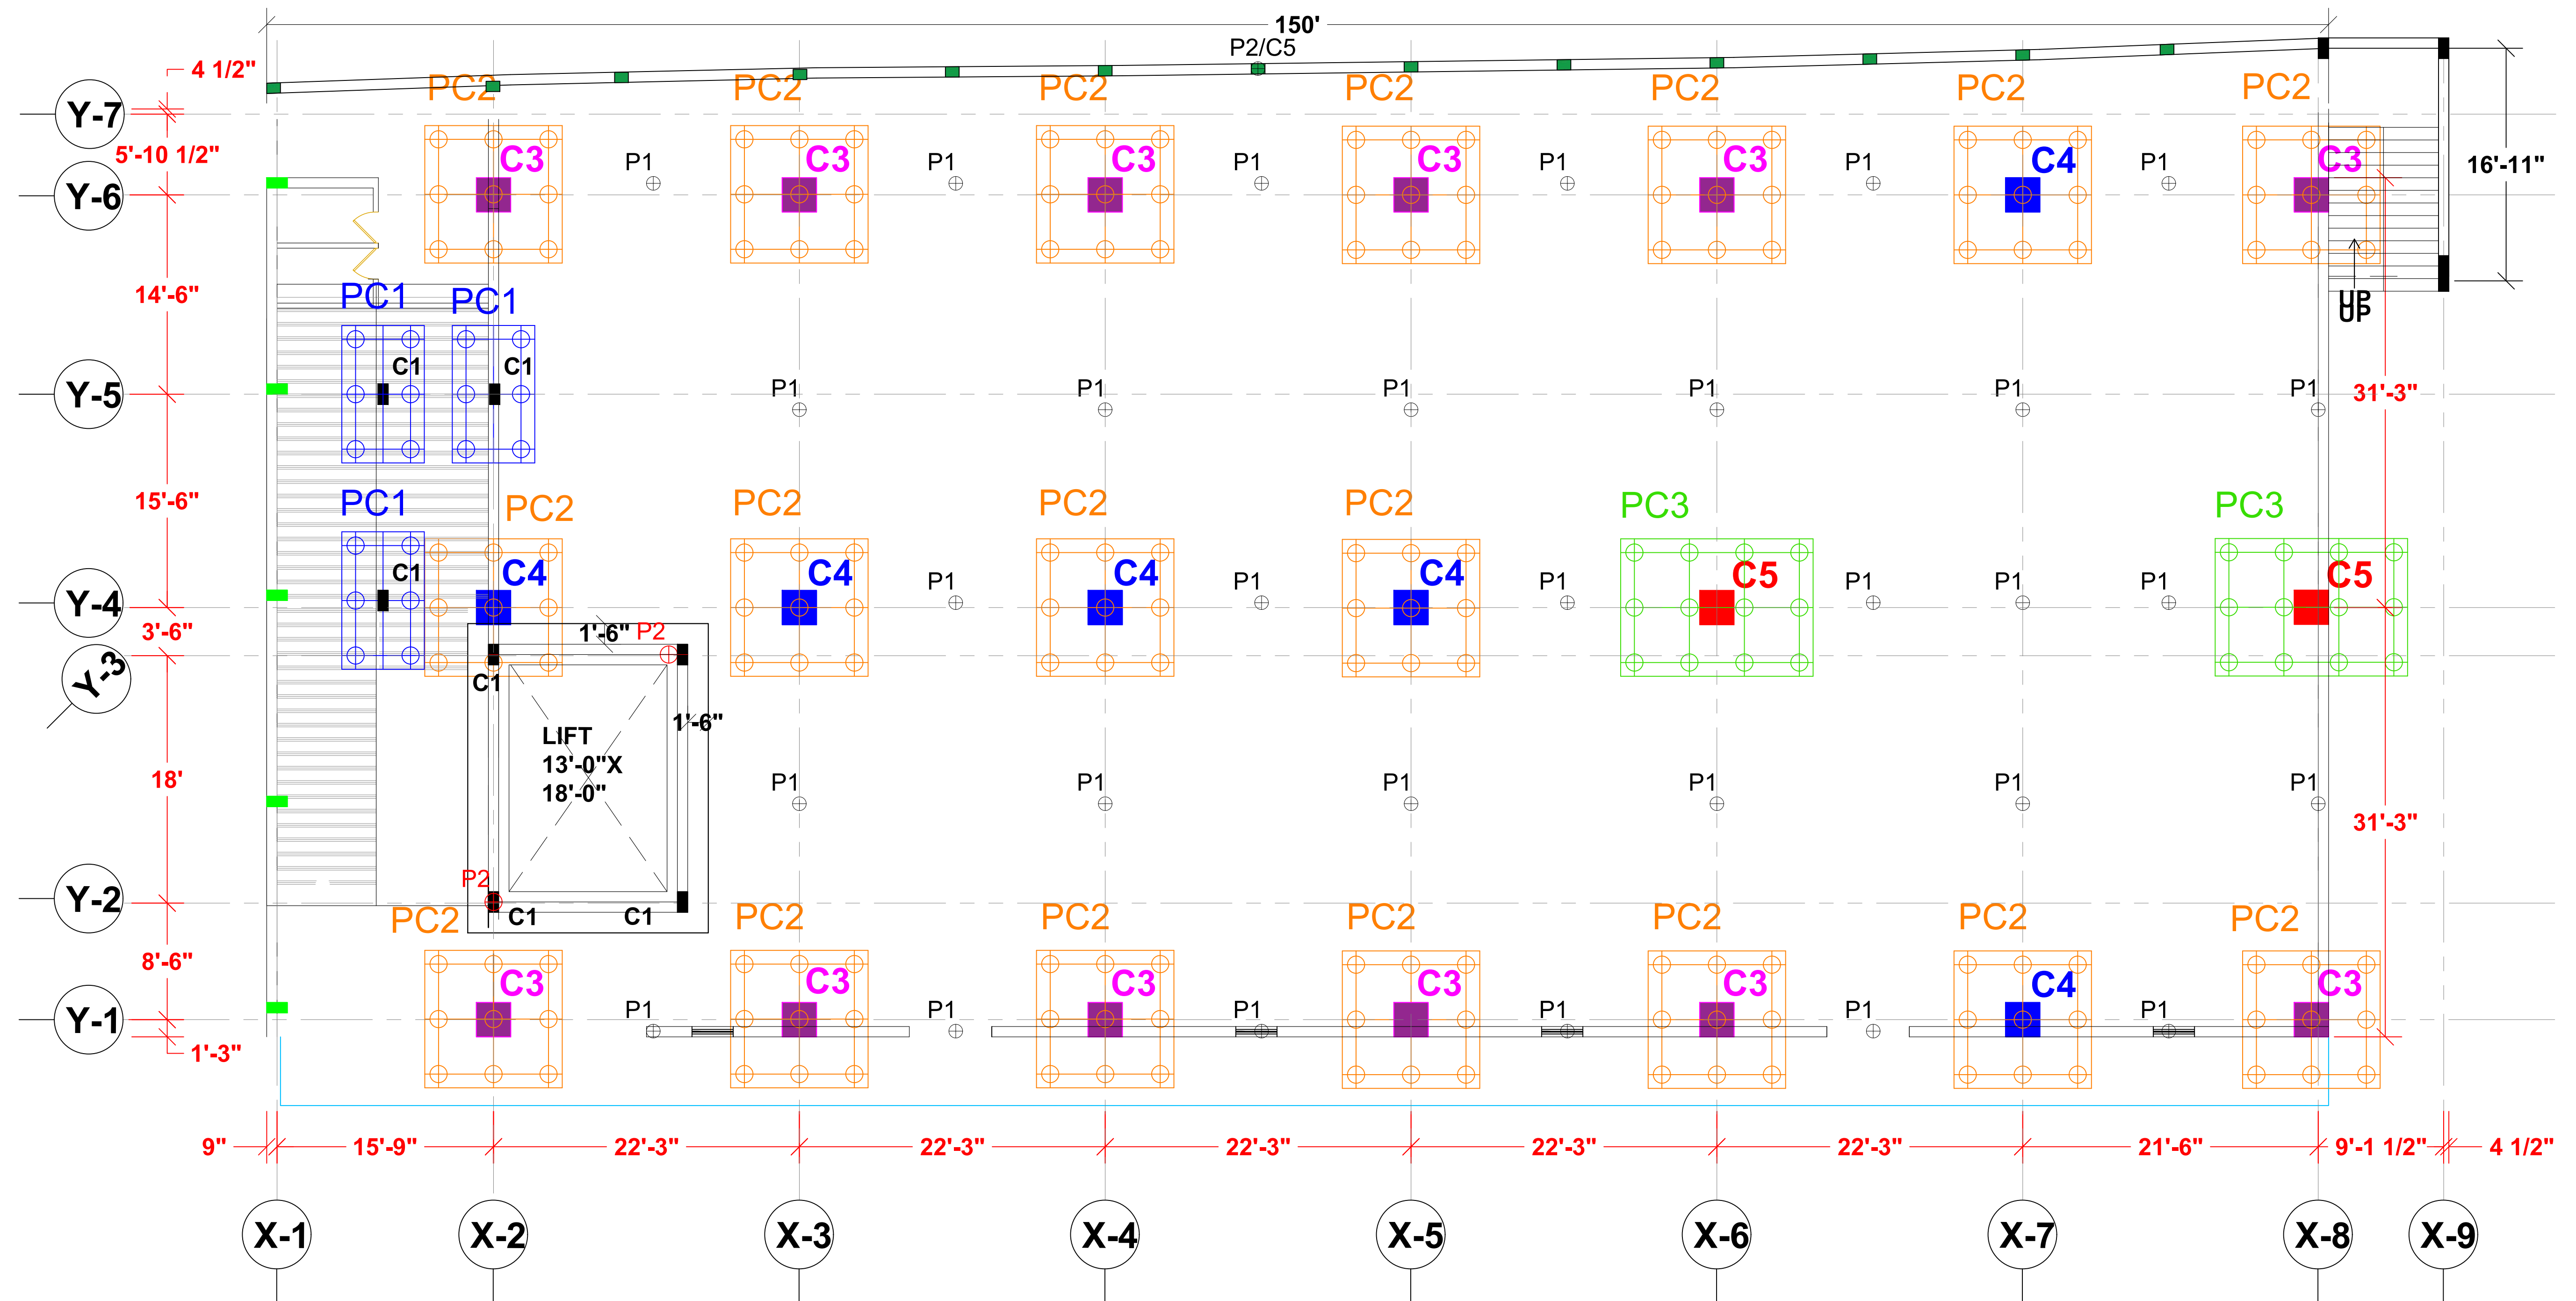

PROJECT NAME - MR. ANMOL WADHWA

DRAWING NAME - FOUNDATION DETAILS

- Only written dimension should be followed.
- All dimension should be checked by contractor and any discrepancy in them shall be brought to the notice of Architect before execution.
- Structure details (beam & column) taken here are as given by structural engineer.
- All dimensions are feet & inch.


DRAWN BY - ADITYA

CHECKED BY - DEVENDRA

DATE - 11 - 11 - 2022



DESIGN ZONE

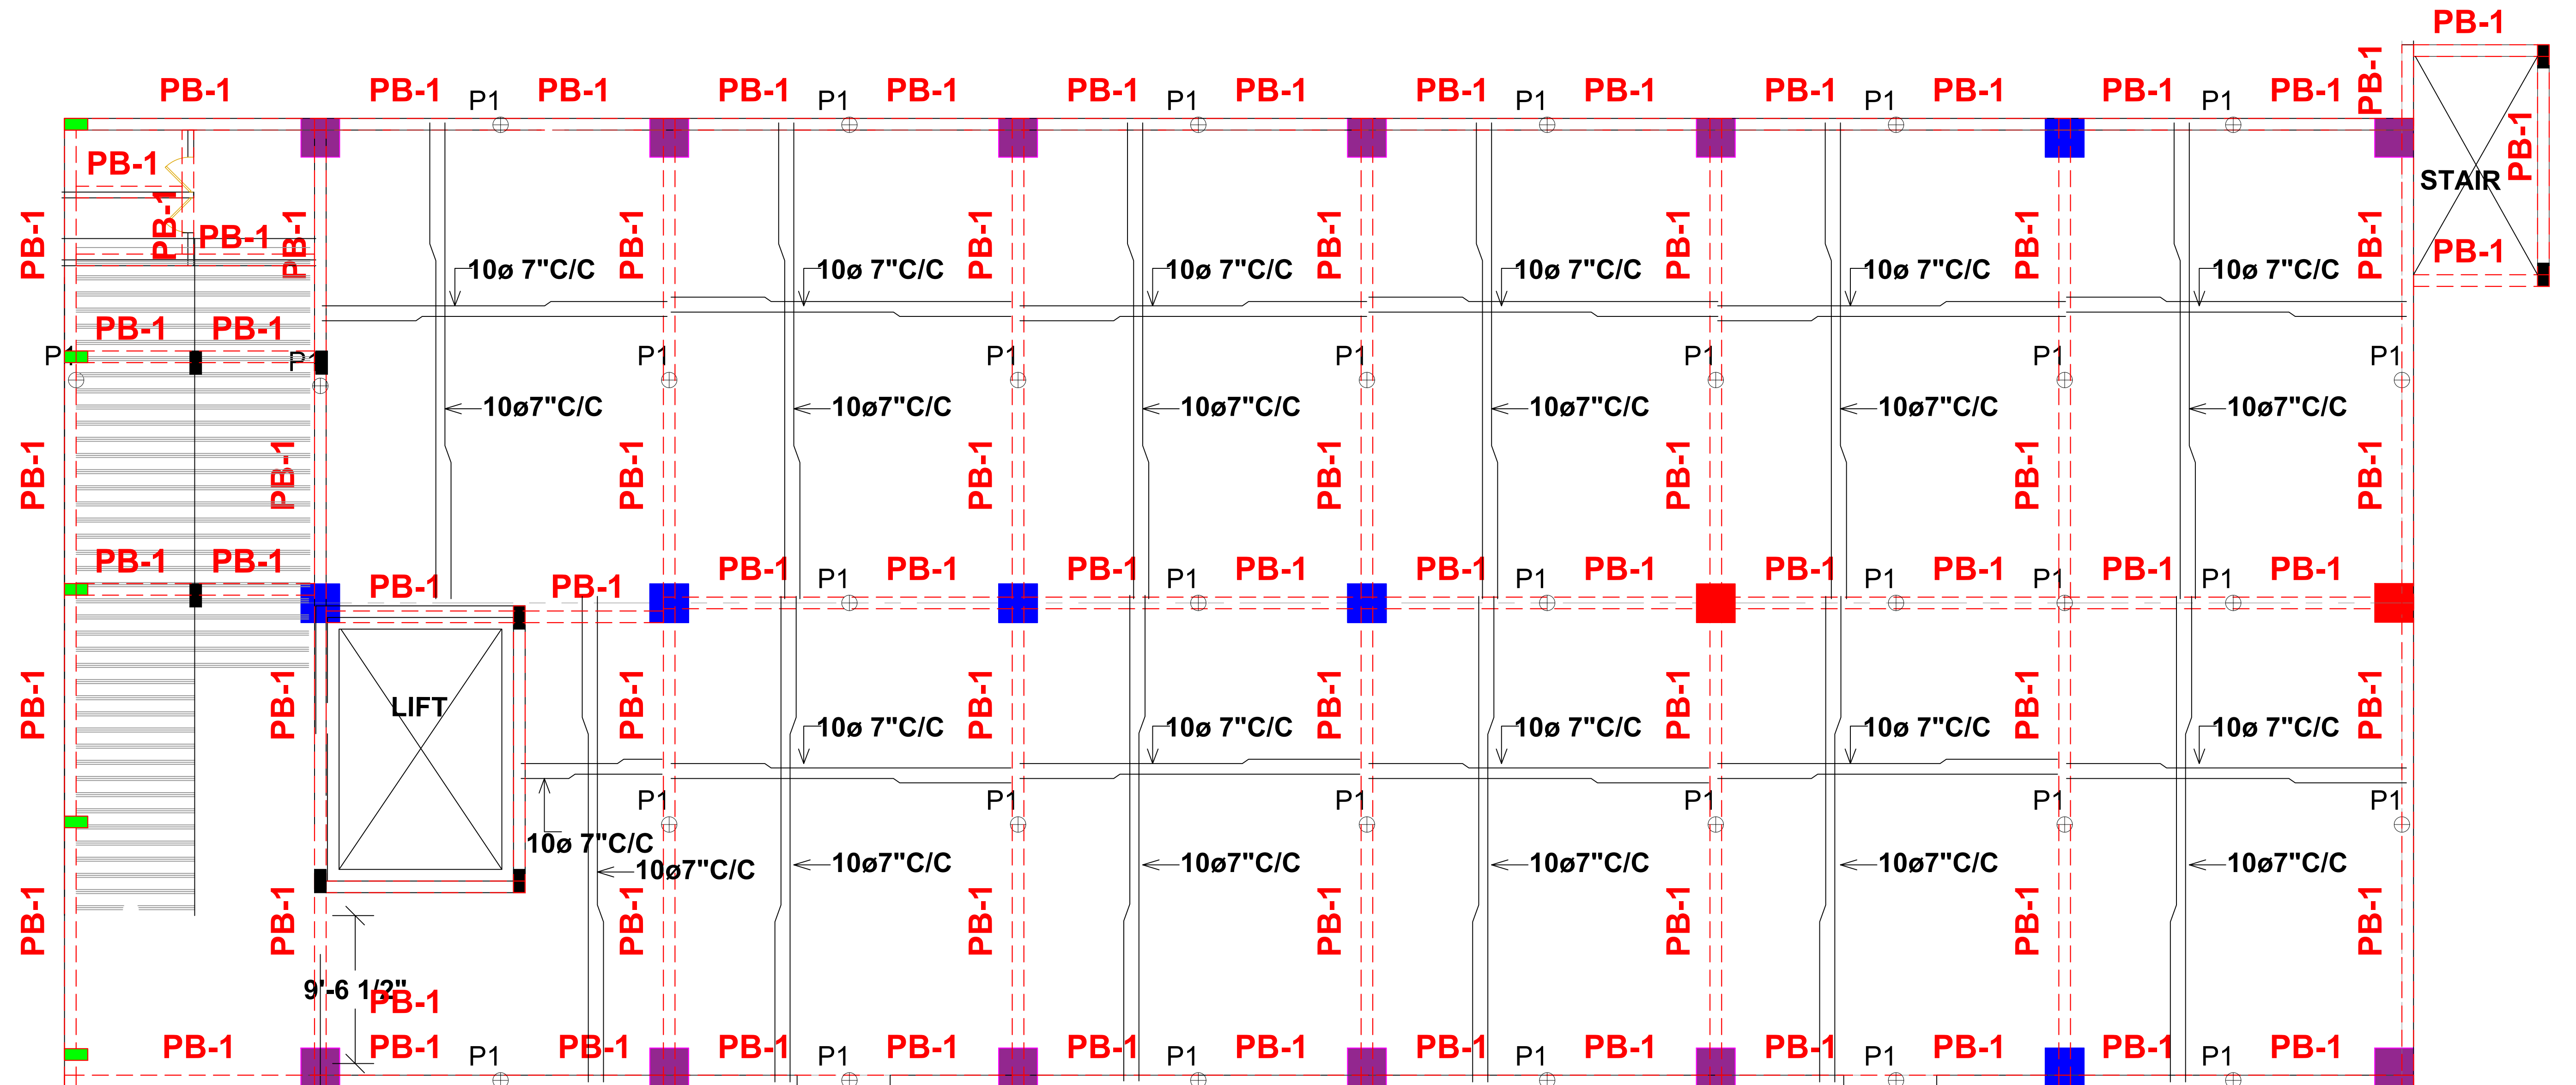

PROJECT NAME - MR. ANMOL WADHWA

DRAWING NAME - PLINTH BEAM DETAILS

- Only written dimension should be followed.
- All dimension should be checked by contractor and any discrepancy in them shall be brought to the notice of Architect before execution.
- Structure details (beam & column) taken here are as given by structural engineer.
- All dimensions are feet & inch.




DRAWN BY - ADITYA


CHECKED BY - DEVENDRA

DATE - 15 - 12 - 2022



DESIGN ZONE

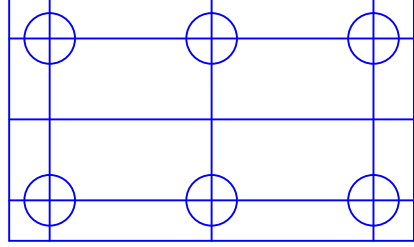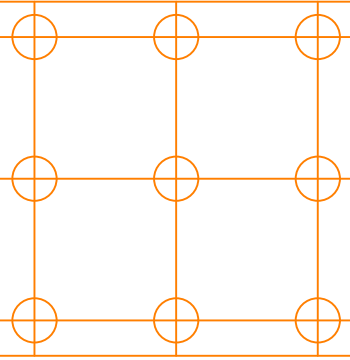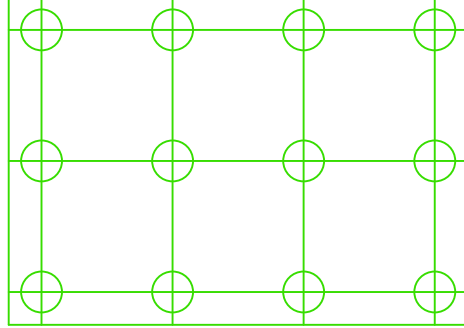PILE CAP.	PILE CAP. SIZE	PILE DEPTH BELOW CAP.	PILE GROUP
 PC1	10'0"X 6'0"X 3'0"	16'	6-15" DIA
 PC2	10'0"X 10'0"X 3'0"	16'	9-15" DIA
 PC3	14'0"X 10'0"X 3'0"	16'	12-15" DIA

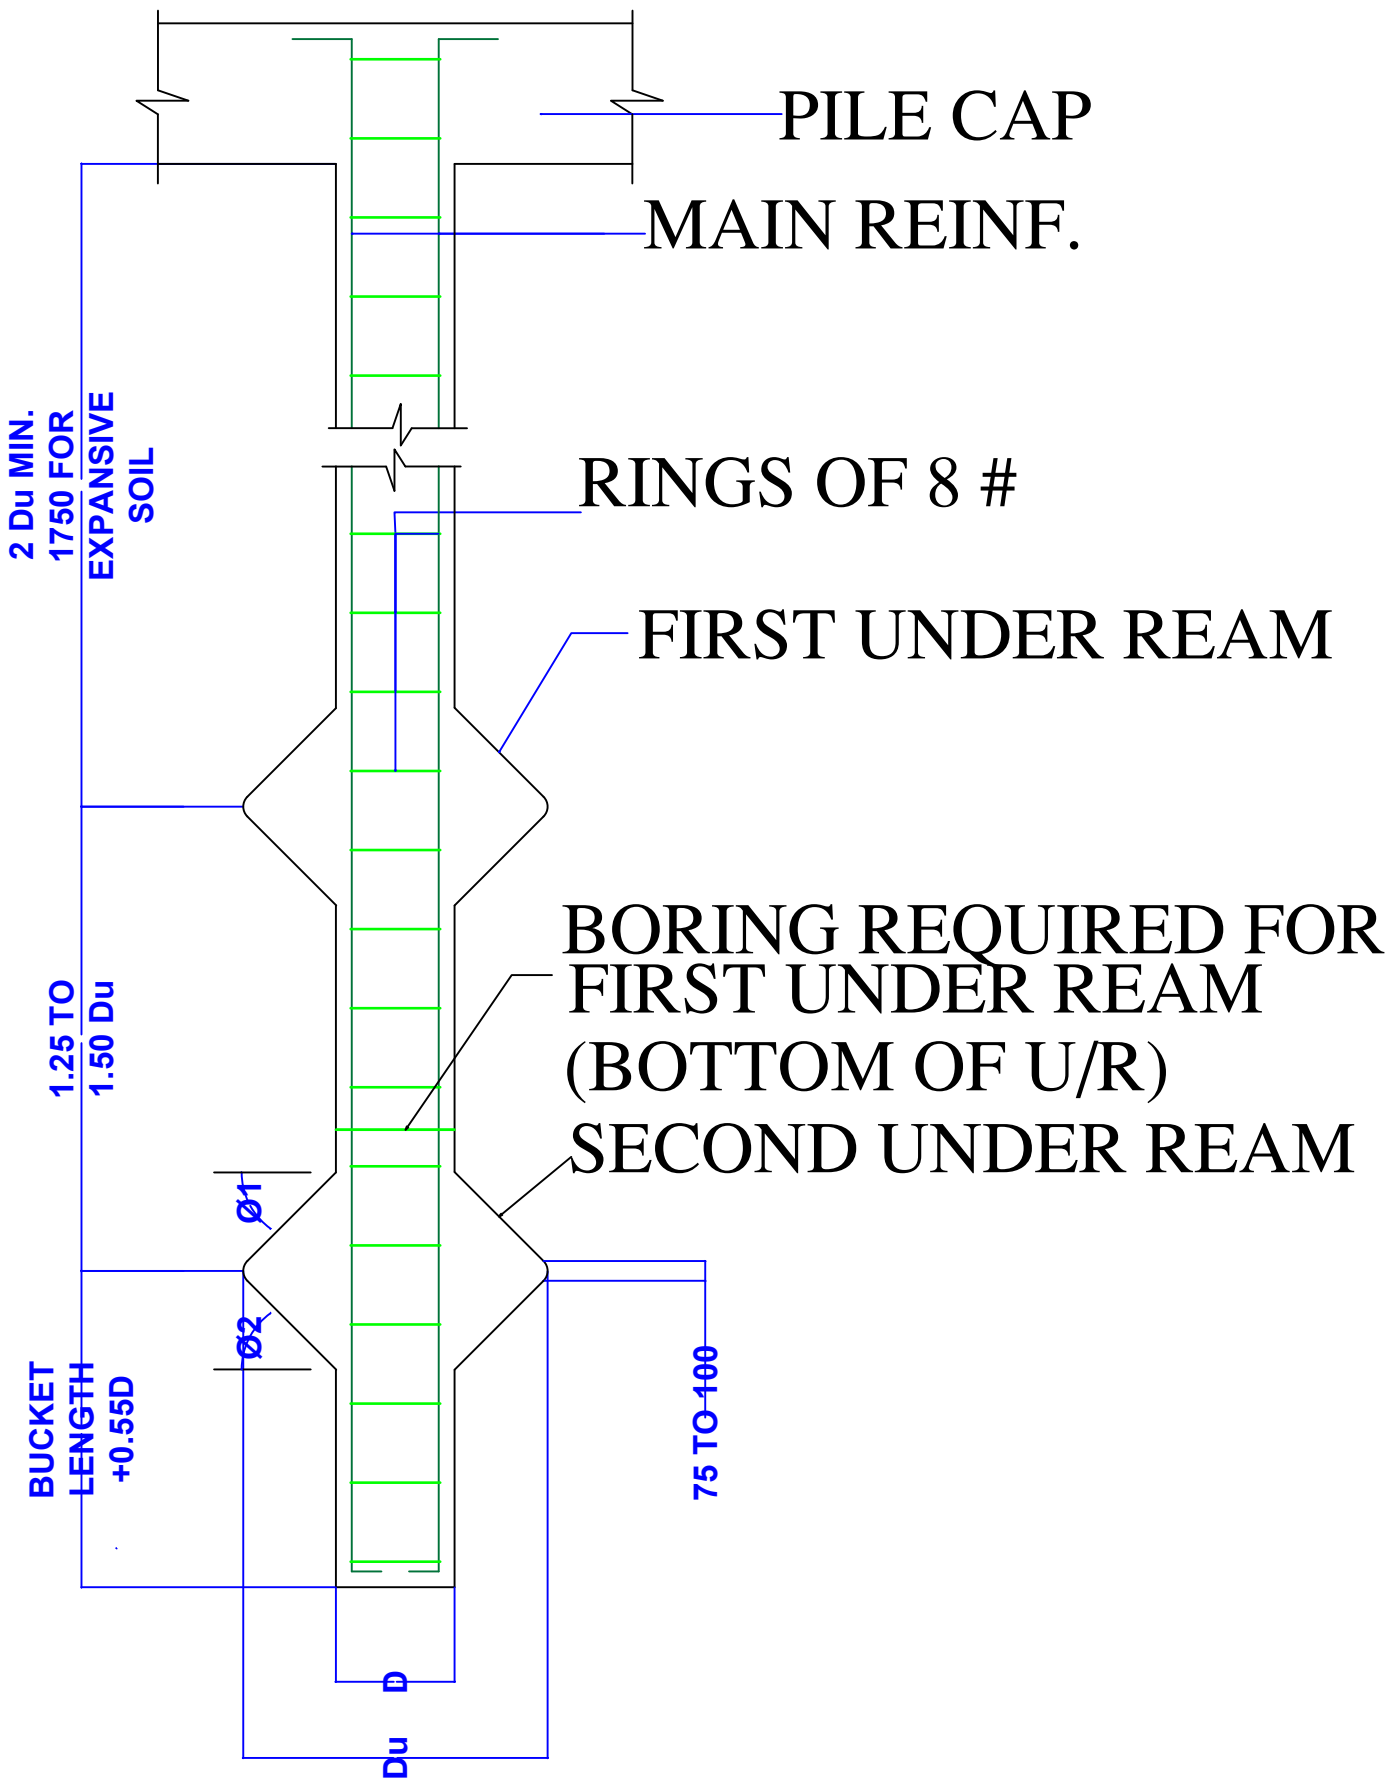

TYP. SKETCH OF DOUBLE
UNDER REAMED PILE.
(PILE-1)

PILE DEPTH FROM THE NATURAL GROUND LEVEL

TABLE SHOWING DETAILS OF PILE - (M-25) Fe- 500							
GROUP No.	NAME OF PILE	DIA OF PILE (D)(MM)	TYPE OF PILE	DIA OF UNDER REAM (Du)	MAIN REINFORCEMENT		SPACING OF 8 # CIRCULAR RINGS
					NOS. OF BARS	DIA # mm	
01	P1	300(12")	DOUBLE UNDER REAM	27"	5	12 #	@ 6" C/C
02	P2	375(15")	DOUBLE UNDER REAM	33"	7	12 #	@ 6" C/C

PROJECT NAME - MR. ANMOL WADHWA

DRAWING NAME - FOUNDATION DETAILS

- Only written dimension should be followed.
- All dimension should be checked by contractor and any discrepancy in them shall be brought to the notice of Architect before execution.
- Structure details (beam & column) taken here are as given by structural engineer.
- All dimensions are feet & inch.

DRAWN BY - ADITYA

 

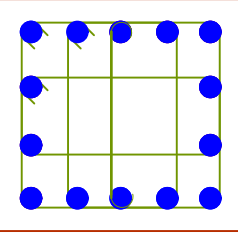
 
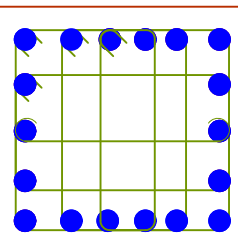
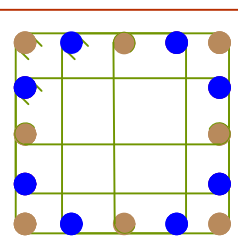
CHECKED BY - DEVENDRA





DATE - 11 - 11 - 2022



DESIGN ZONE

DETAILS OF COLUMN(M-25, Fe -500)

COLUMN GROUP	COLUMN NUMBER	COLUMN SIZE / COLUMN REINFORCEMENT	STIRRUPS	TIE DETAILS
C1	9" X 18"	 8 no. T20	8 # @ 5" C/C.	
C2	NOT APPLICABLE			
C3 (12 NO)	30" X 30"	 14 no. T25	8 # @ 8" C/C.	
C4 (6 NOS)	30" X 30"	 18 no. T25		
C5 (2 NOS)	30" X 30"	 8 no. T32 8 no. T25		

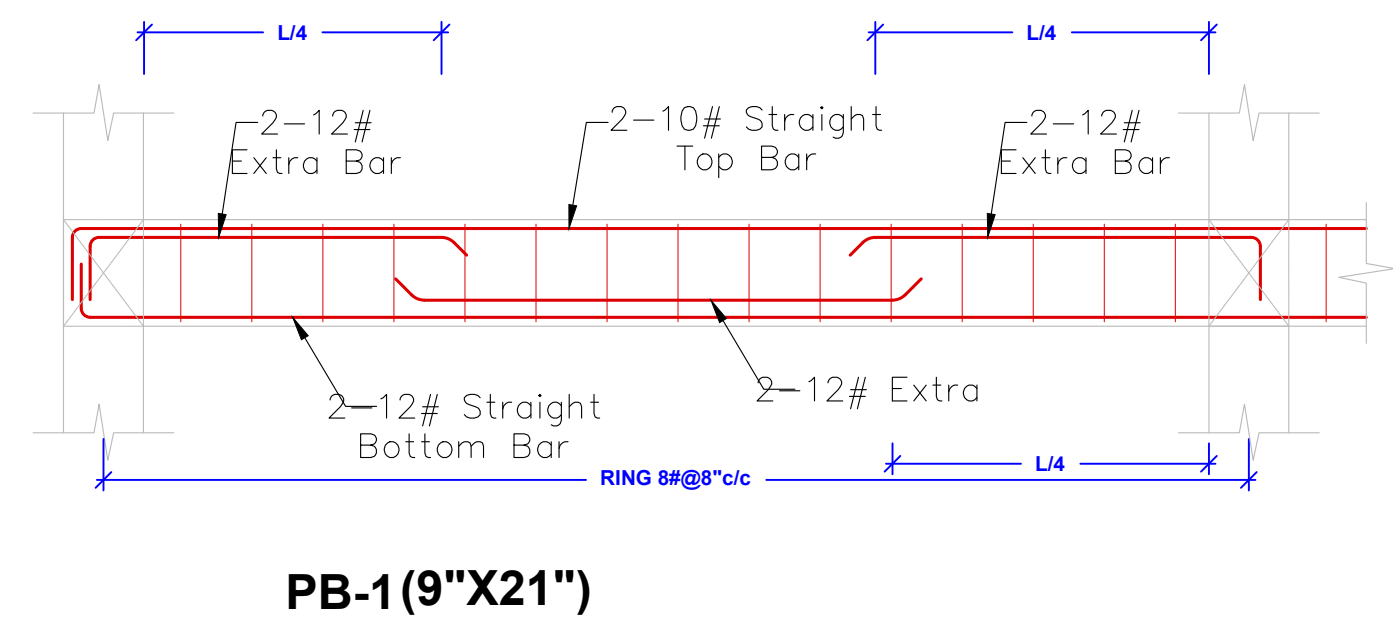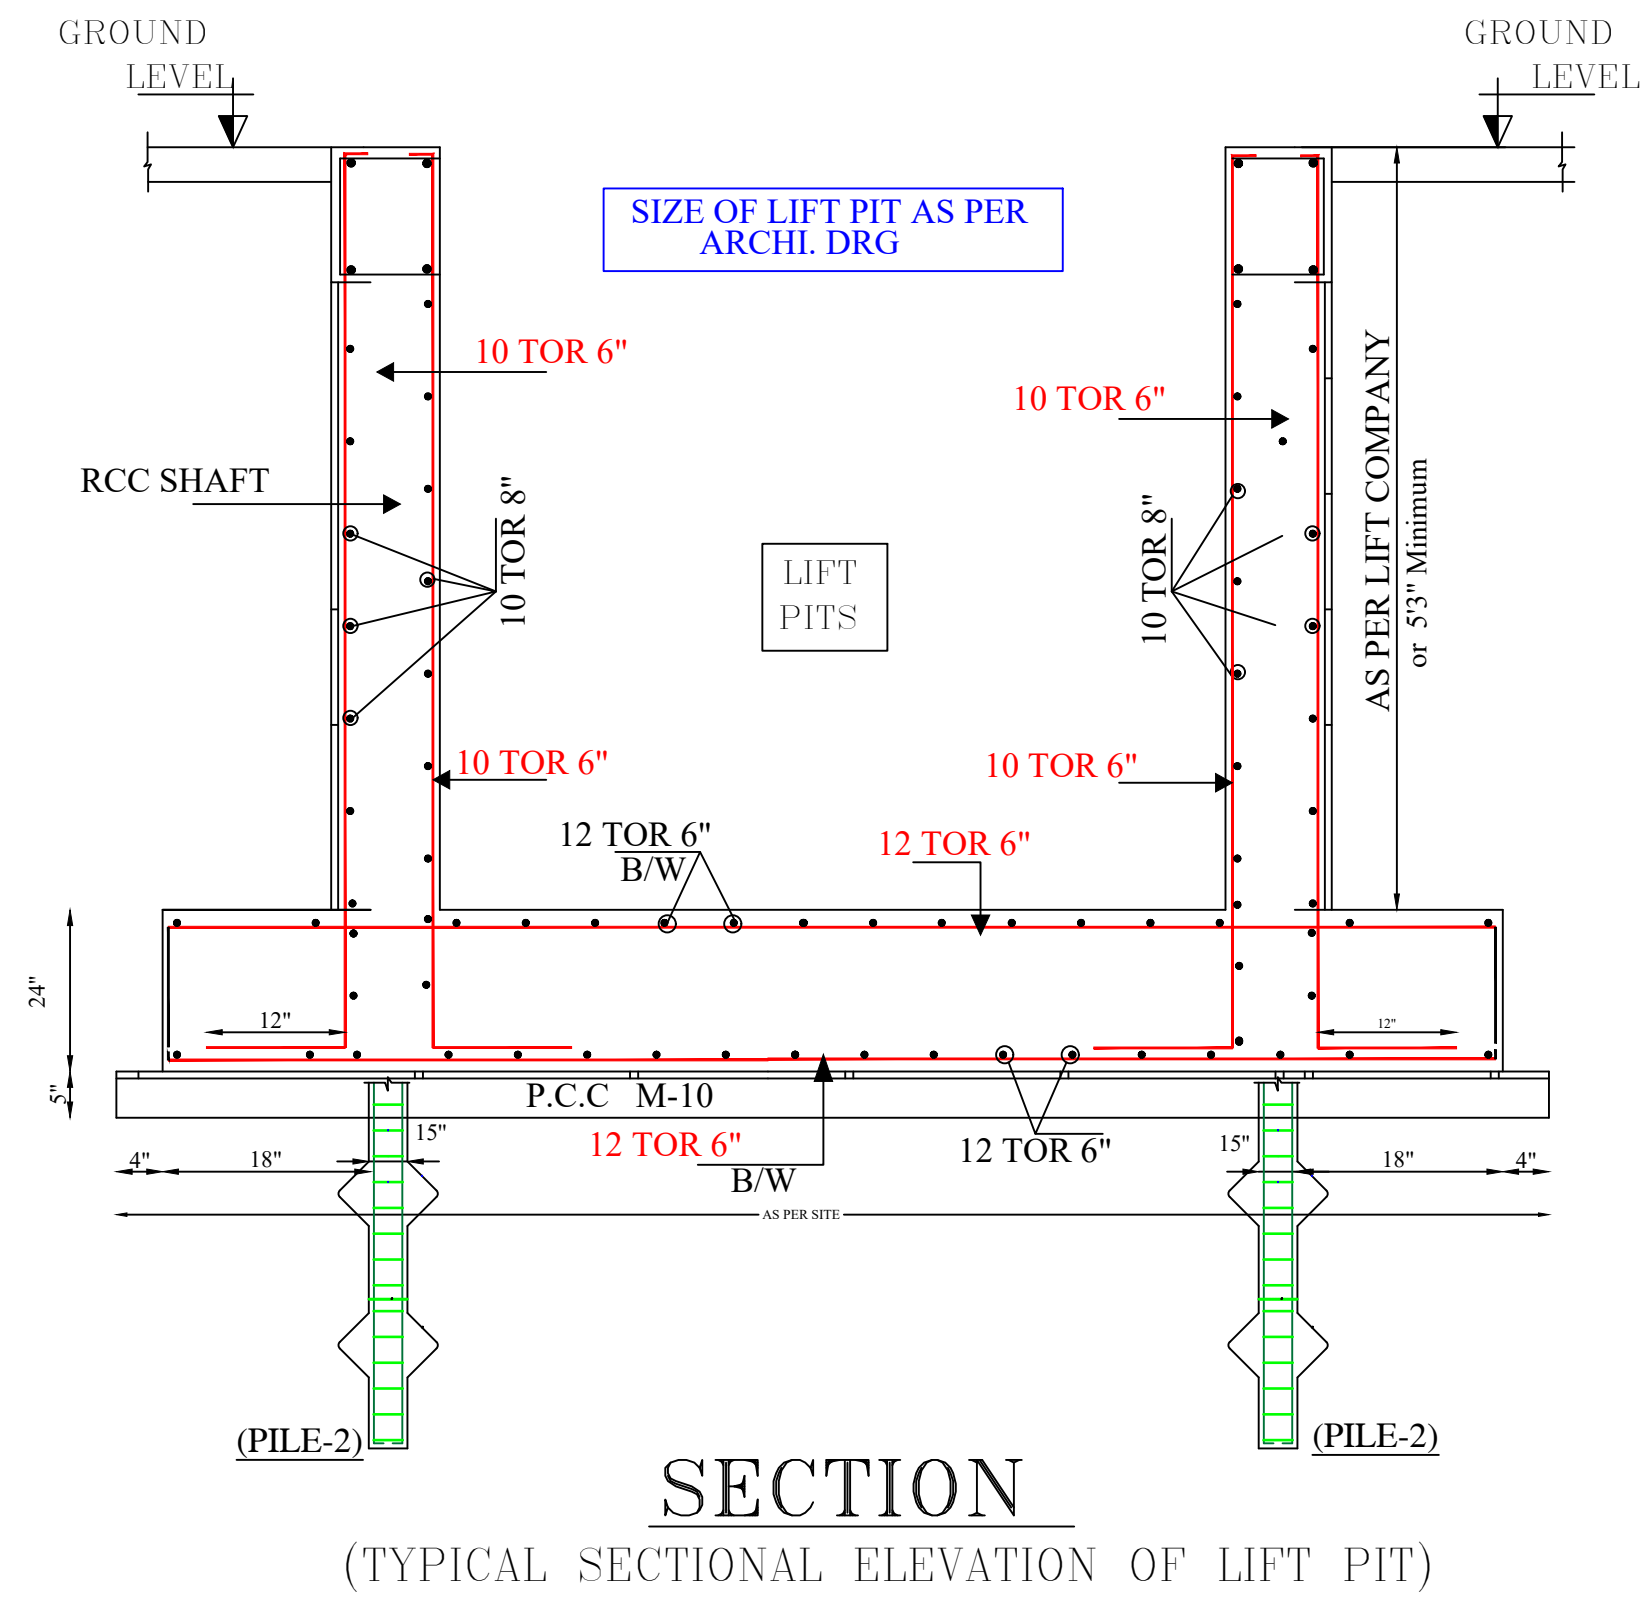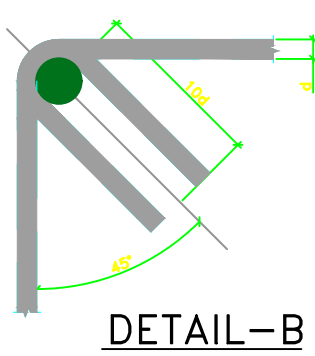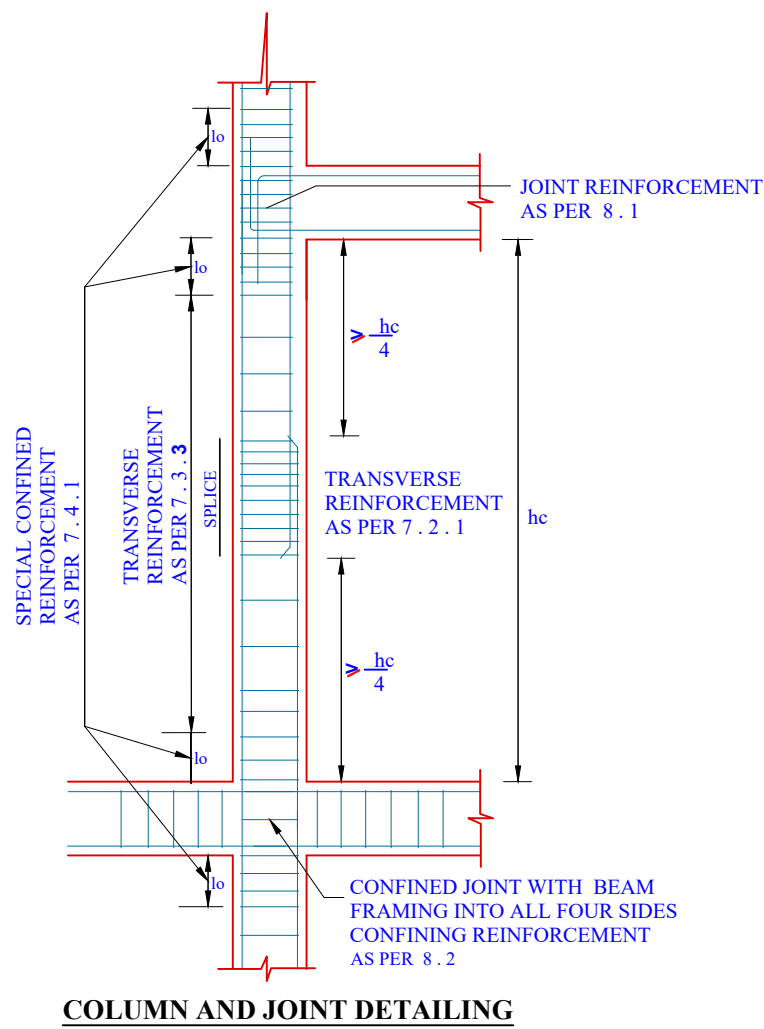

PROJECT NAME - MR. ANMOL WADHWA




DRAWING NAME - FOUNDATION DETAILS

- Only written dimension should be followed.
- All dimension should be checked by contractor and any discrepancy in them shall be brought to the notice of Architect before execution.
- Structure details (beam & column) taken here are as given by structural engineer.
- All dimensions are feet & inch.

DRAWN BY - ADITYA

CHECKED BY - DEVENDRA

DATE - 11 - 11 - 2022

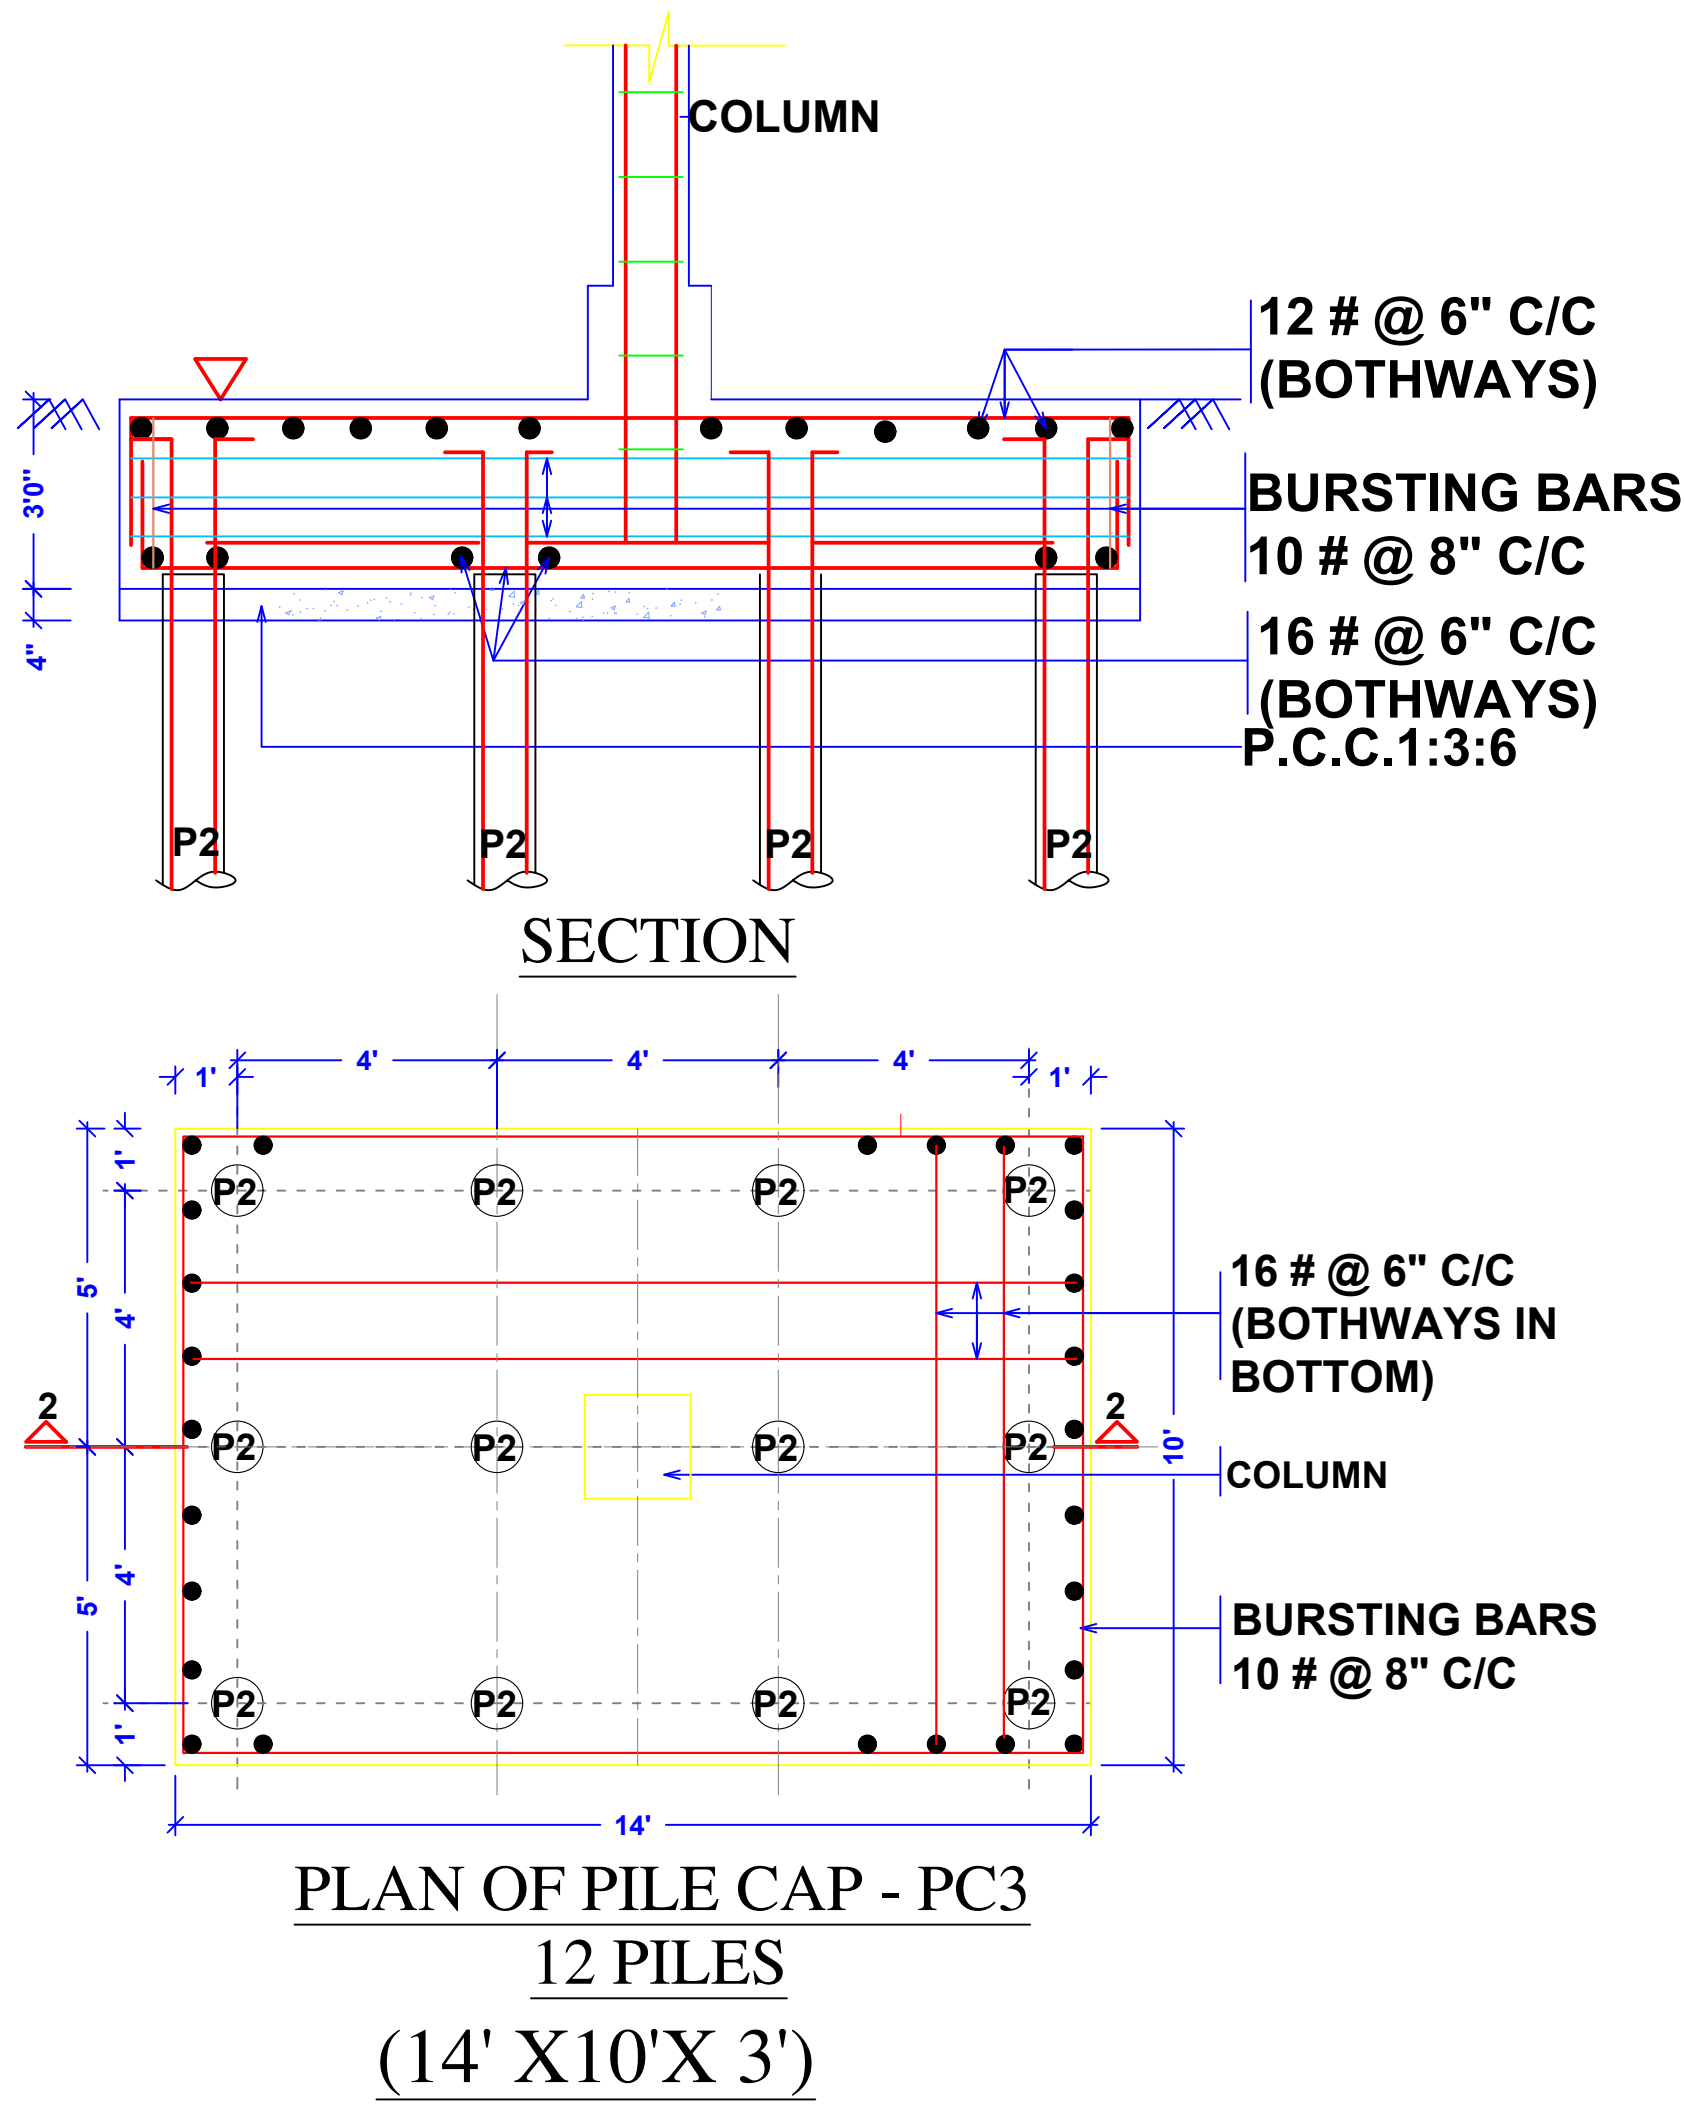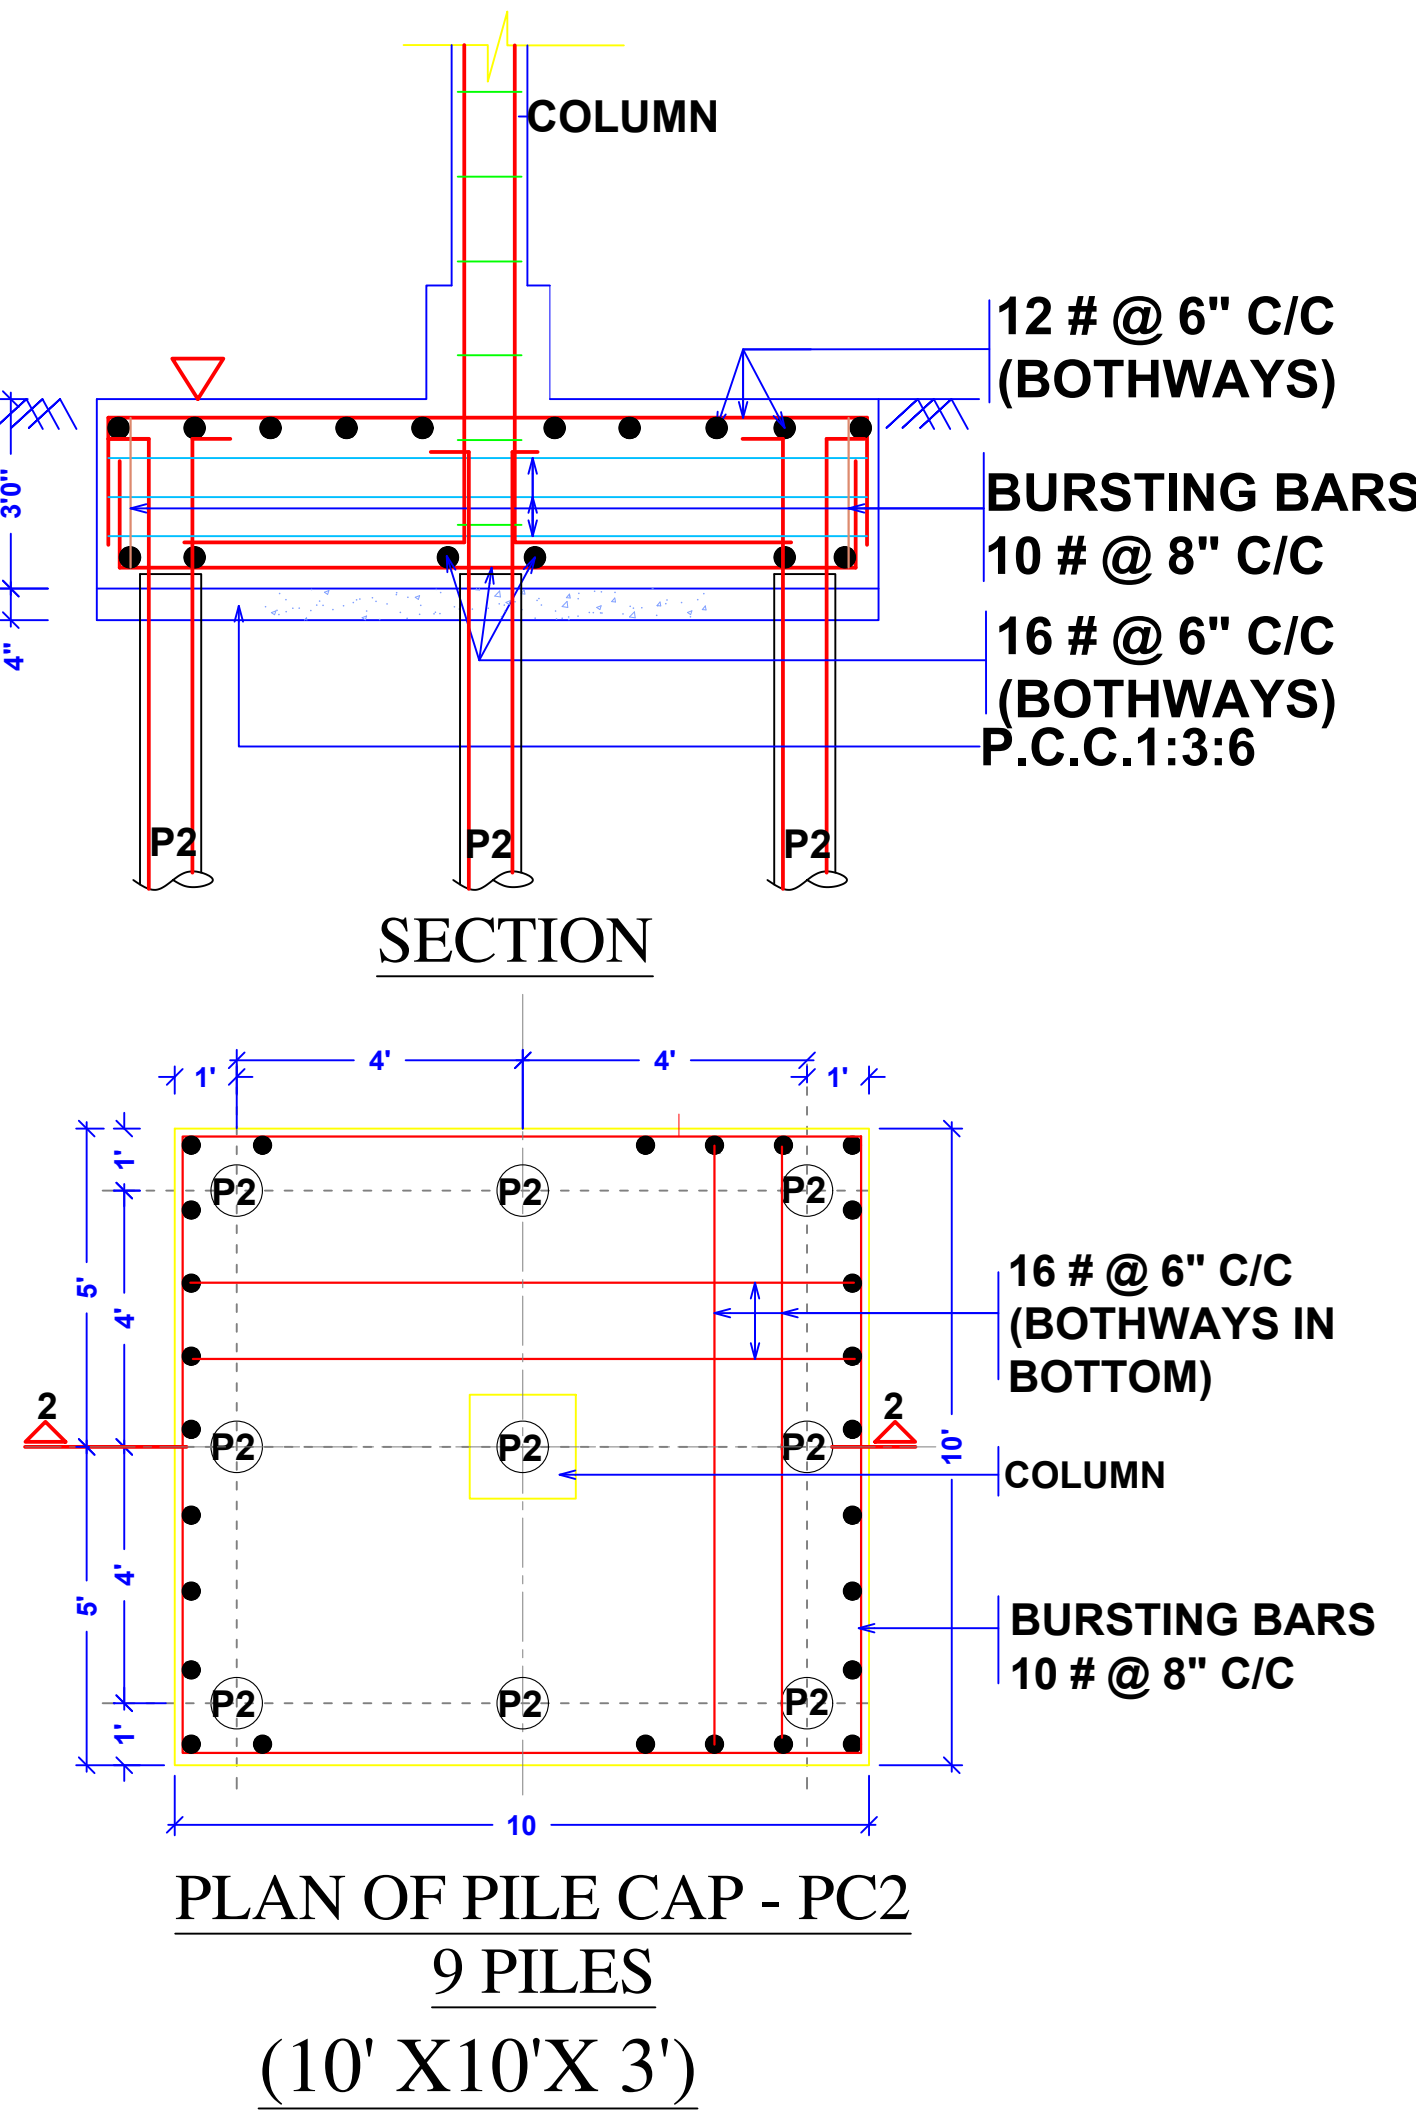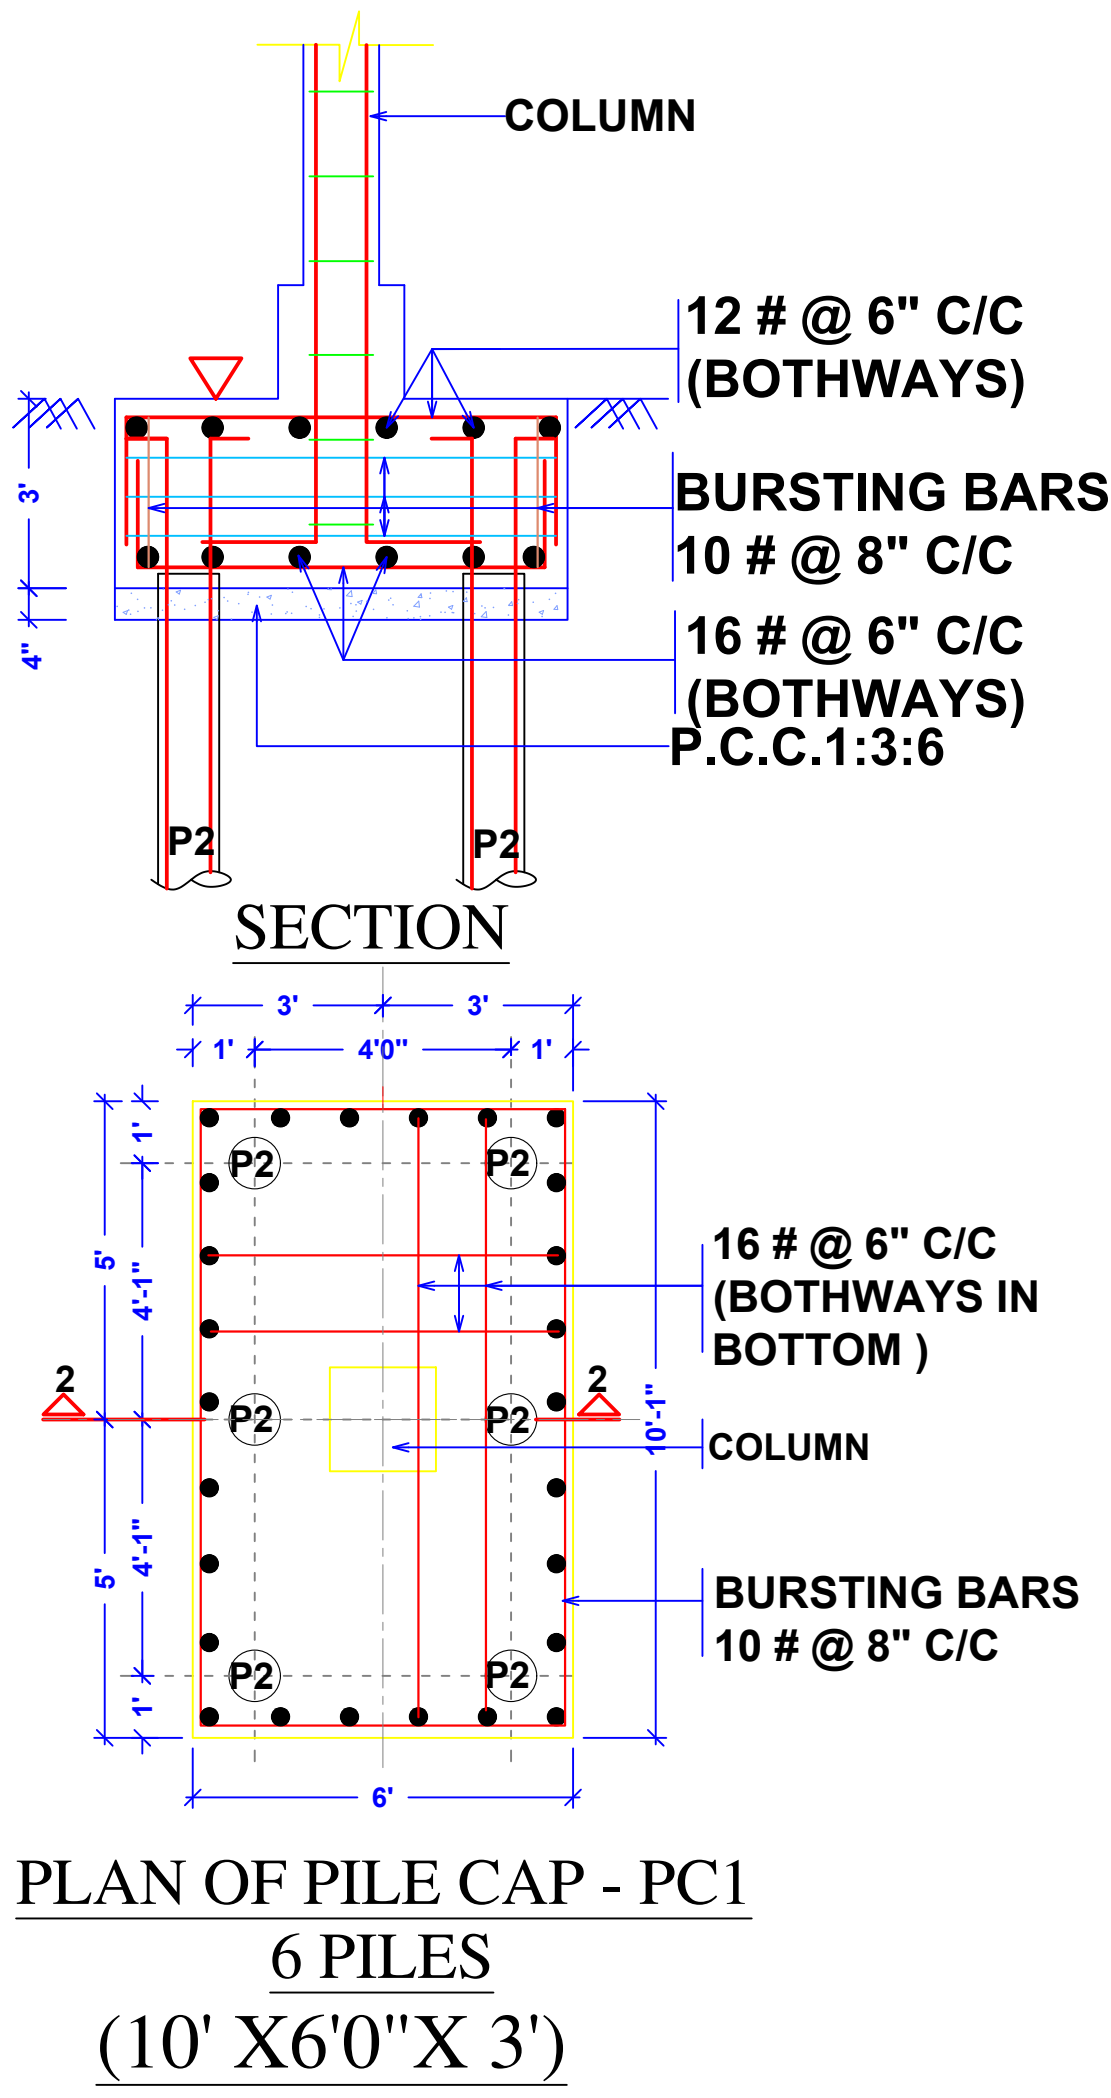

PROJECT NAME - MR. ANMOL WADHWA

DRAWING NAME - FOUNDATION DETAILS


- Only written dimension should be followed.
- All dimension should be checked by contractor and any discrepancy in them shall be brought to the notice of Architect before execution.
- Structure details (beam & column) taken here are as given by structural engineer.
- All dimensions are feet & inch.

DRAWN BY - ADITYA

CHECKED BY - DEVENDRA


DATE - 11 - 11 - 2022



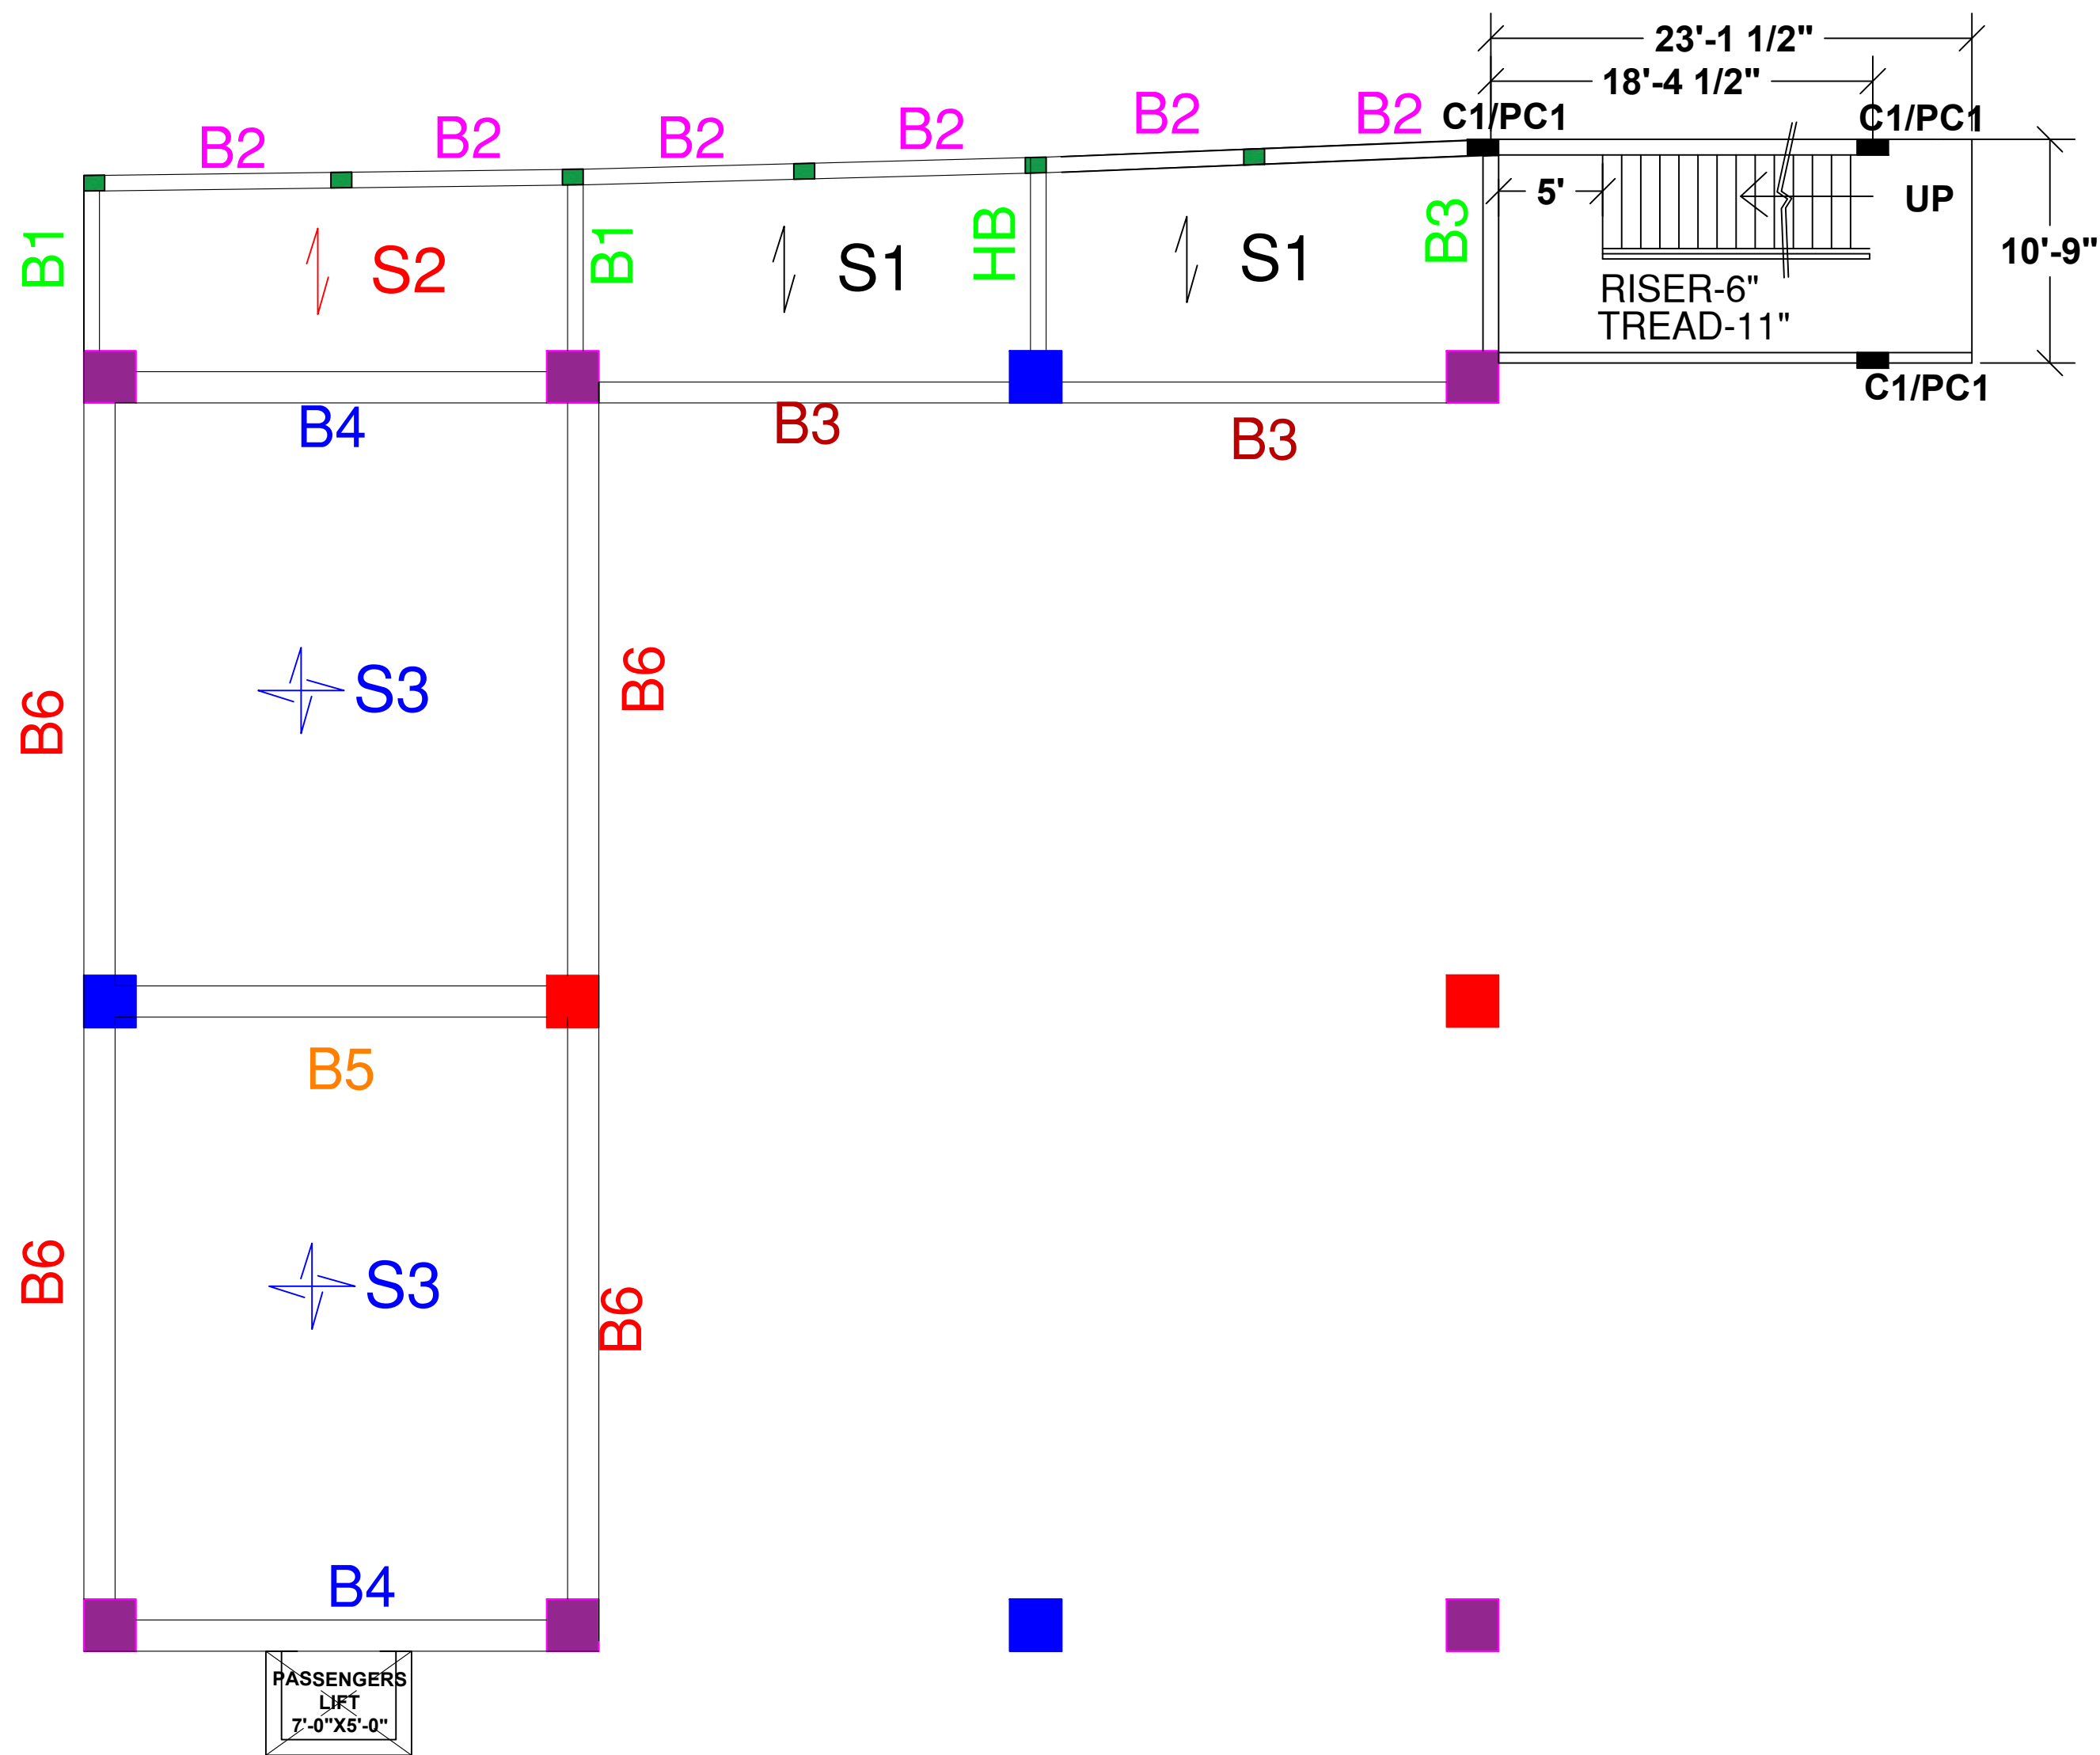


SLAB BEAM M -25(1:1:2)

BEAM NO.	SIZE (BxD) (OVERALL)	BOTTEM BARS		TOP BARS	EXTRA TOP UPTO L/3 AT SUPPORT	RING SPACING UPTO L/3 SUPPORT	RING SPACING AT MIDDLE PORTION	REMARK
		BOTTOM STRT. BARS	BOTM CUT AT MIDDLE 2/3 L*					
HB	12"x5"	3 x 16		3 x 16		8 @ 5" C/C	8 @ 7"C/C	
B1	9"x12"	2 x 16		2 x 16	2 x 16	8 @ 5" C/C	8 @ 7"C/C	
B2	9"x18"	3 x 16		3 x 16	2 x 16	8 @ 5" C/C	8 @ 7"C/C	
B3	12"x18"	3 x 20		3 x 20	2 x 16	8 @ 5" C/C	8 @ 7"C/C	INVERTED
B4	18"x24"	4 x 20		4 x 20	2 x 20	10 @ 5" C/C	10 @ 7"C/C	
B5	18"x24"	4 x 25		3 x 25	2 x 25	10 @ 5" C/C	10 @ 7"C/C	
B6	18"x24"	6 x 25		4 x 25	2 x 25	10 @ 5" C/C	10 @ 7"C/C	INVERTED

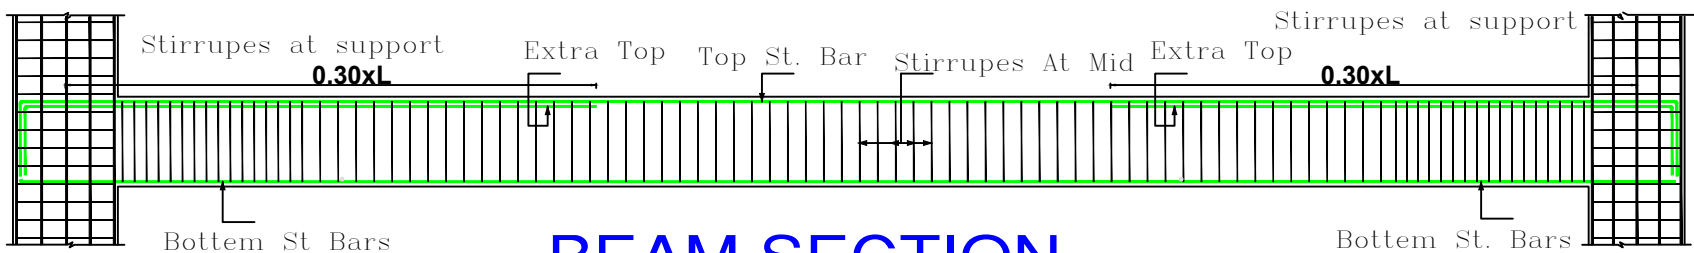

BEAM SECTION

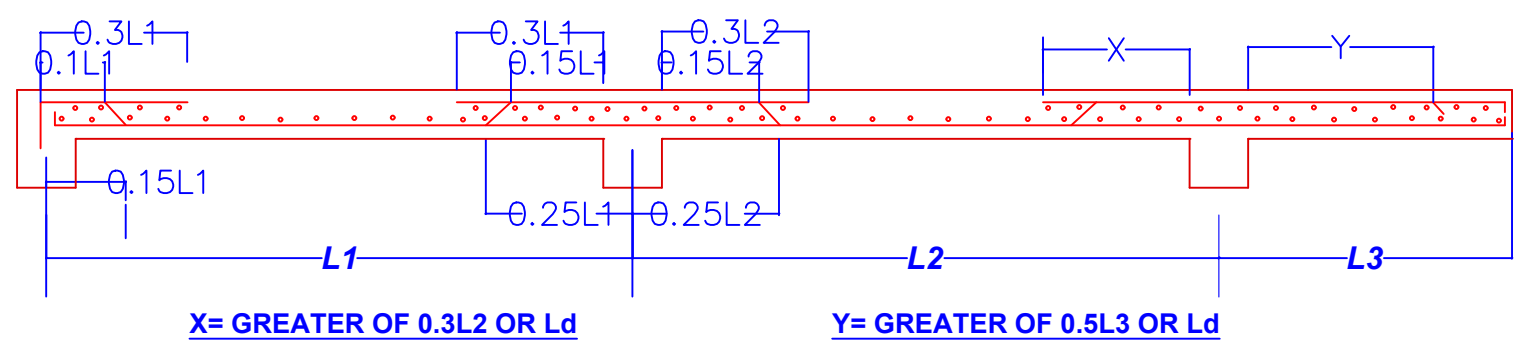

TYPICAL SKETCH OF SLAB

SCHEDULE OF SLAB:-

SLAB	THICK	MAIN SPAN			OTHER SPAN			REMARK	SLAB
		MAIN REINF.	EXTRA TOP	BENT @	MAIN REINF.	EXTRA TOP	BENT @		
S1	5"	10 # @ 6" C/C	-----	L/5,L/5	10 # @ 8" C/C			ONE WAY SLAB	S1
S2	5"	12 # @ 6" C/C	-----	L/5,L/5	10 # @ 8" C/C			ONE WAY SLAB	S2
S3	10"	12 # @ 5" C/C	12 # @ 10" C/C	L/5,L/5	12 # @ 6" C/C	12 # @ 12" C/C	L/5,L/5	TWO WAY SLAB	S2

PROJECT NAME - MR. ANMOL WADHWA

DRAWING NAME - PLINTH BEAM DETAILS

- Only written dimension should be followed.
- All dimension should be checked by contractor and any discrepancy in them shall be brought to the notice of Archifect before execution.
- Structure details (beam & column) taken here are as given by structural engineer.
- All dimensions are feet & inch.


DRAWN BY - ADITYA


CHECKED BY - DEVENDRA

DATE - 07 - 01 - 2023




DESIGN ZONE

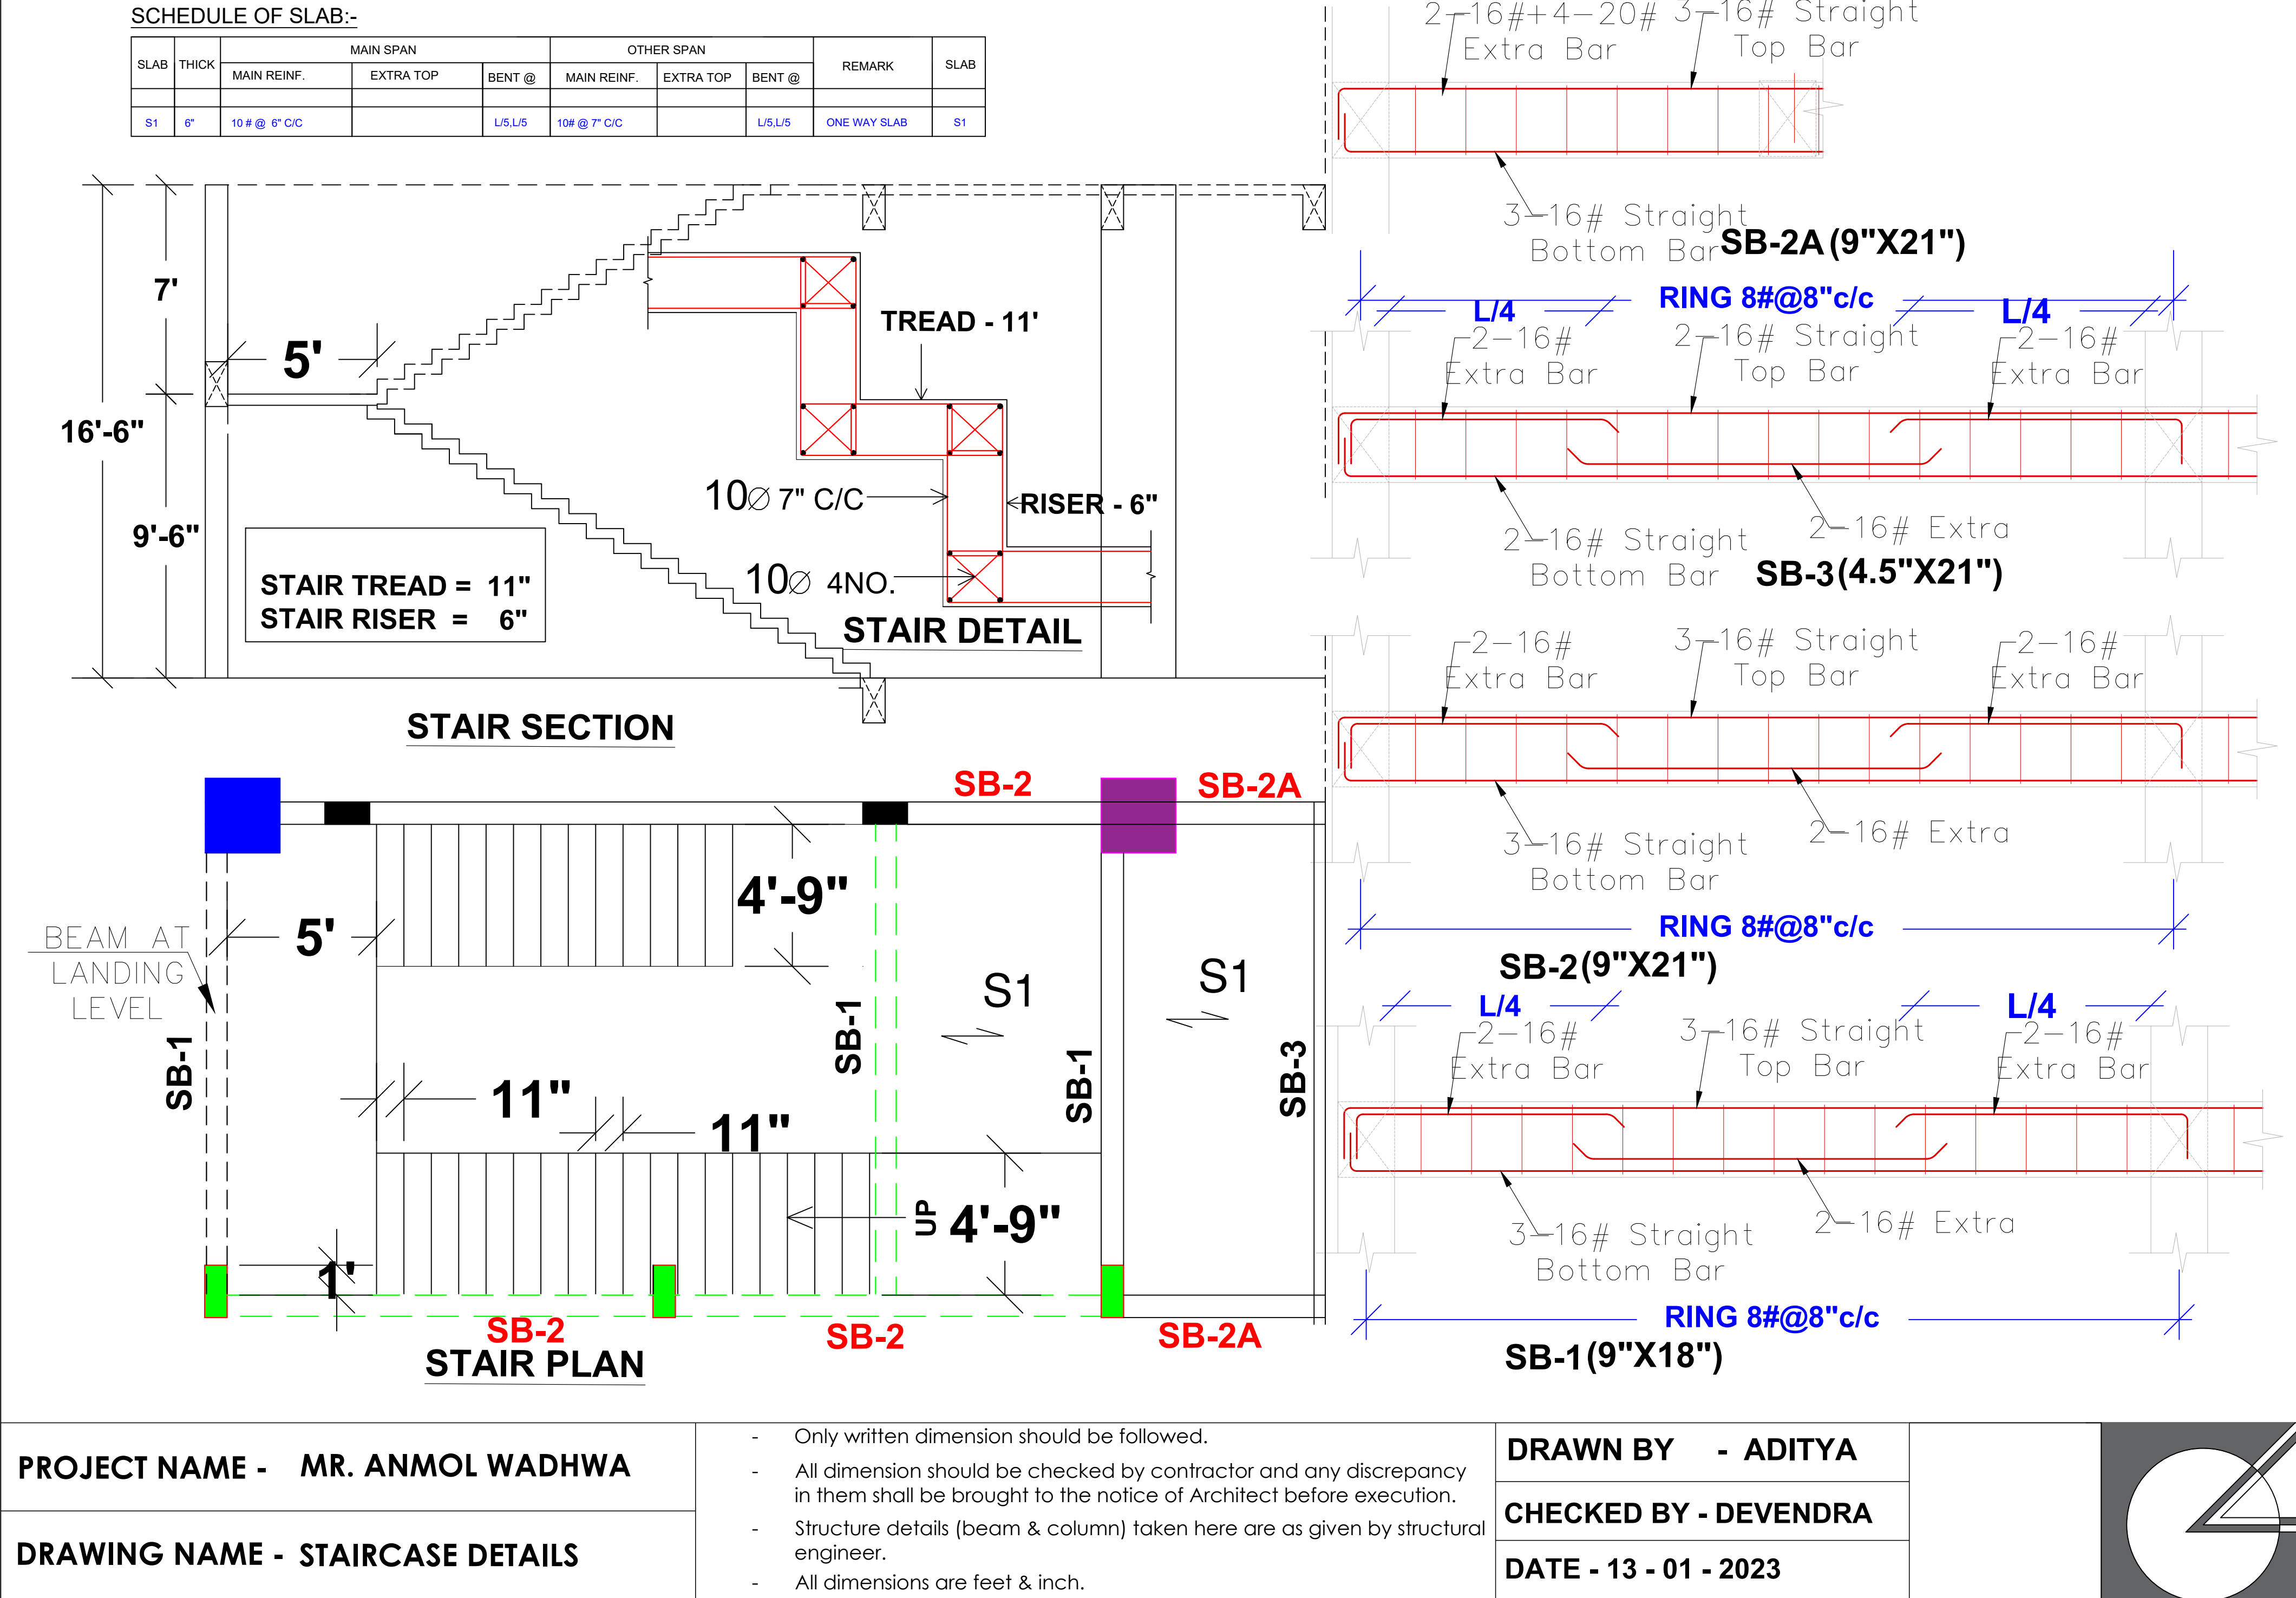

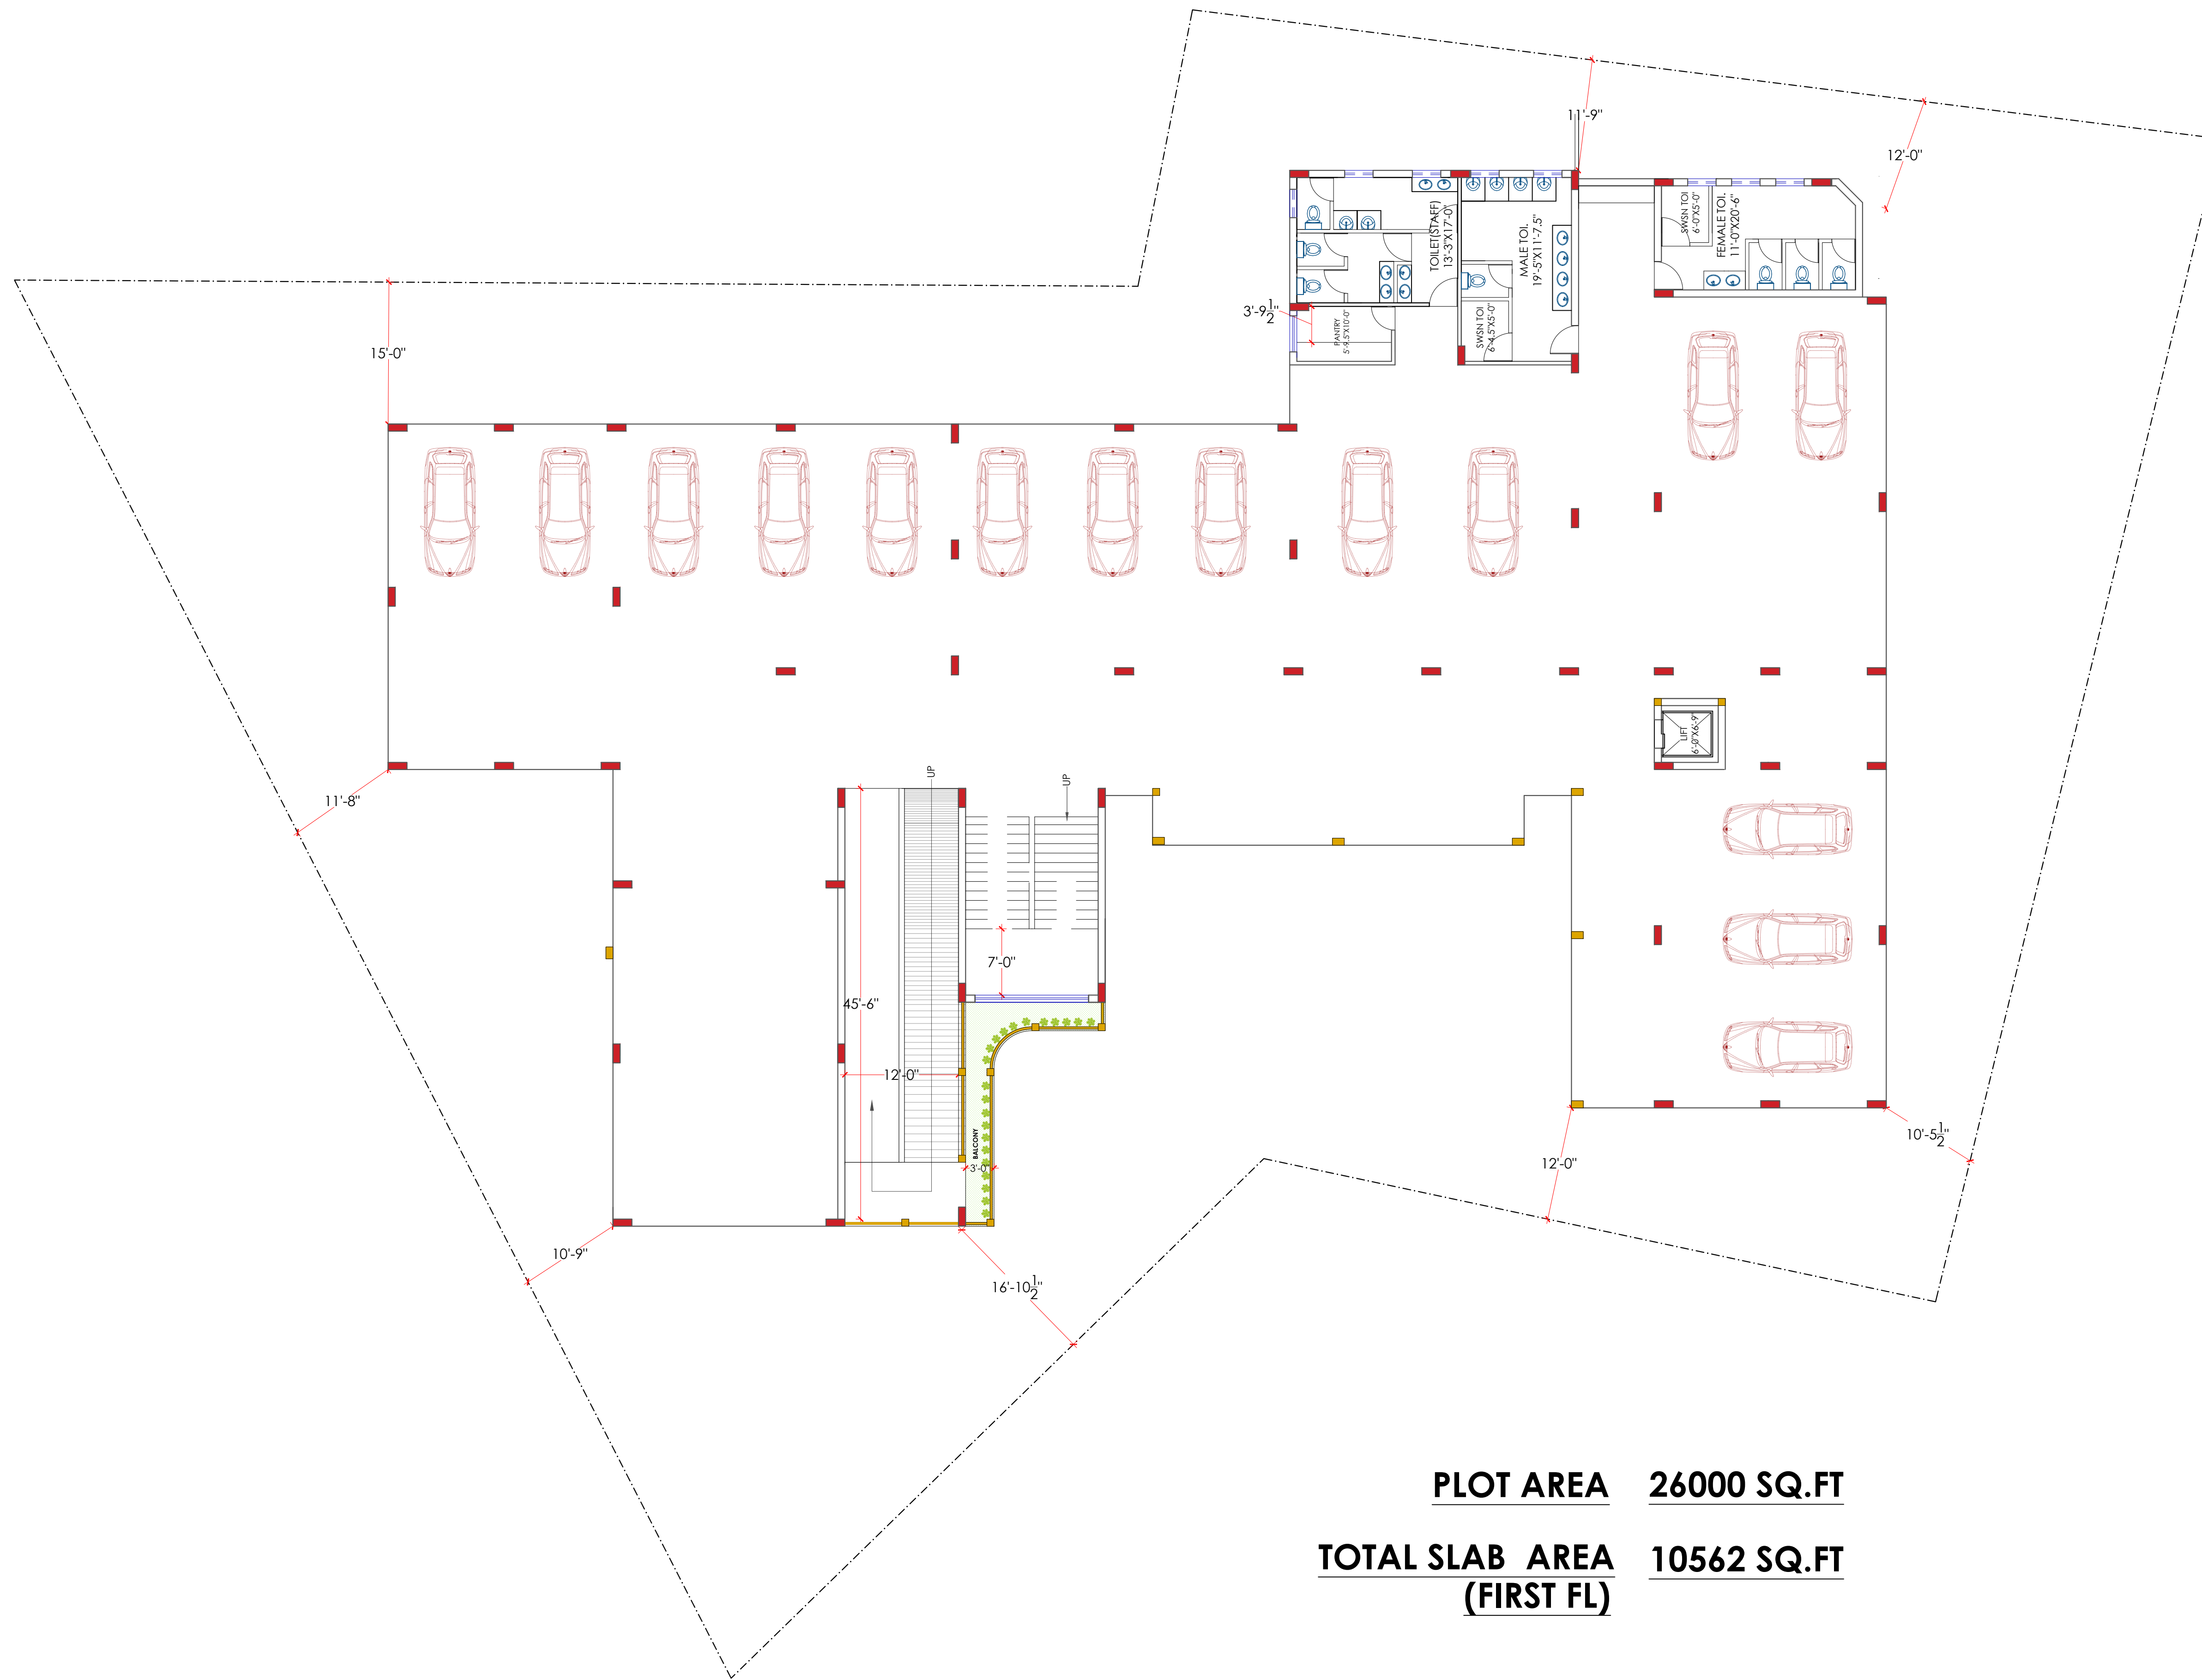

PLOT AREA **26000 SQ.FT**
TOTAL SLAB AREA **10562 SQ.FT**
(FIRST FL)

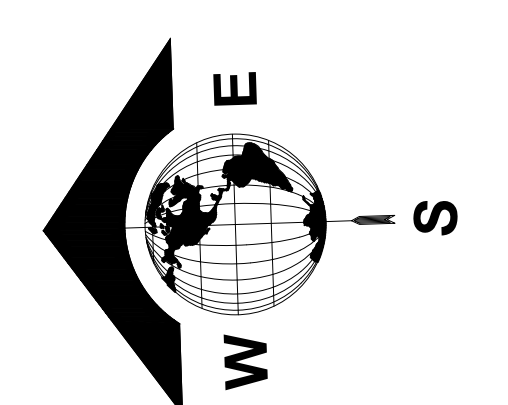

PROJECT NAME - GS COLLEGE

DRAWING NAME - PROPOSED FLOOR PLANS GROUND FL.



- Only written dimension should be followed.
- All dimension should be checked by contractor and any discrepancy in them shall be brought to the notice of Architect before execution.
- Structure details (beam & column) taken here are as given by structural engineer.
- All dimensions are feet & inch.

DRAWN BY –ADITYA

CHECKED BY –DEVENDRA

DATE –09–02–2023



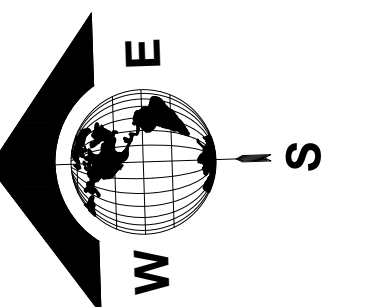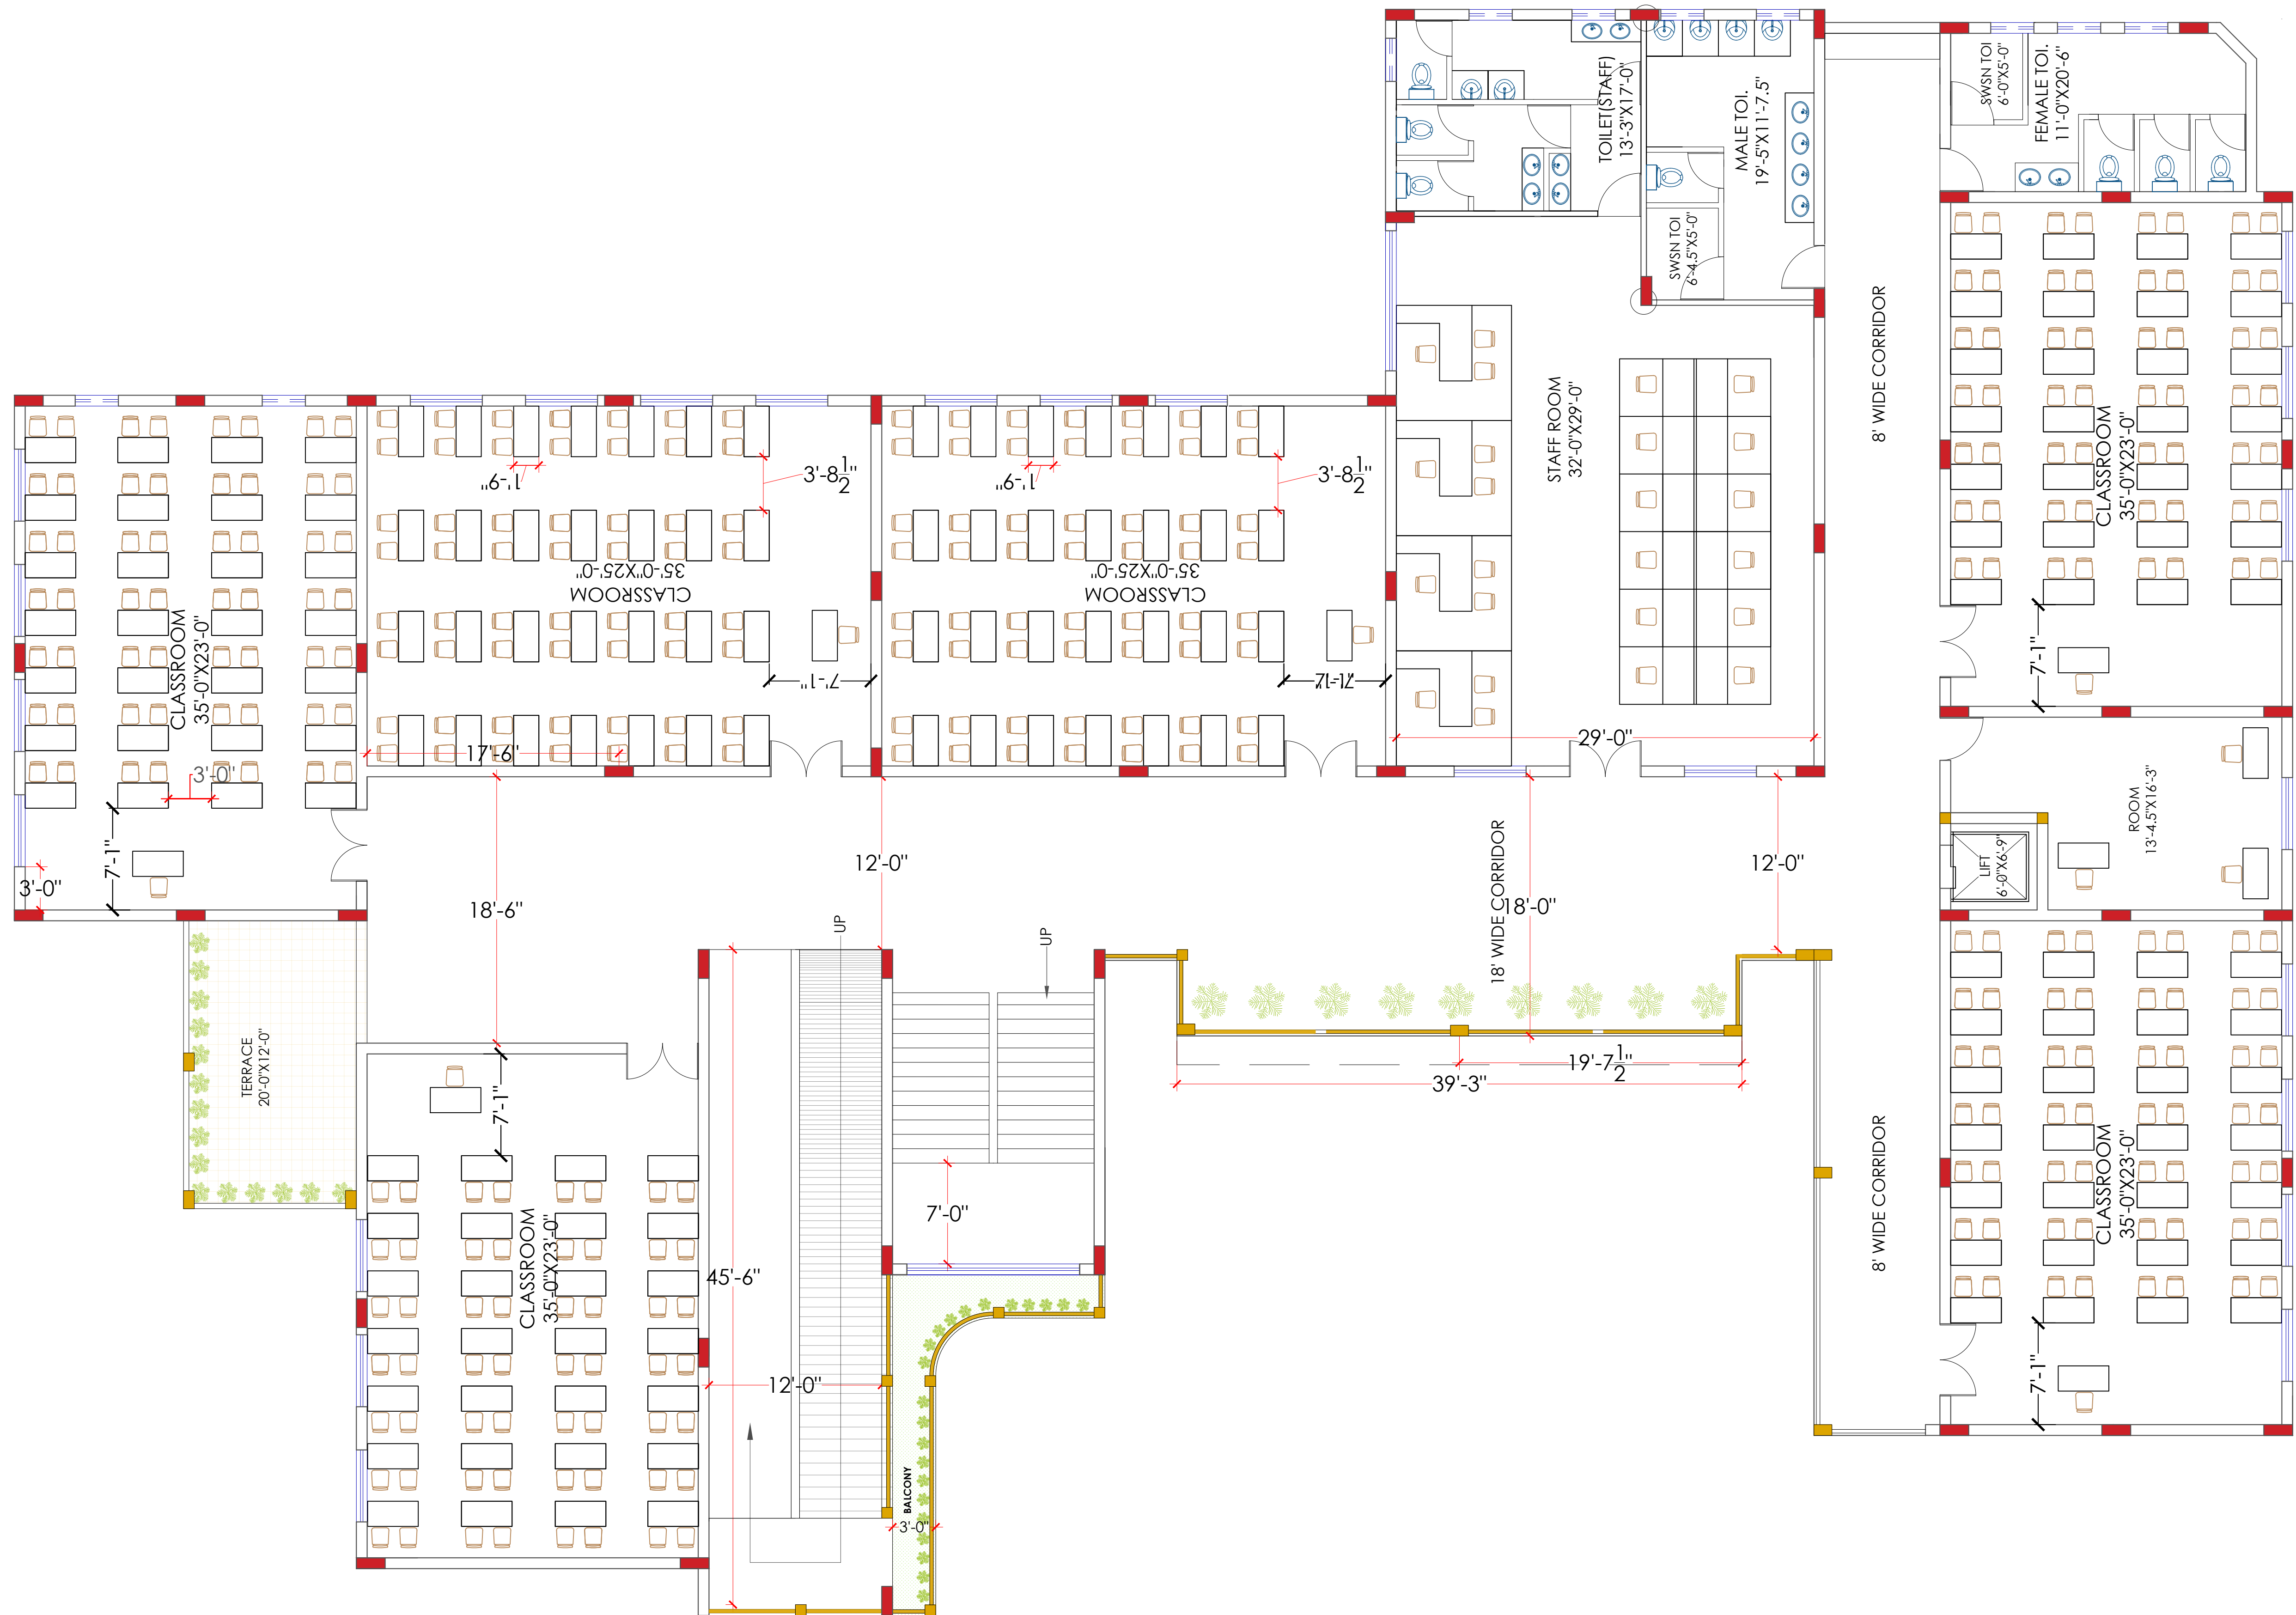

PROJECT NAME -MR. ANURAG WADHWA

DRAWING NAME - PROPOSED FLOOR PLANS - FIRST FL.

- Only written dimension should be followed.
- All dimension should be checked by contractor and any discrepancy in them shall be brought to the notice of Architect before execution.
- Structure details (beam & column) taken here are as given by structural engineer.
- All dimensions are feet & inch.


DRAWN BY –ADITYA

CHECKED BY –DEVENDRA

DATE –09–02–2023



DESIGN ZONE

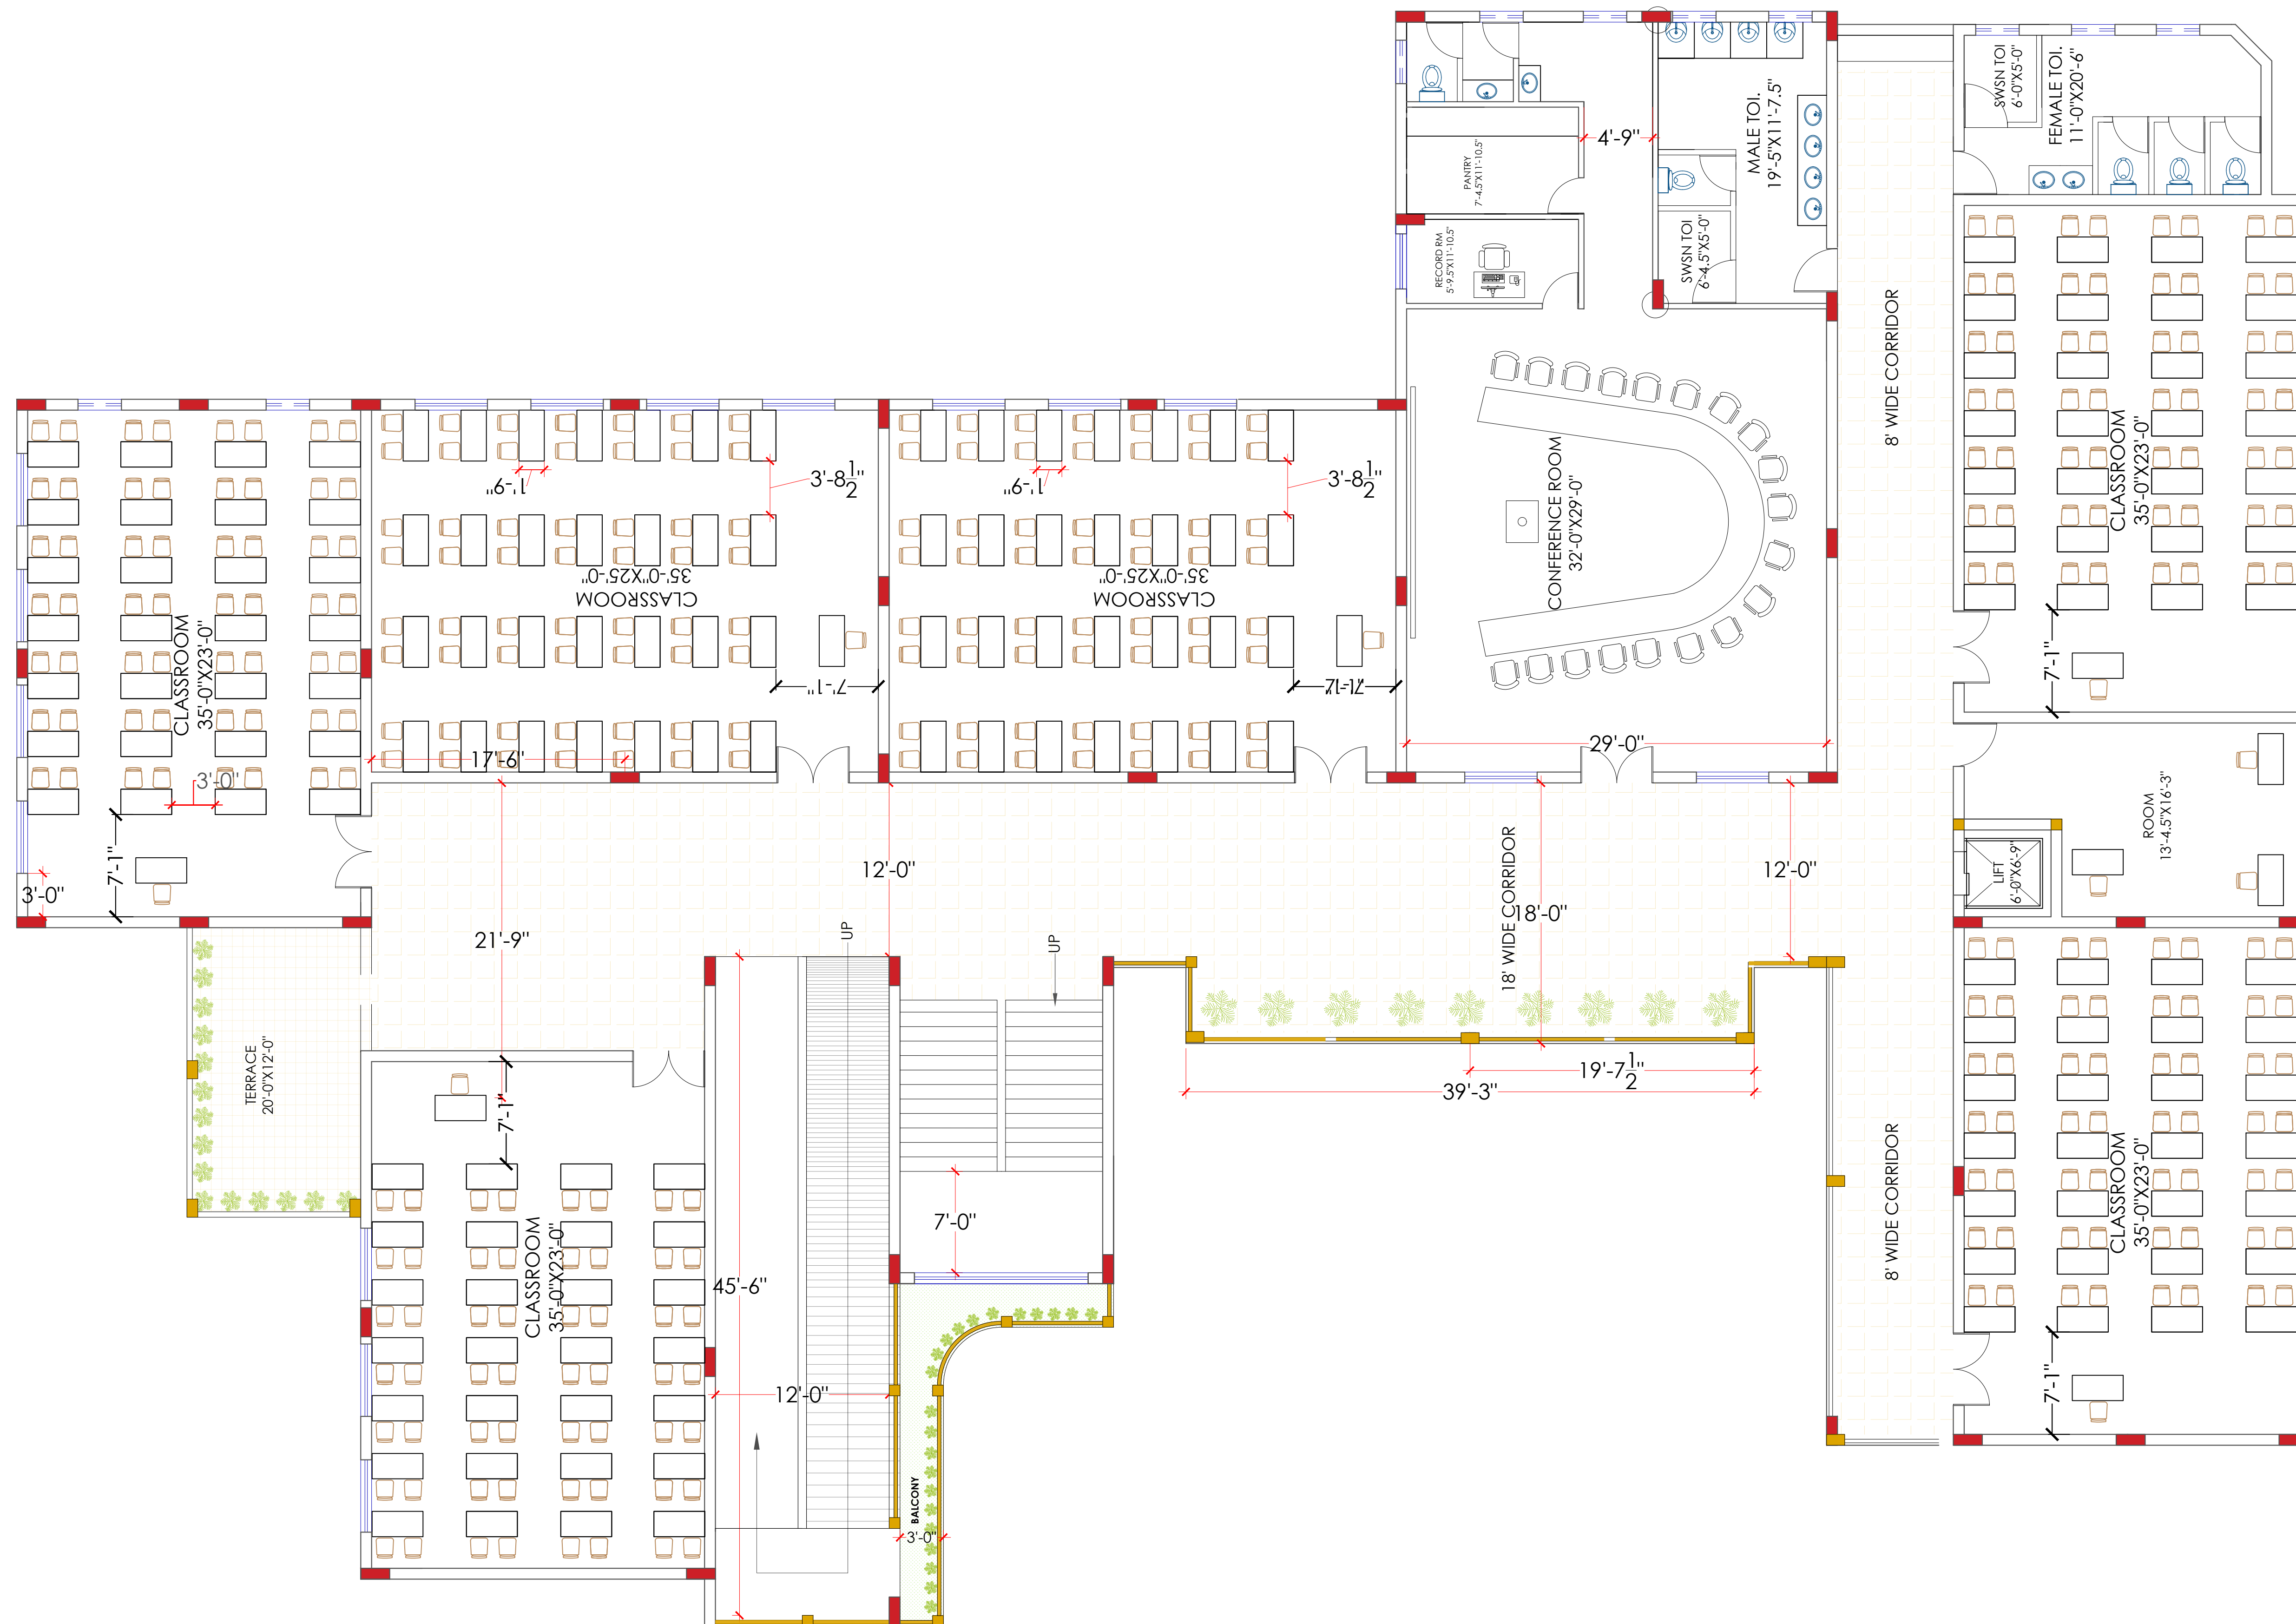

PROJECT NAME -MR. ANURAG WADHWA


DRAWING NAME - PROPOSED FLOOR PLANS - SECOND FL.


- Only written dimension should be followed.
- All dimension should be checked by contractor and any discrepancy in them shall be brought to the notice of Architect before execution.
- Structure details (beam & column) taken here are as given by structural engineer.
- All dimensions are feet & inch.

DRAWN BY –ADITYA

CHECKED BY –DEVENDRA

DATE –09–02–2023

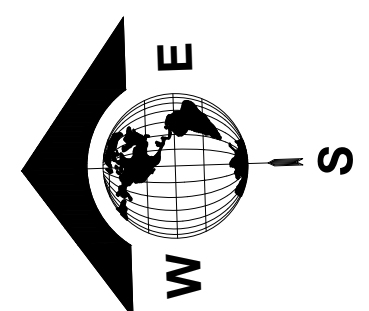

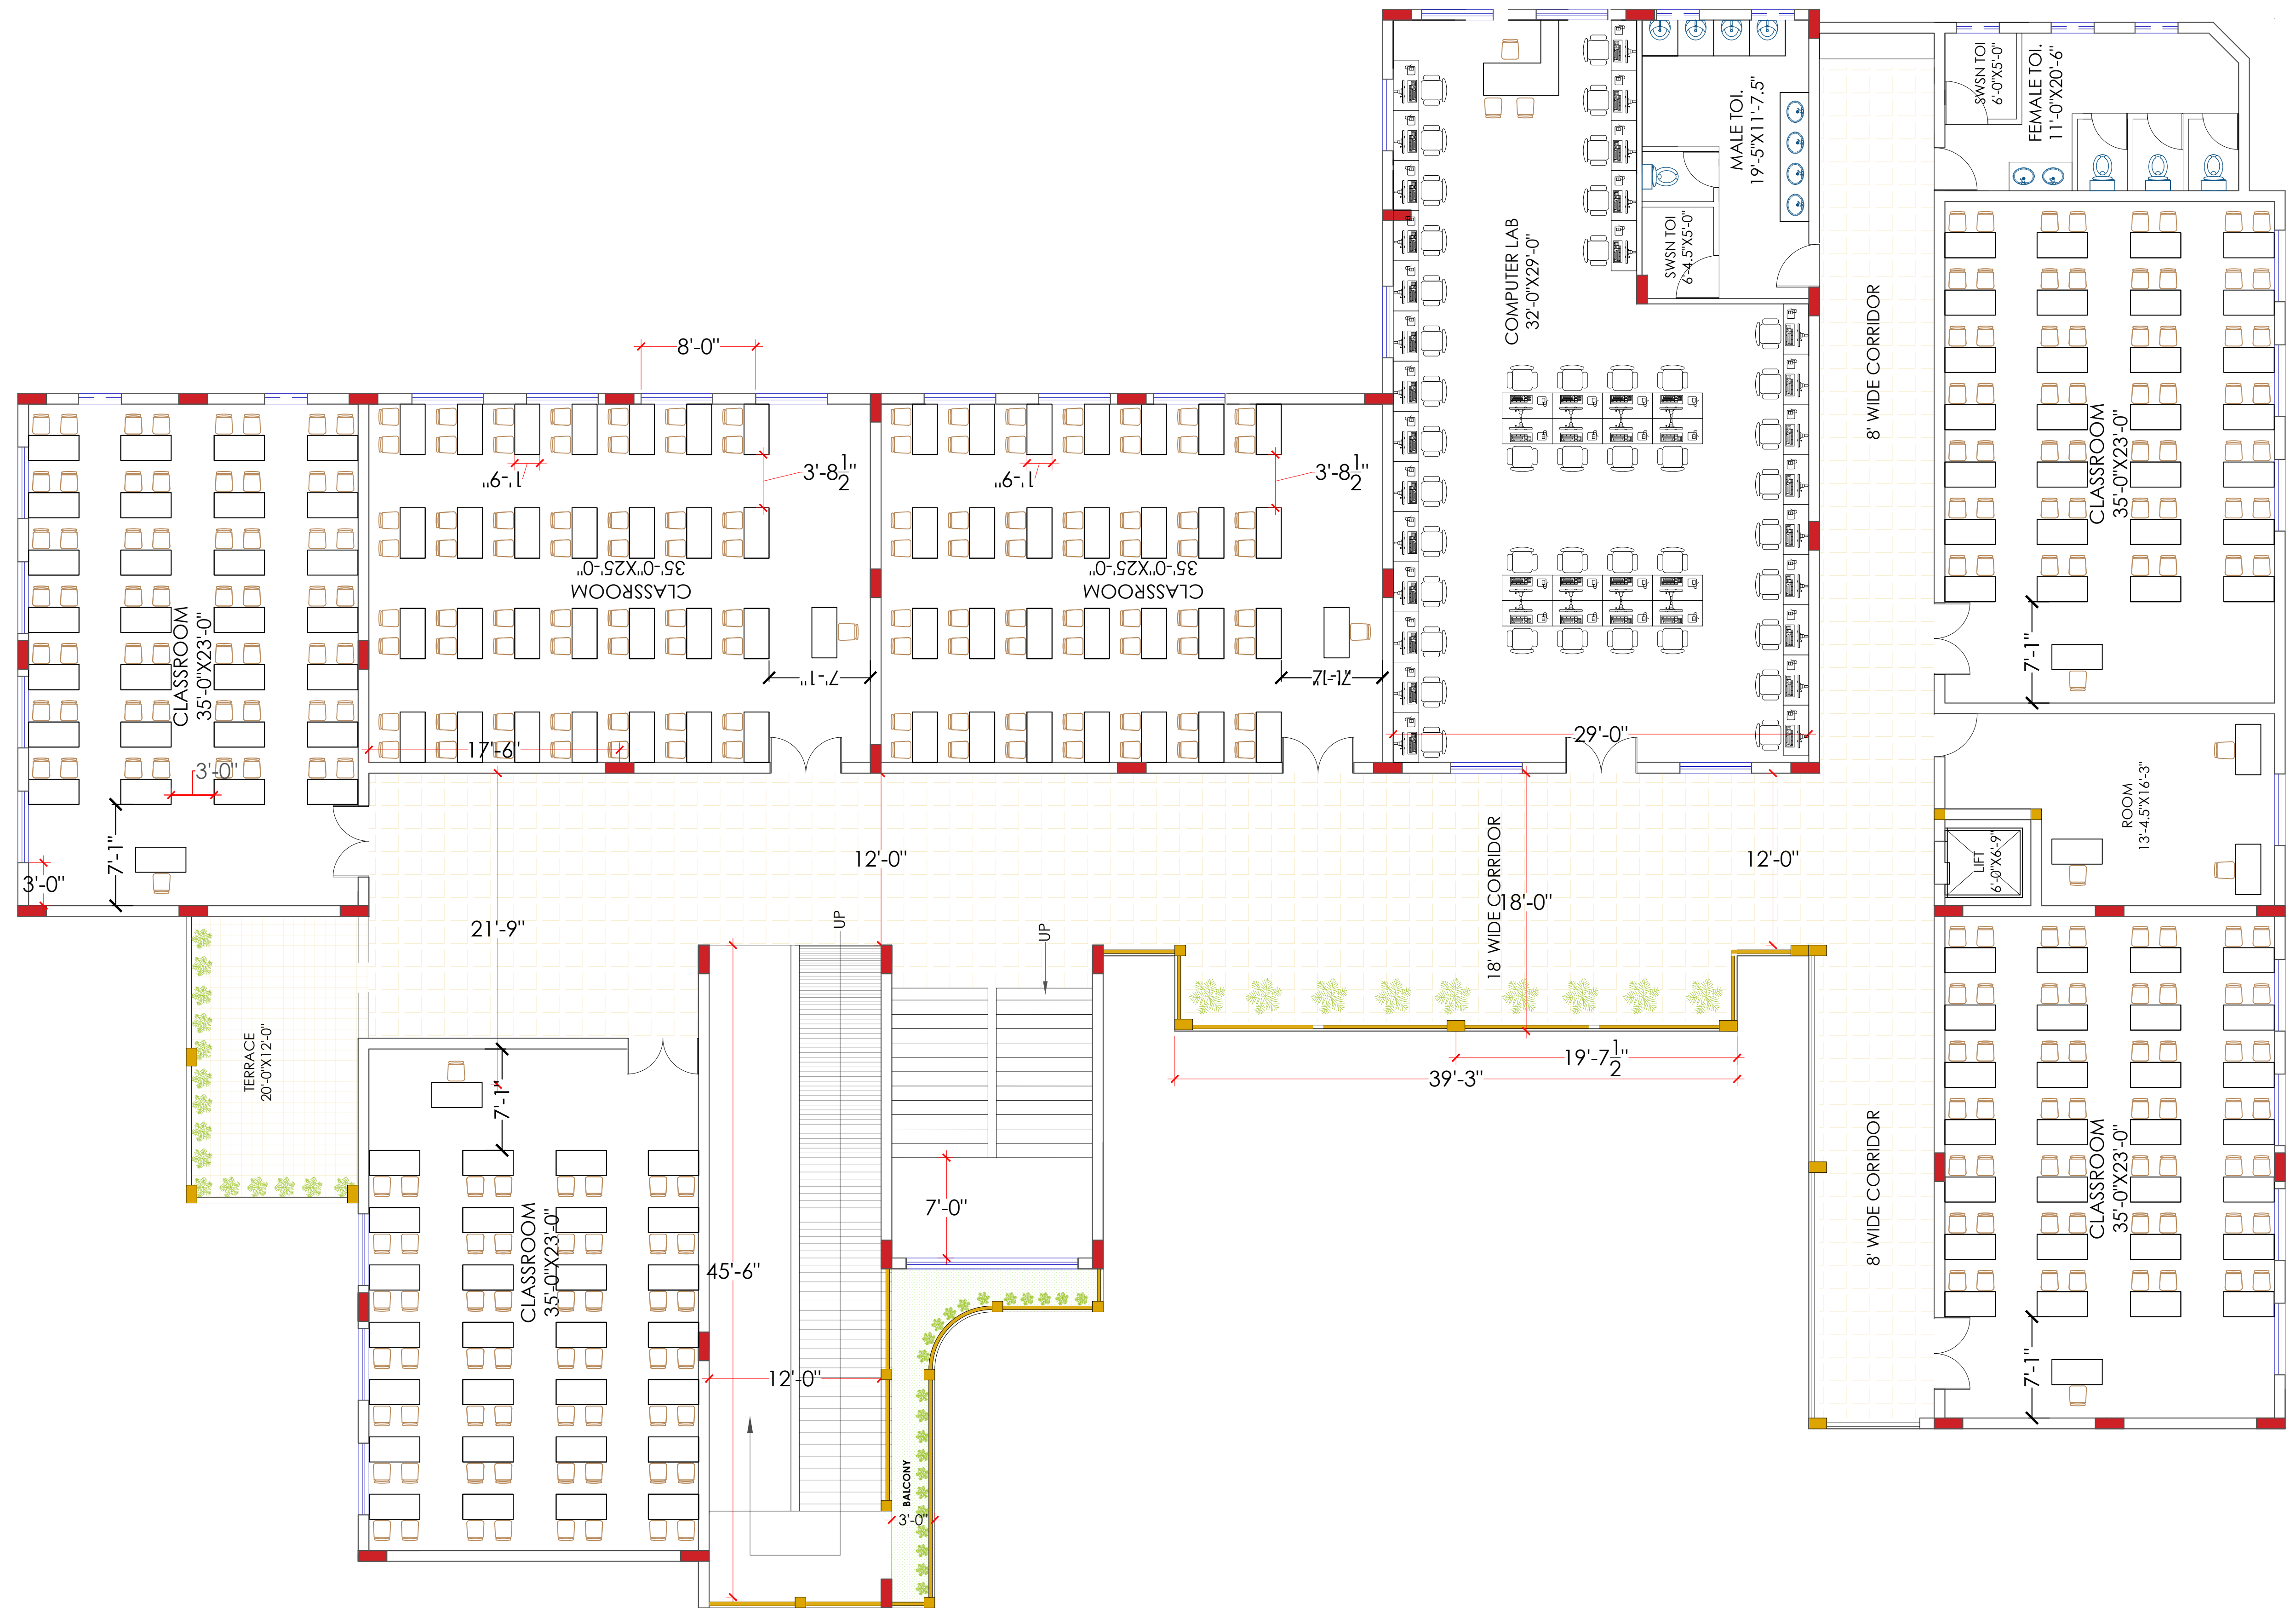

PROJECT NAME -MR. ANURAG WADHWA


DRAWING NAME - PROPOSED FLOOR PLANS - THIRD FL.

- Only written dimension should be followed.
- All dimension should be checked by contractor and any discrepancy in them shall be brought to the notice of Architect before execution.
- Structure details (beam & column) taken here are as given by structural engineer.
- All dimensions are feet & inch.


DRAWN BY –ADITYA

CHECKED BY –DEVENDRA

DATE –09–02–2023

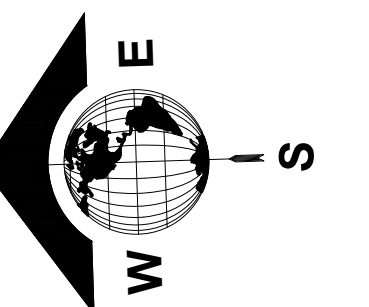

ELEVATION DETAILS PLOT 51

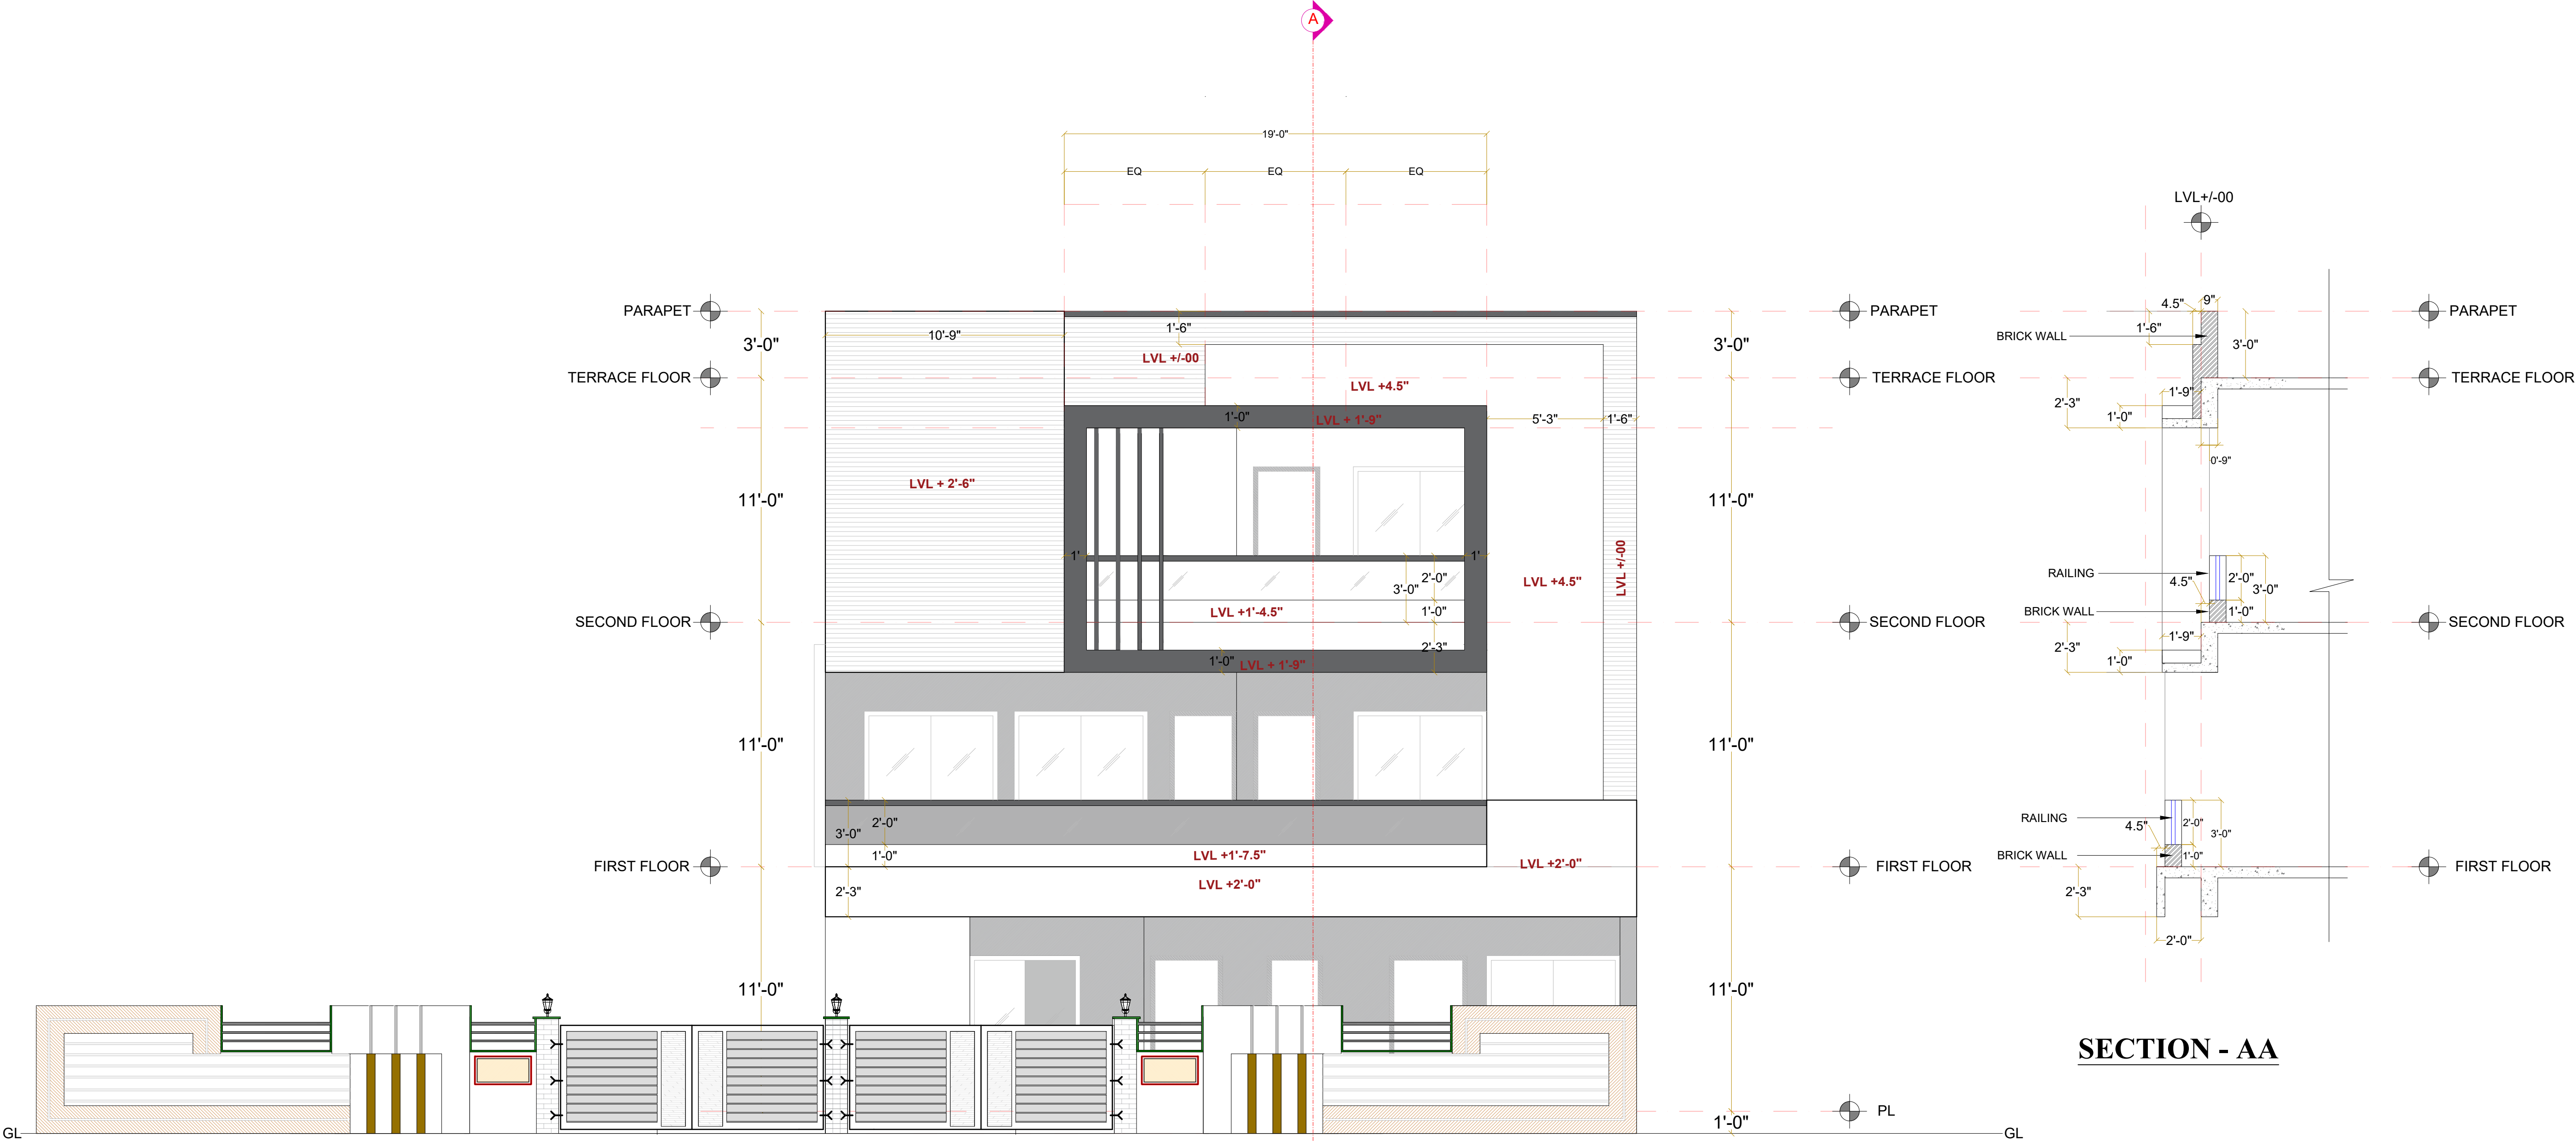

FRONT ELEVATION

NOTE - SLAB LEVEL IS TAKEN AS +/-00 IN ALL FLOORS

PROJECT NAME - MR. NEERAJ GUPTA


DRAWING NAME - WORKING DRAWINGS




- Only written dimension should be followed.
- All dimension should be checked by contractor and any discrepancy in them shall be brought to the notice of Architect before execution.
- Structure details (beam & column) taken here are as given by structural engineer.
- All dimensions are feet & inch.

DRAWN BY -ADITYA


CHECKED BY -DEVENDRA

DATE -21 - 03 - 2023

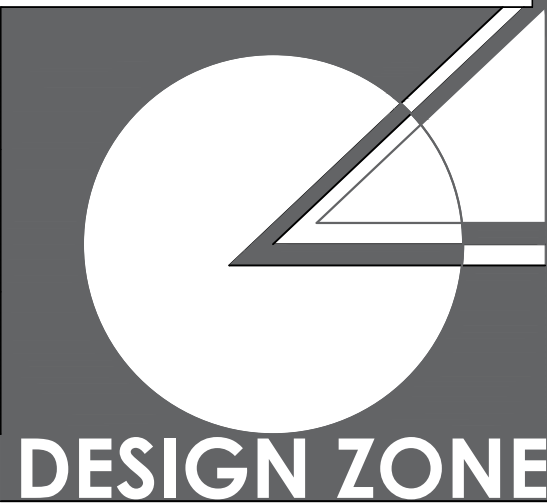


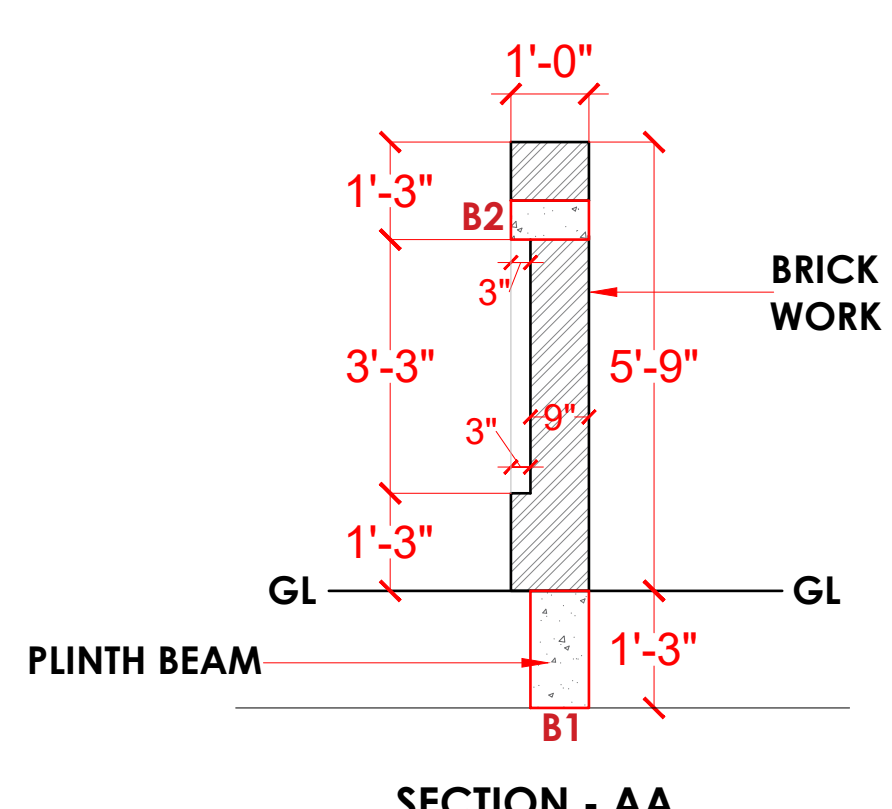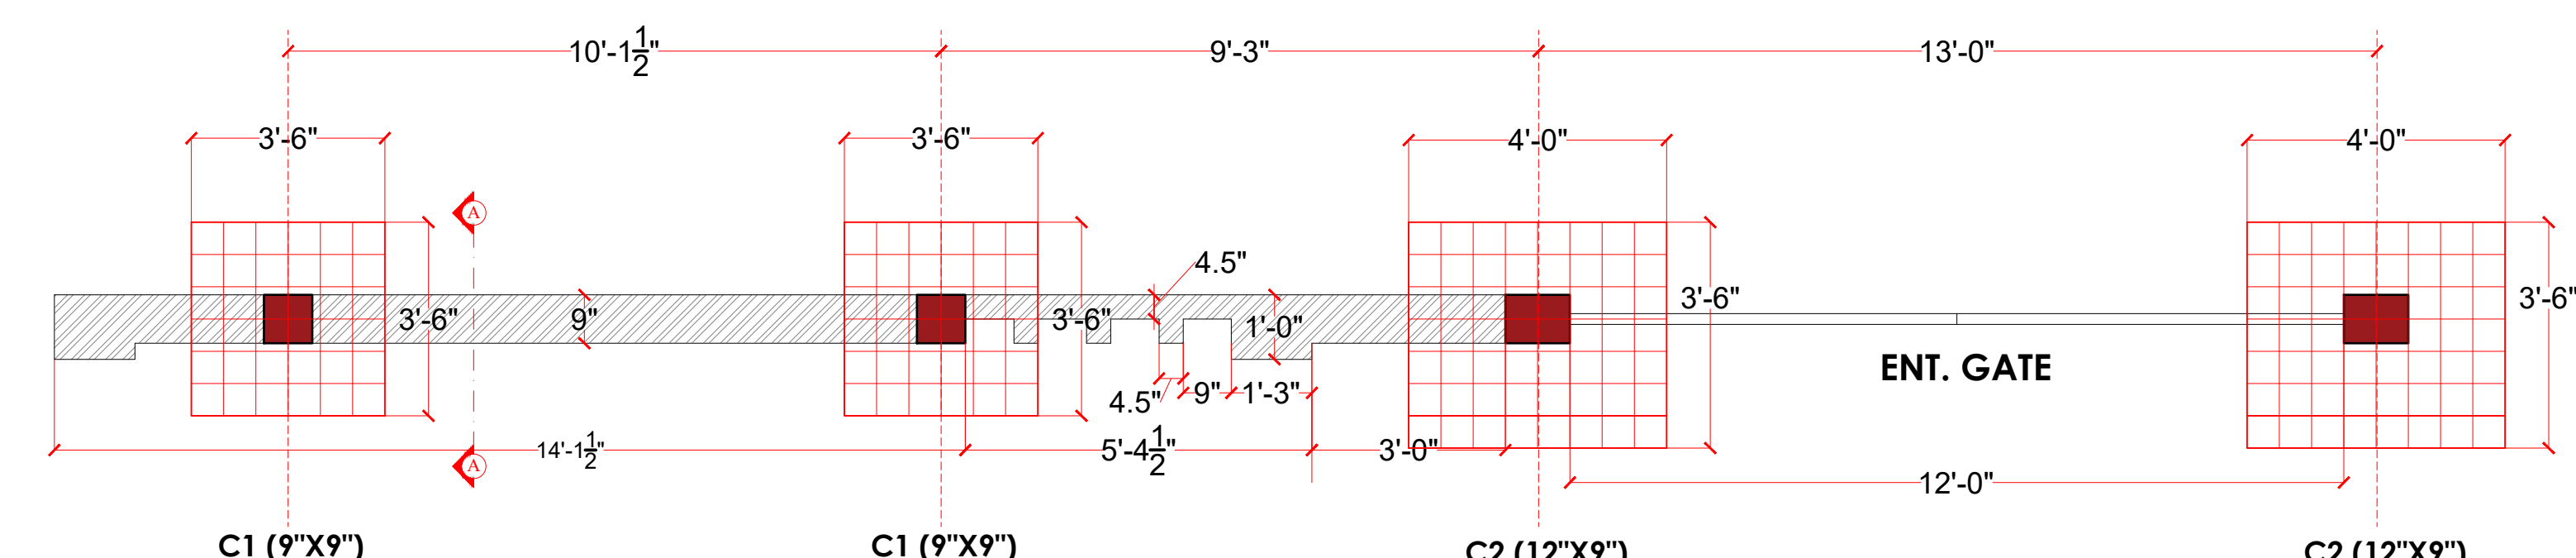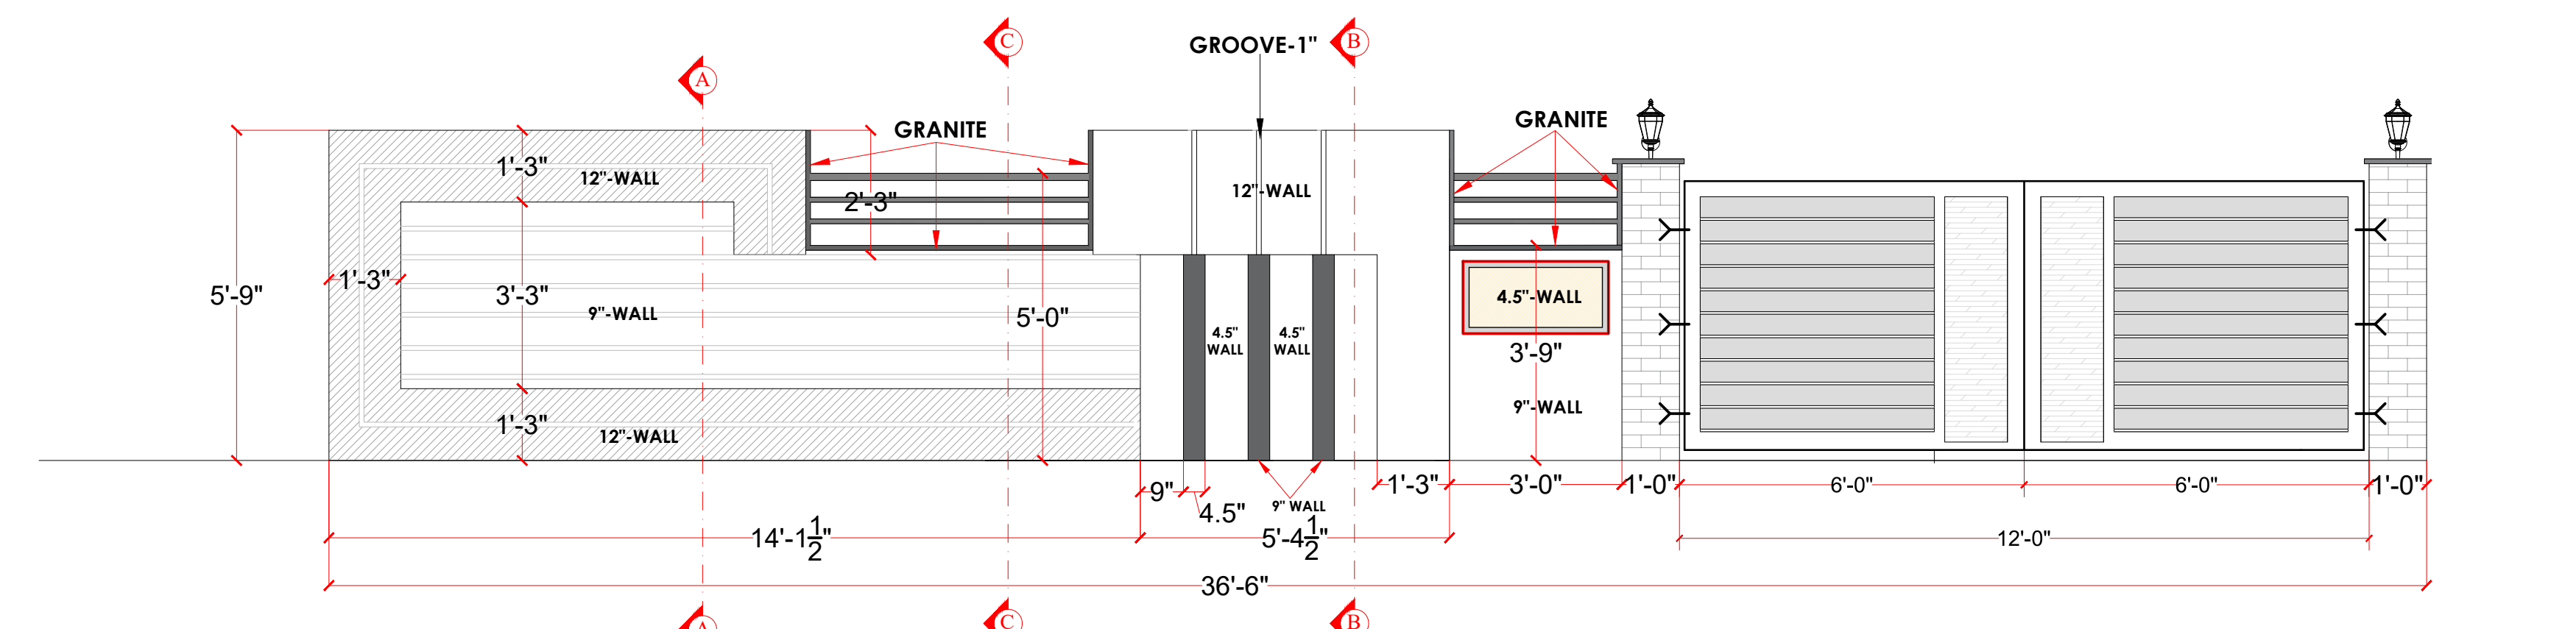


SECTION - AA

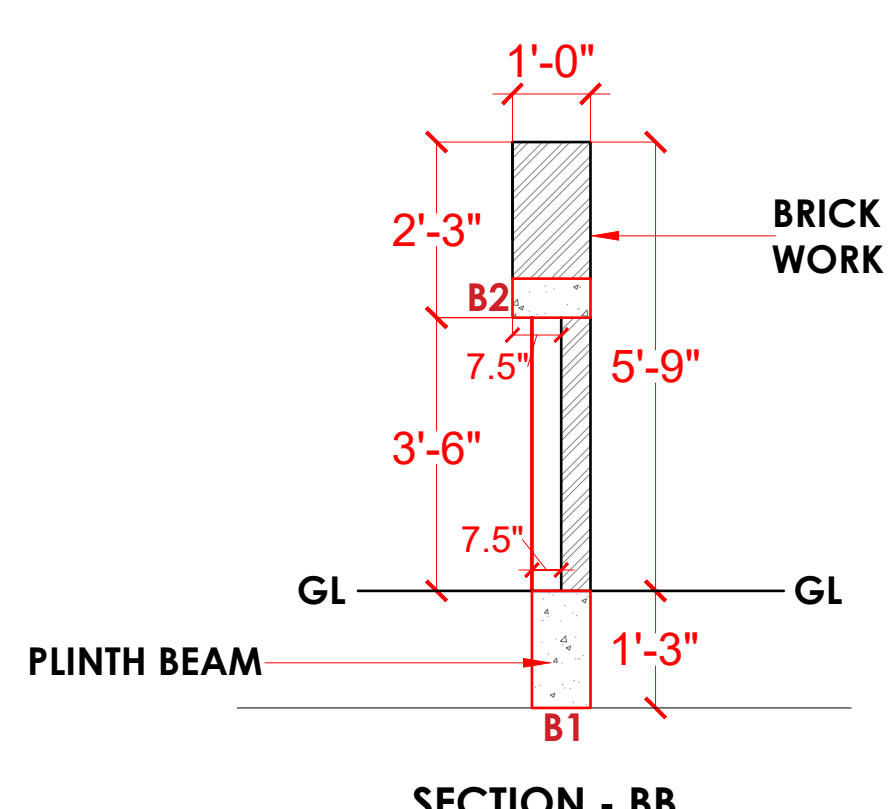


SECTION - BB

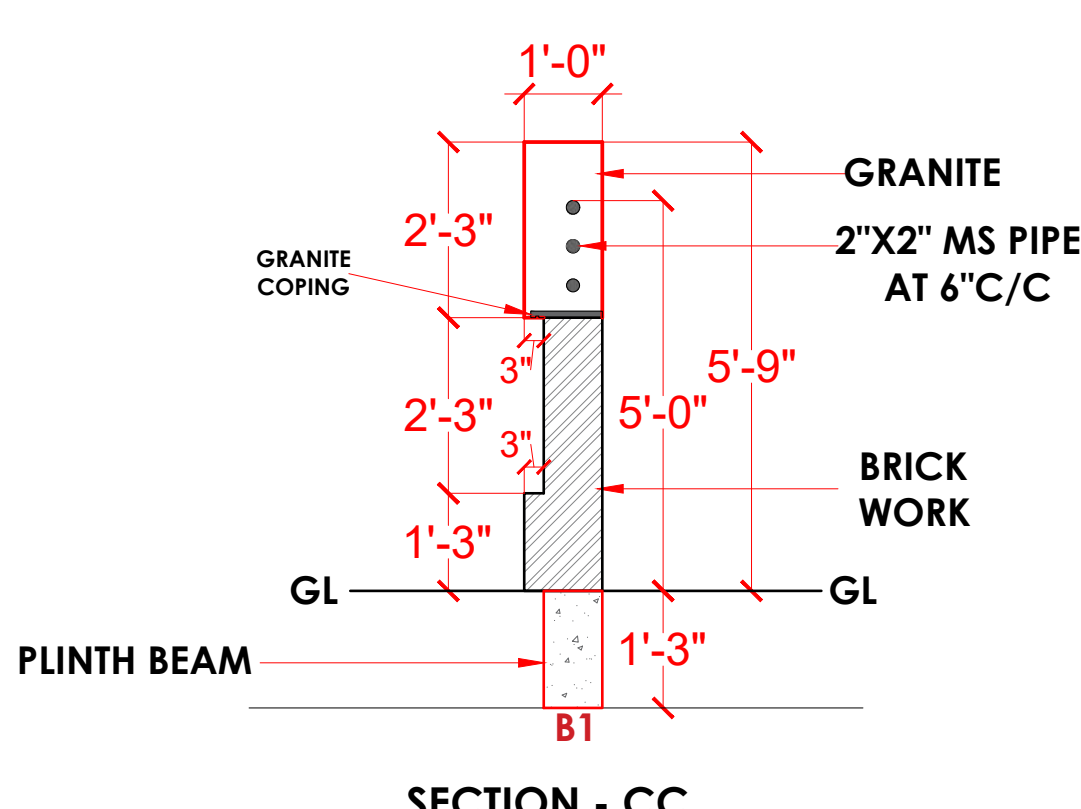


SECTION - CC

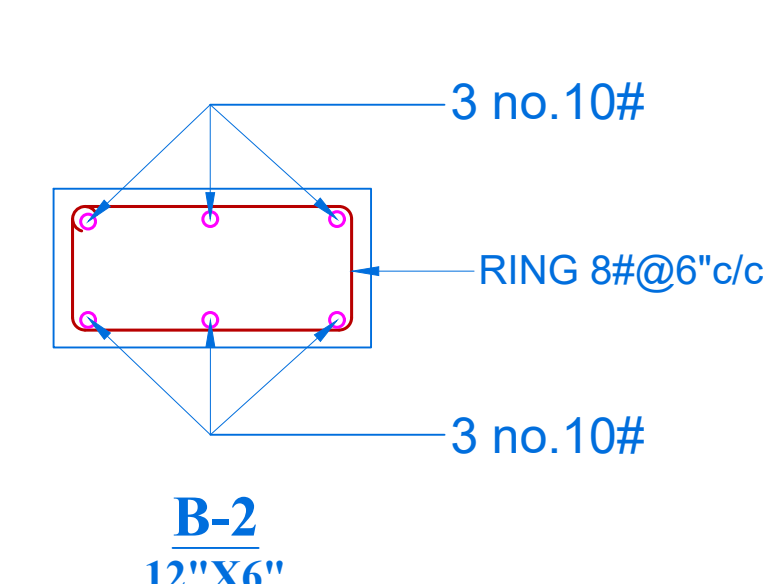


B-2
12"X6"

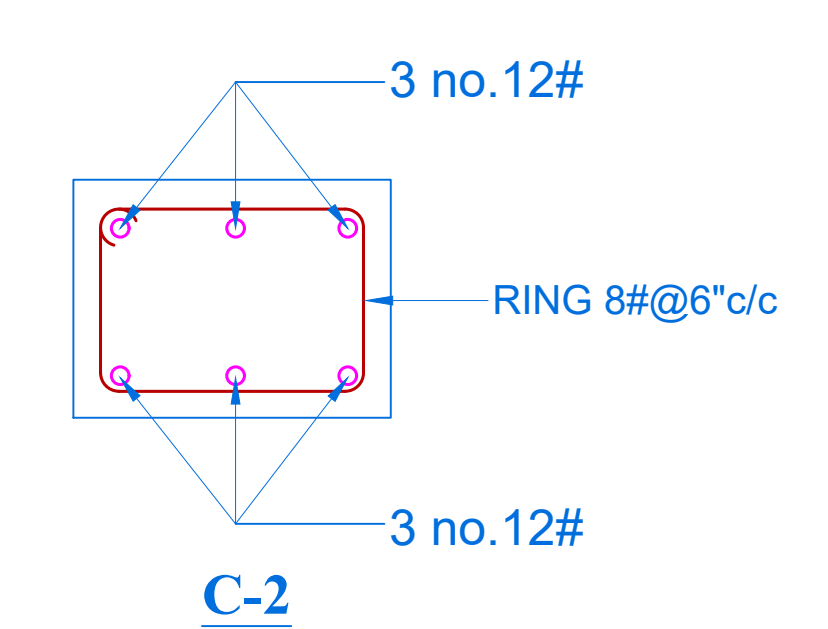


C-2
12"X9"

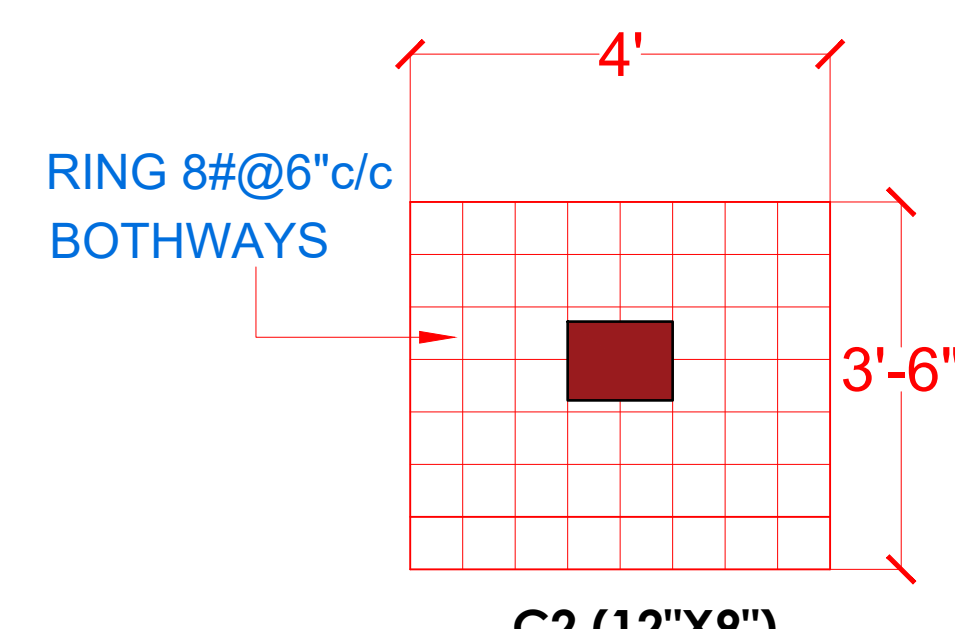

C2 (12"X9")

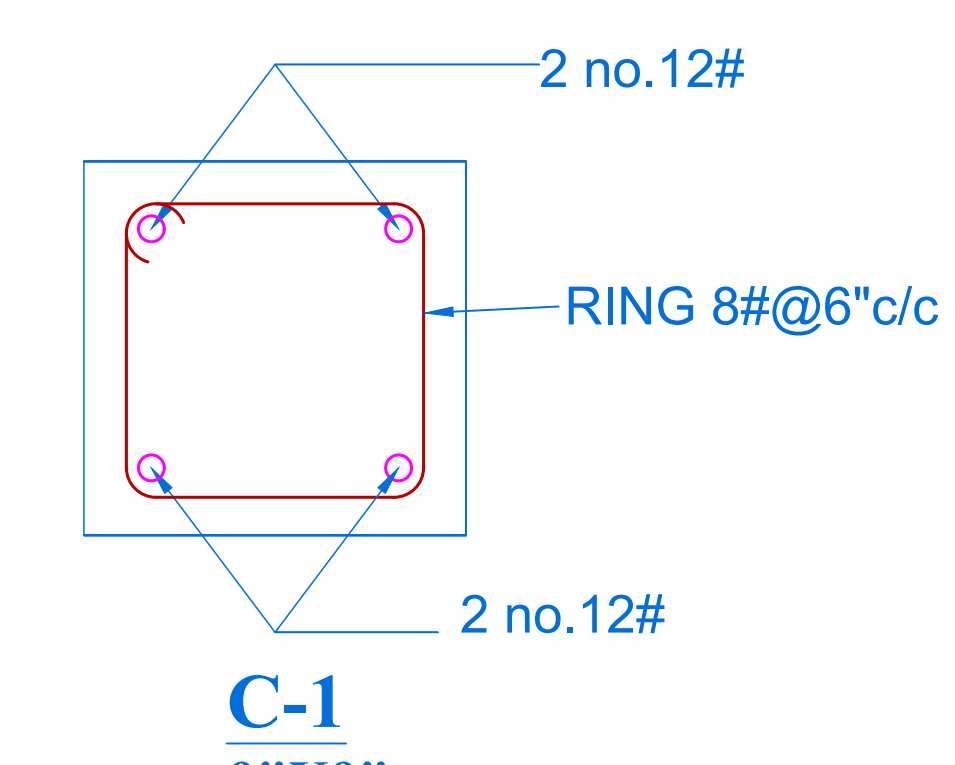


C-1
9"X9"

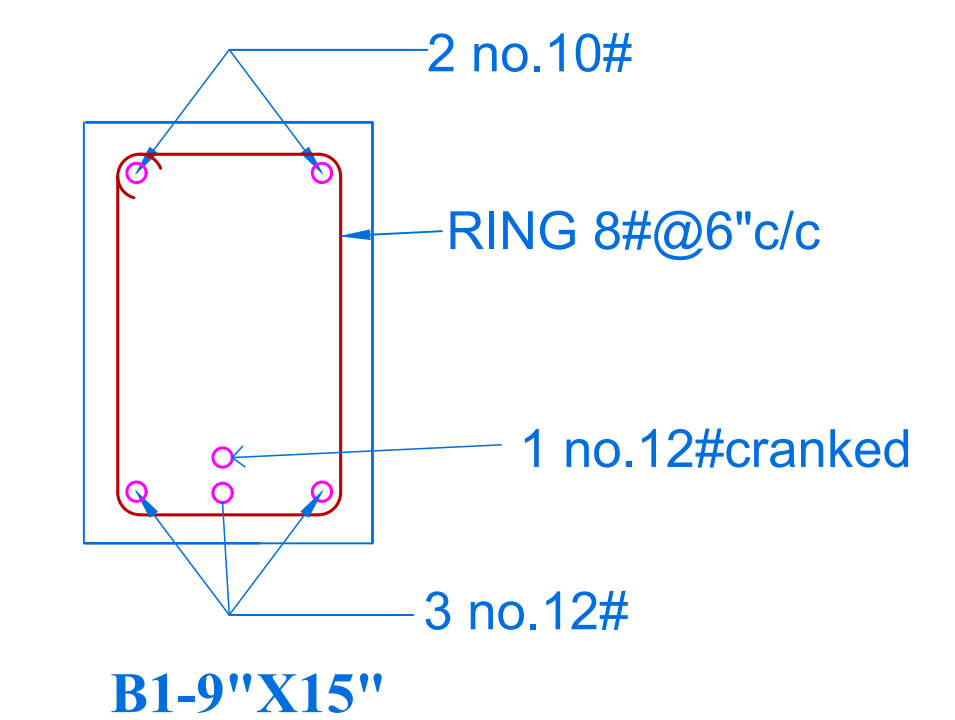

B1-9"X15"

PLINTH BEAM

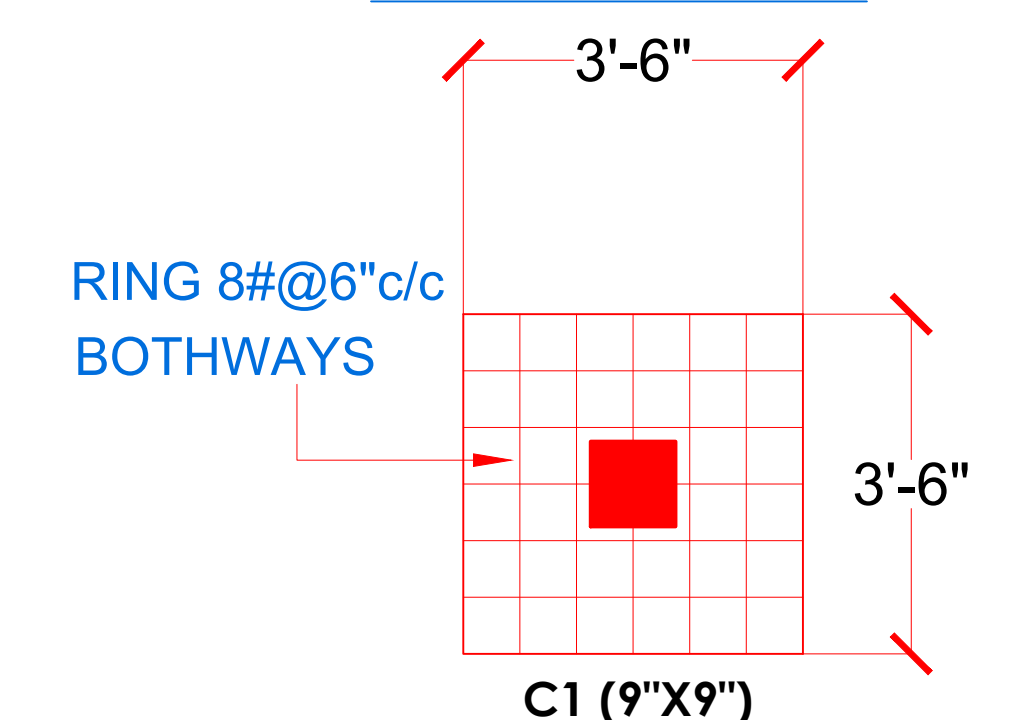

C1 (9"X9")

BOUNDARY WALL DETAILS PLOT 51

PLOT 51

PROJECT NAME - MR. NEERAJ GUPTA

DRAWING NAME - WORKING DRAWINGS

- Only written dimension should be followed.
- All dimension should be checked by contractor and any discrepancy in them shall be brought to the notice of Architect before execution.
- Structure details (beam & column) taken here are as given by structural engineer.
- All dimensions are feet & inch.


DRAWN BY -ADITYA

CHECKED BY -DEVENDRA

DATE -21 - 03 - 2023




DOOR AND WINDOW DETAILS

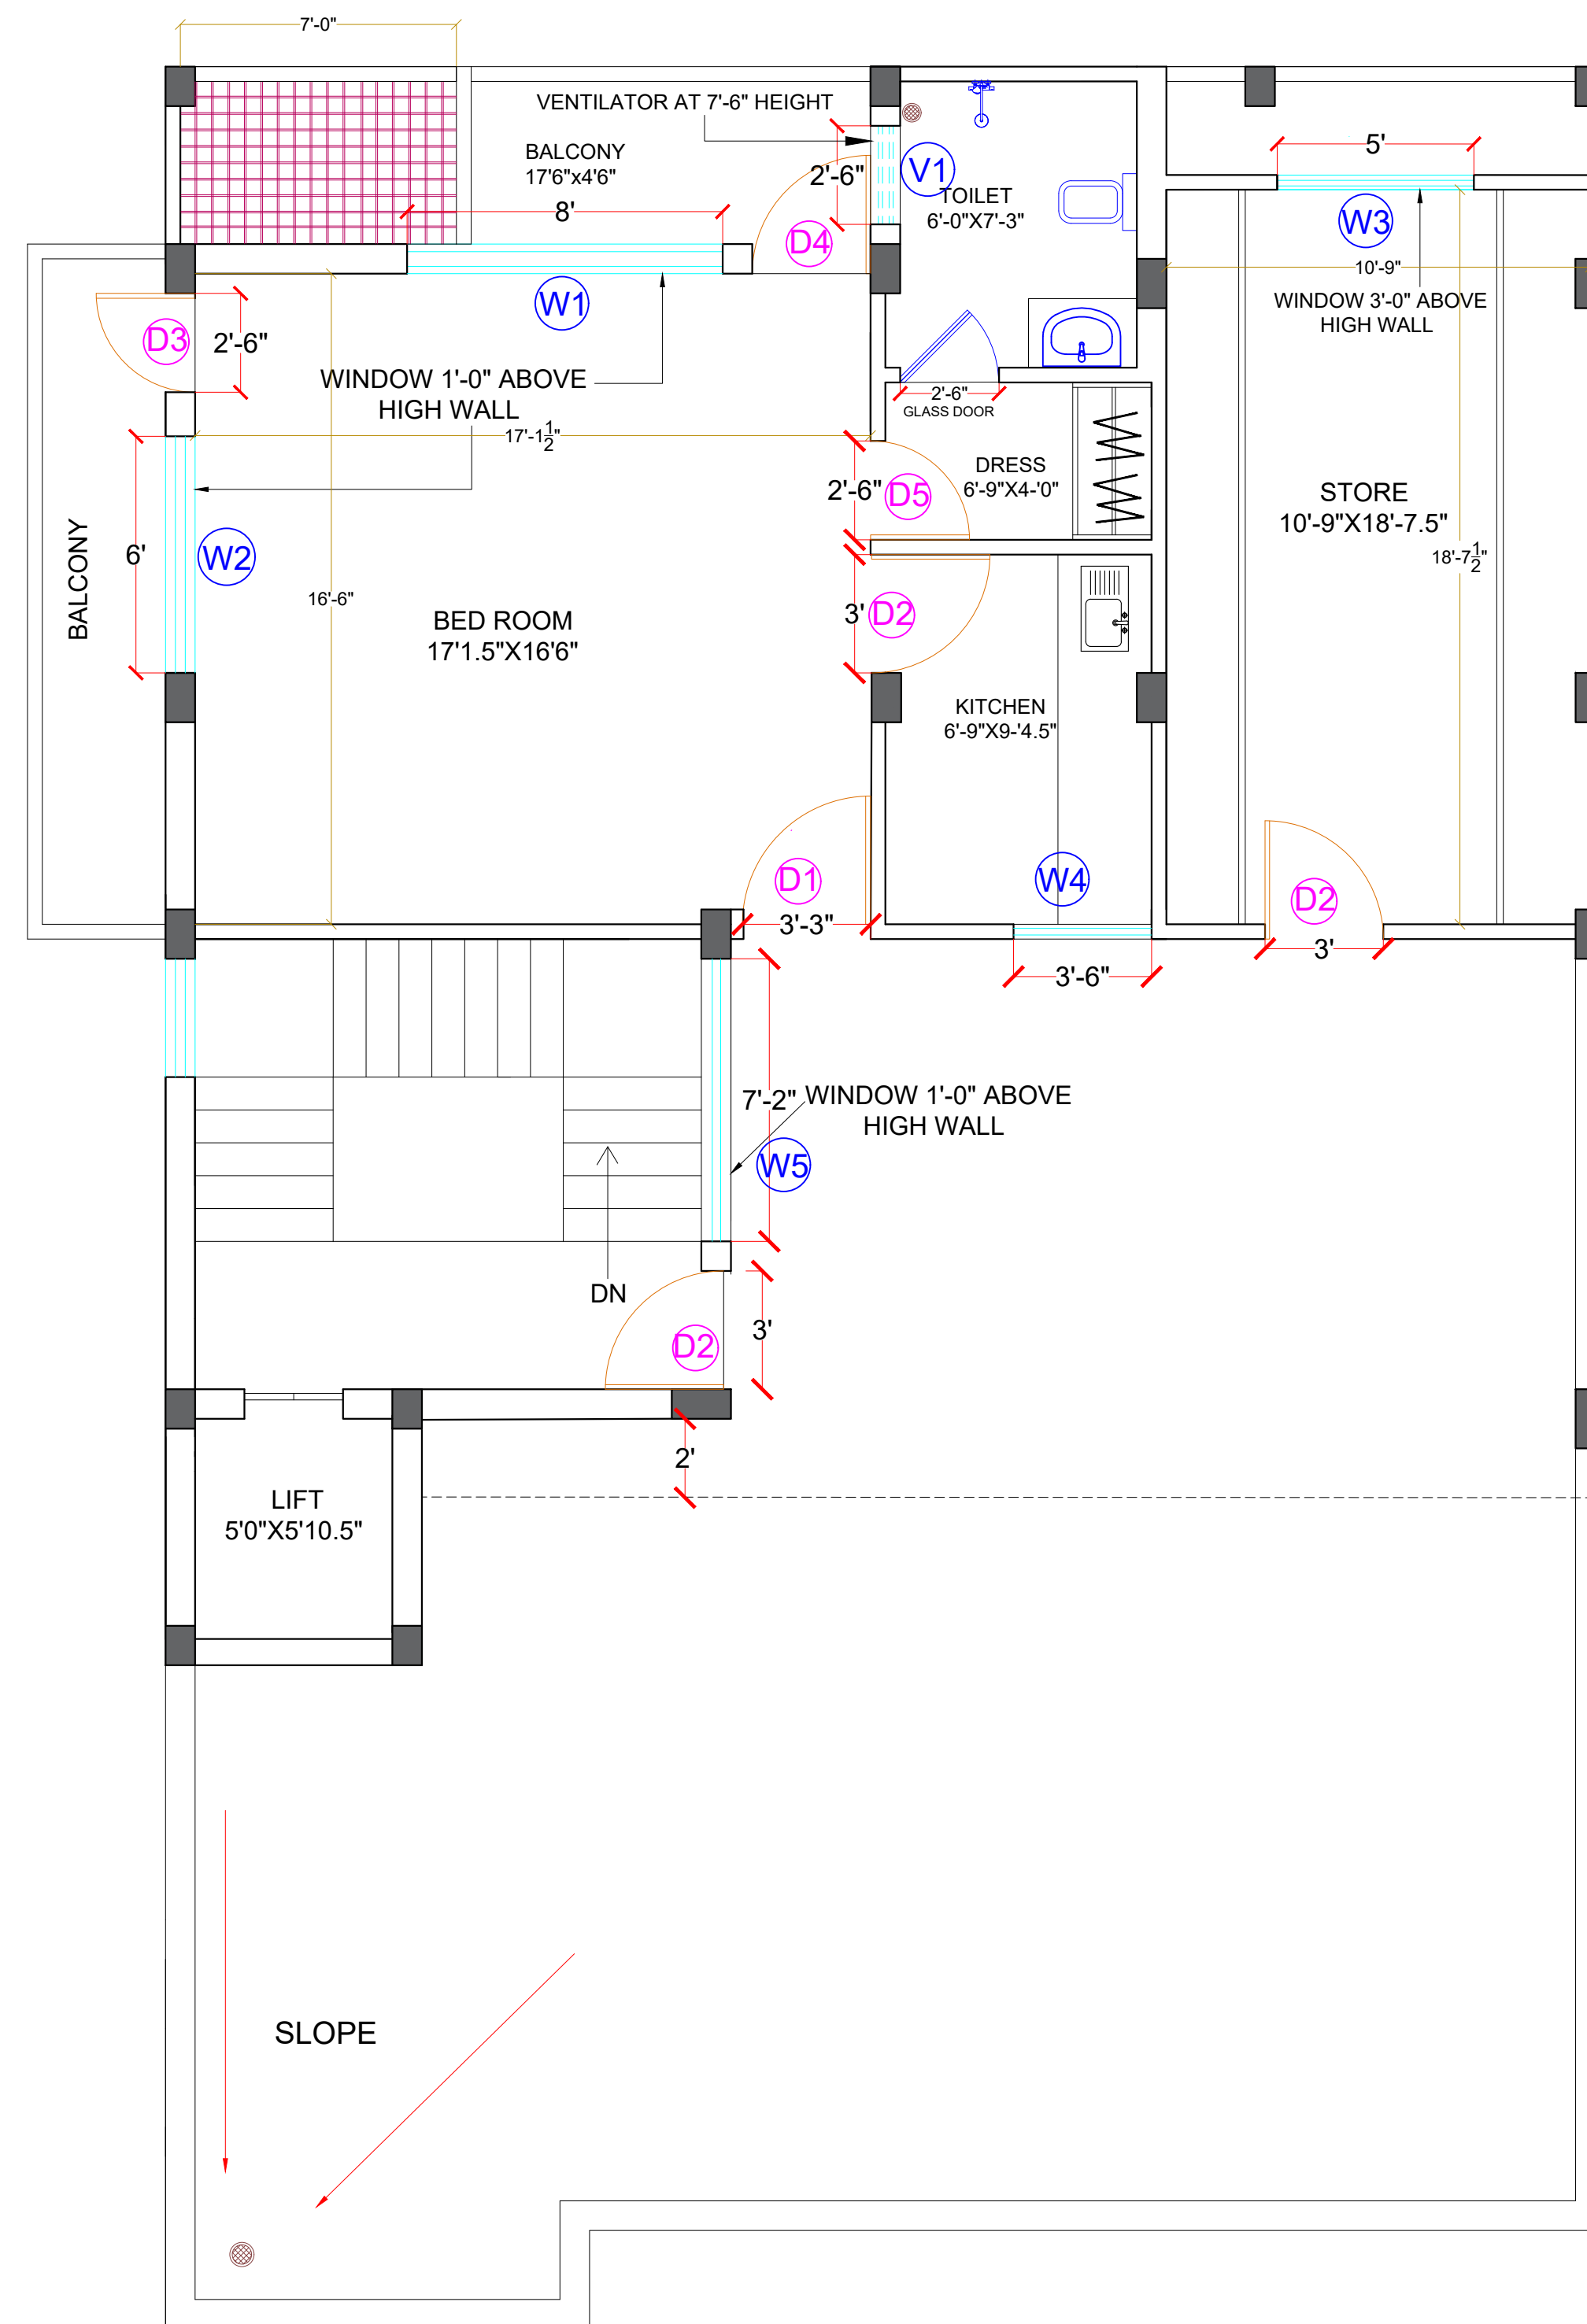

TERRACE FL. DOOR AND DETAILS(PLOT 51)


DOOR DETAILS

DOOR	SIZE	PLACE	FRAME	NO	FRAME SIZE	RIVET TYPE
D1	(3'3"x7'0")	BED ROOMS	WOODEN	1	(2 1/2"x5")	SINGLE
D2	(3'0"x7'0")	ENT/KITCHEN STORE	WOODEN	3	(2 1/2"x5")	SINGLE
D3	(2'6"x7'0")	BALCONY	GRANITE	1	(2 1/2"x5")	DOUBLE
D4	(3'0"x7'0")	BALCONY	GRANITE	1	(2 1/2"x5")	DOUBLE
D5	(2'6"x7'0")	DRESS	WOODEN	1	(2 1/2"x5")	SINGLE

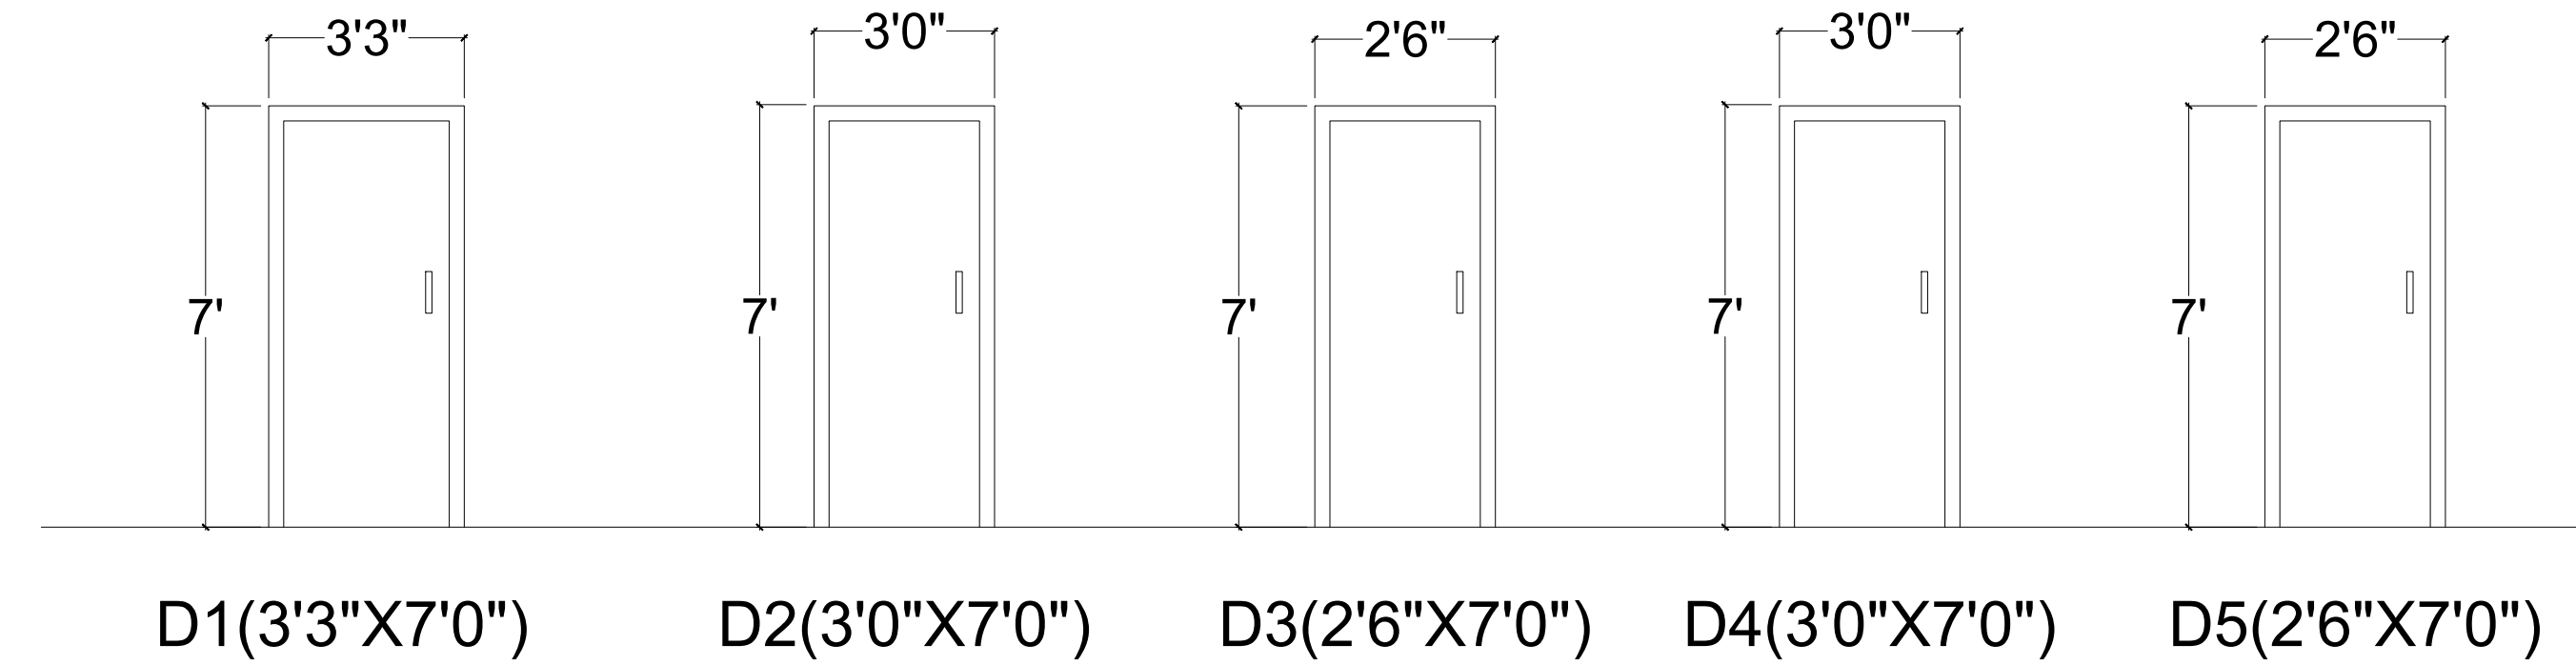

WINDOW DETAILS

WINDOW	SIZE	PLACE	FRAME	NUMBER	REMARK
W1	(8'0"x6'0")	BED ROOM	GRANITE	1	UPVC
W2	(6'0"x6'0")	BED ROOMS	GRANITE	1	UPVC
W3	(5'0"x4'0")	BED ROOM	GRANITE	1	UPVC
W4	(3'6"x3'0")	KITCHEN	GRANITE	1	UPVC
W5	(7'2"x6'0")	STAIR	GRANITE	1	UPVC
V1	(2'6"x1'6")	TOILET	GRANITE	1	UPVC

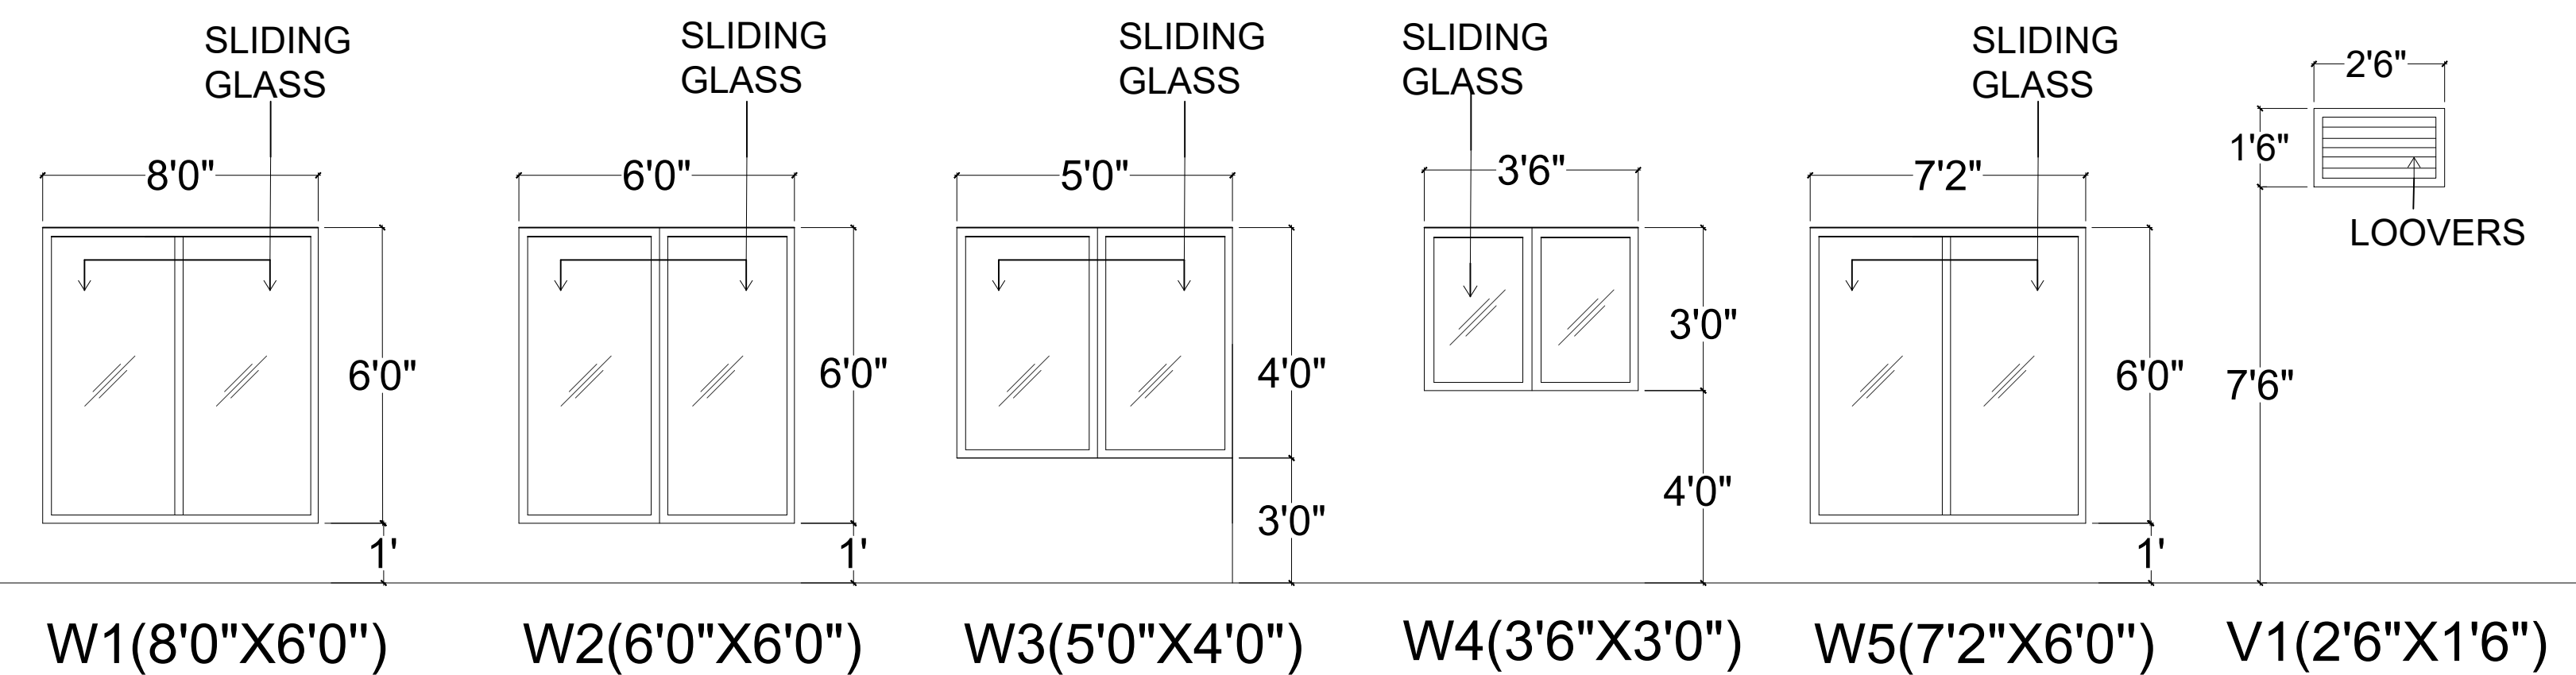

PLOT 51

PROJECT NAME - MR. NEERAJ GUPTA

DRAWING NAME - WORKING DRAWINGS


- Only written dimension should be followed.
- All dimension should be checked by contractor and any discrepancy in them shall be brought to the notice of Architect before execution.
- Structure details (beam & column) taken here are as given by structural engineer.
- All dimensions are feet & inch.

DRAWN BY -ADITYA


CHECKED BY -DEVENDRA

DATE -21 - 03 - 2023




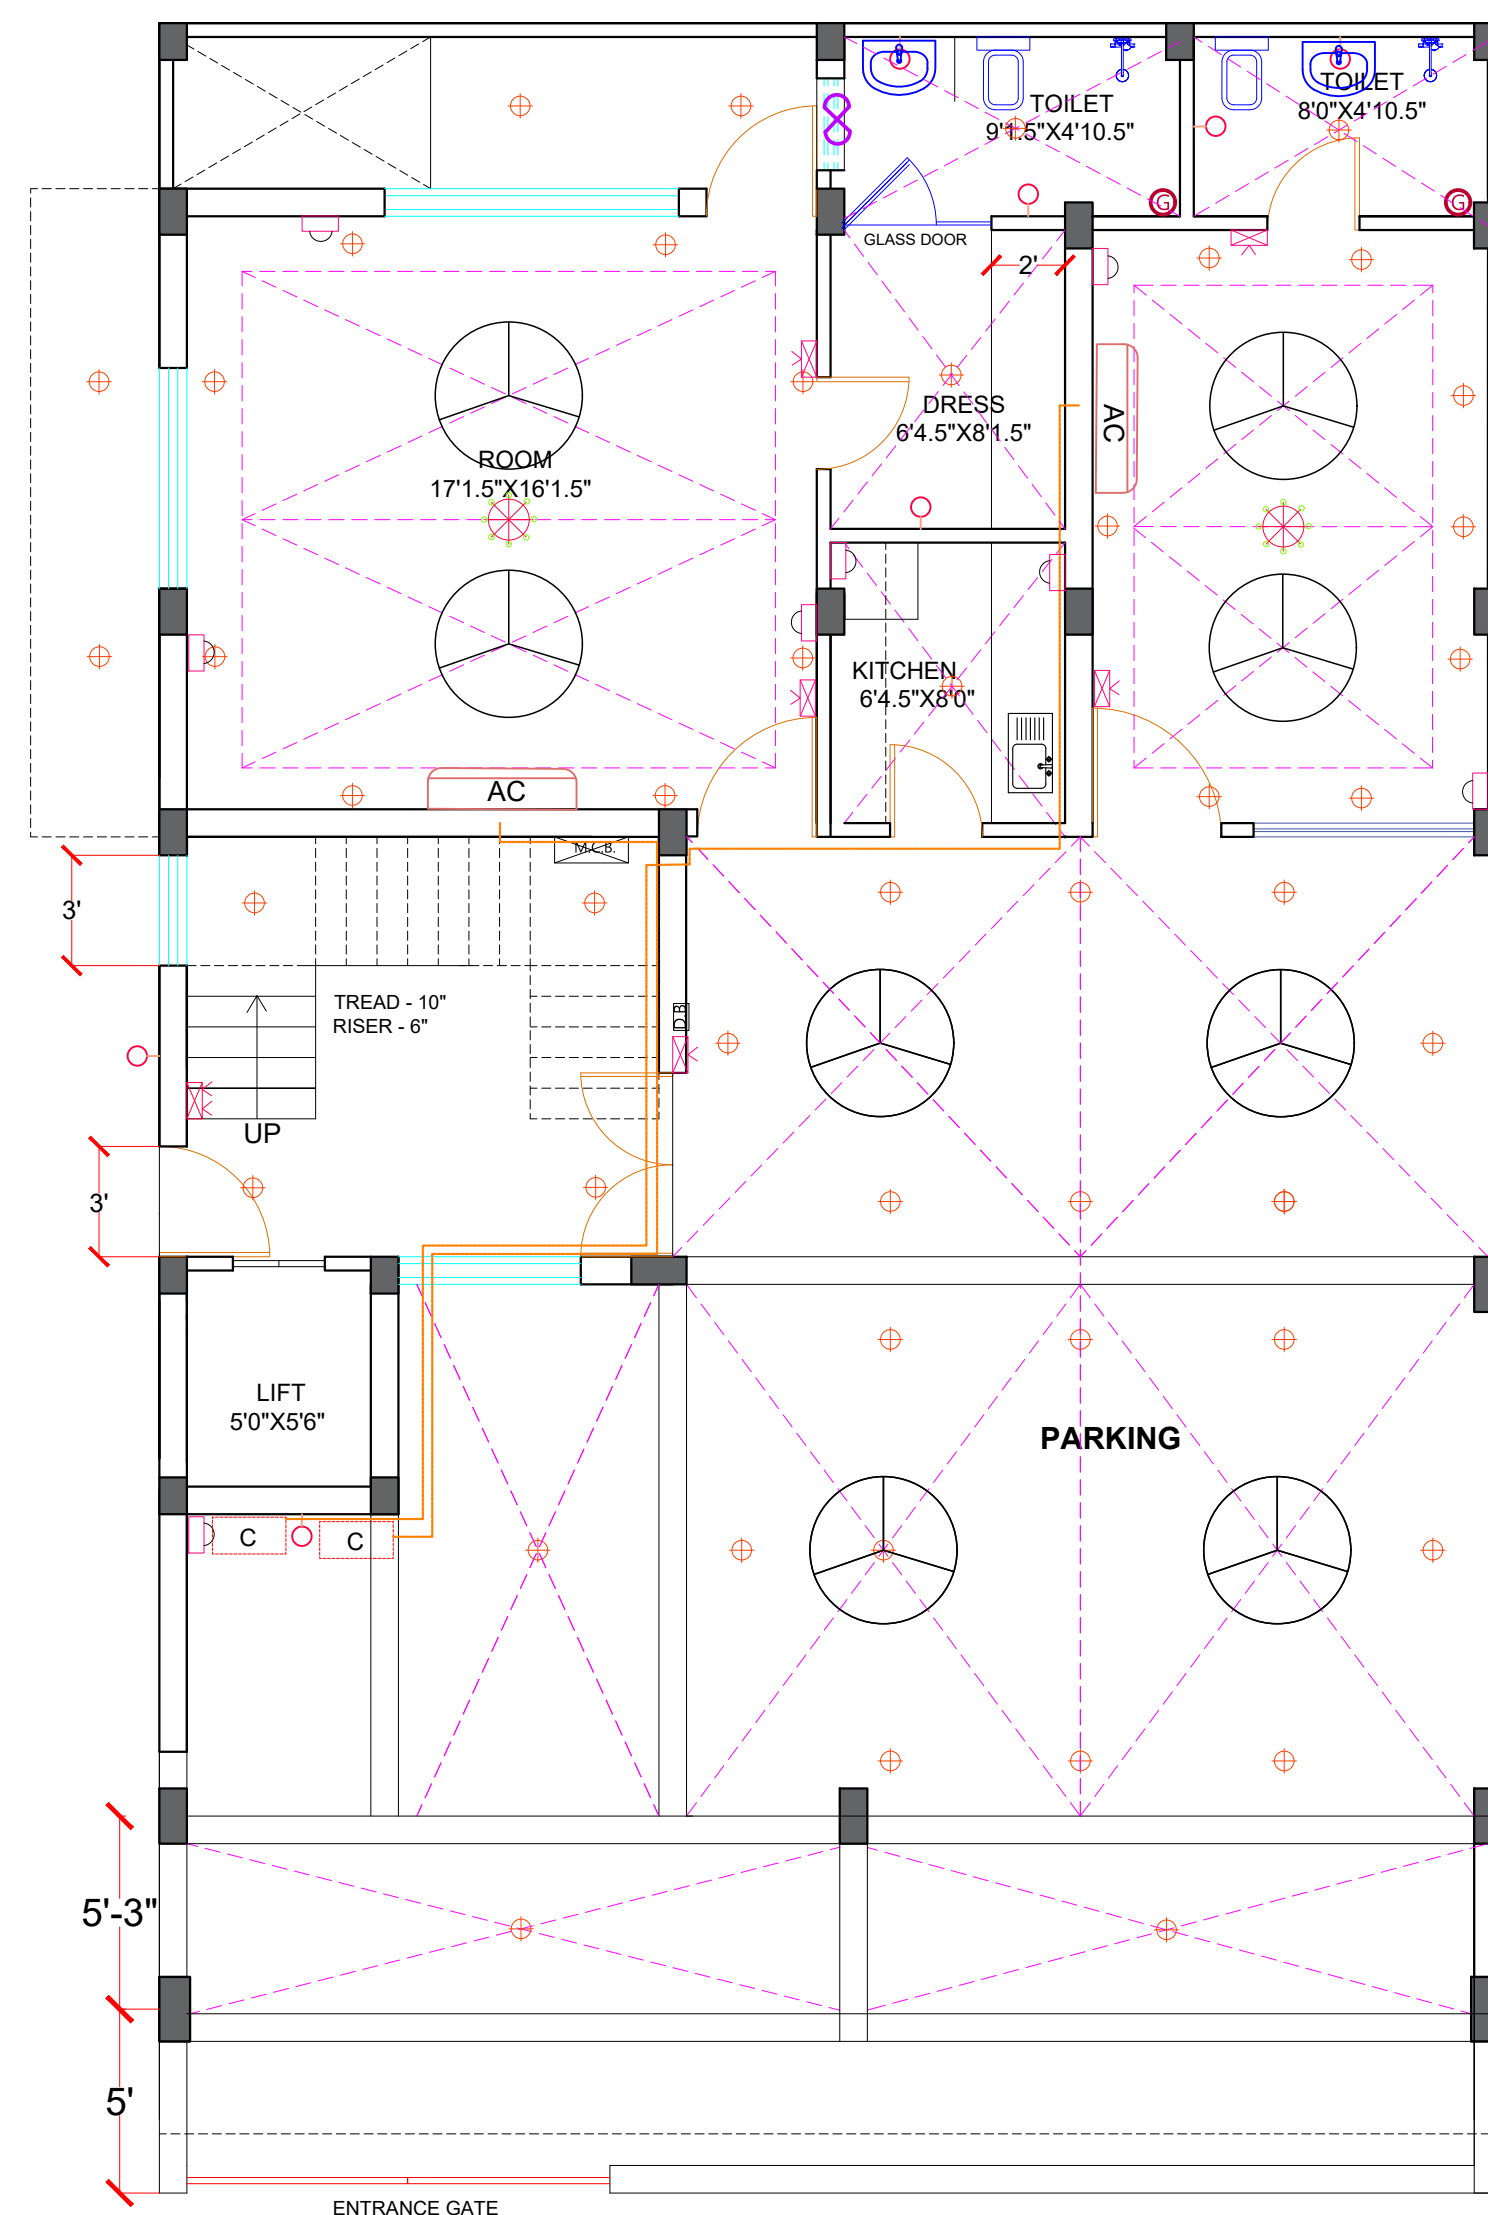

GROUND FL. LAYOUT
ELECTRICAL PLAN_(PLOT 51)

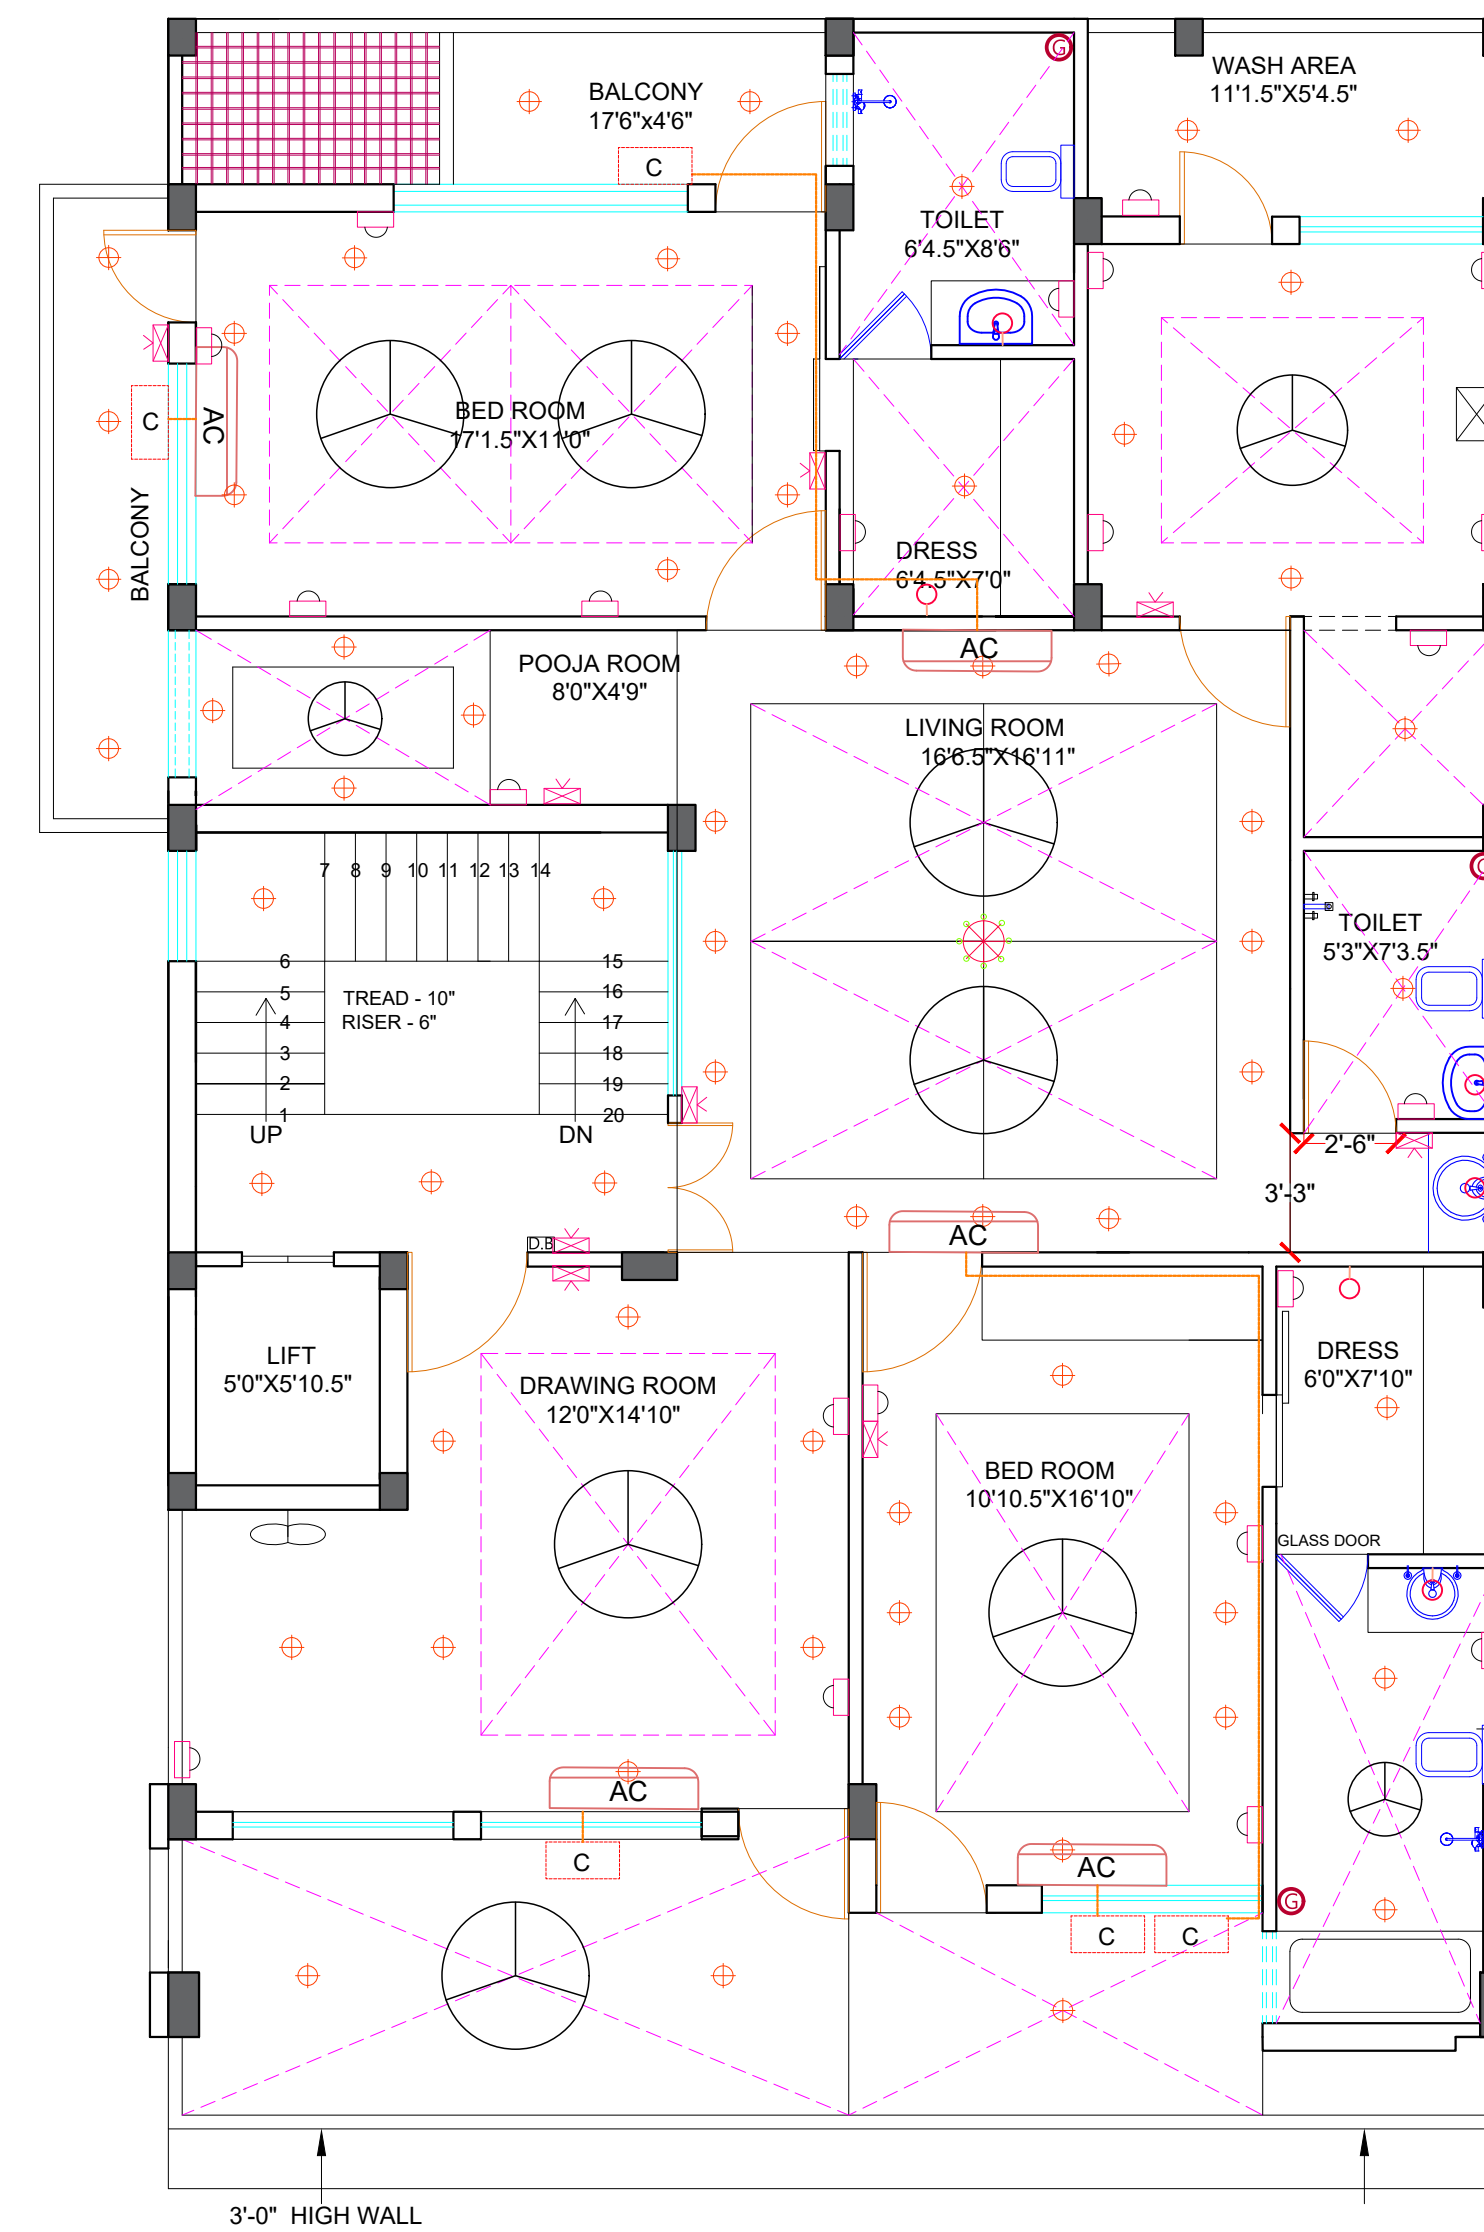

FIRST FL. LAYOUT ELECTRICAL
PLAN (PLOT_51)

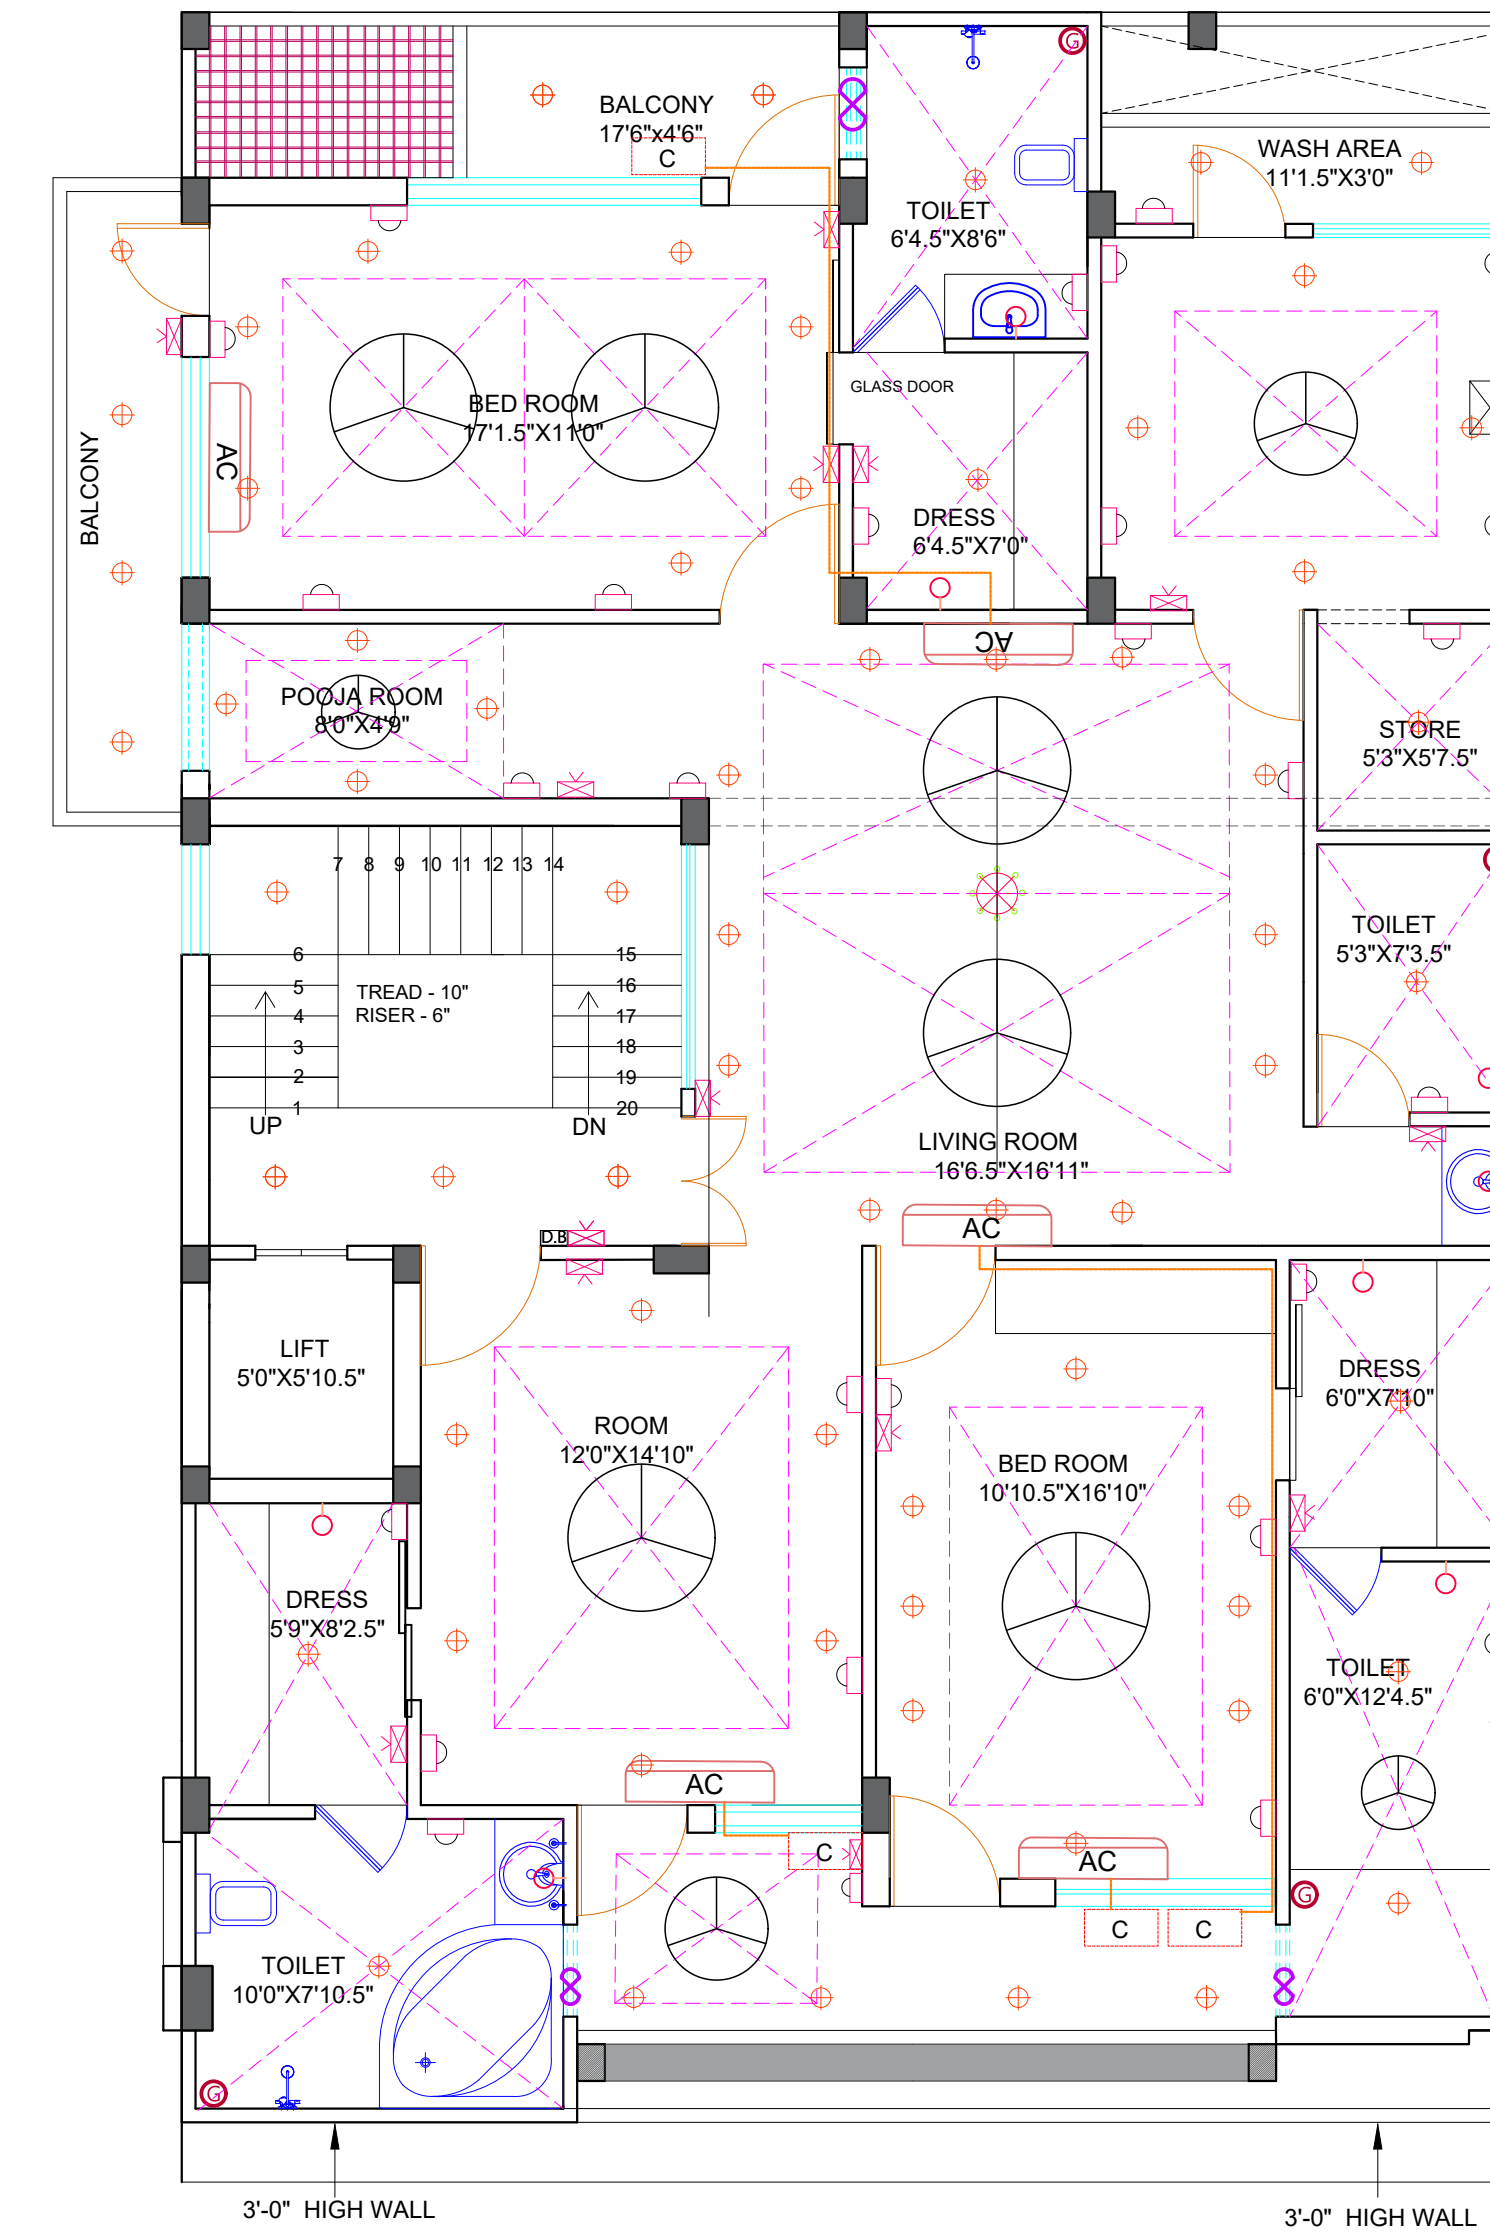

SECOND FL. ELECTRICAL
LAYOUT PLAN(PLOT-51)

LEGEND

1. SWITCH BOARD	
2. POWER POINT	
3. CEILING FAN	
4. EXHAUST	
5. LIGHT (WALL)	
6. CEILING LIGHT	
7. GEYSER	
8. TWO WAY SWITCH	
9. A.C.	
10. CHANDLIER	
11. DOOR BELL	
12. M.C.B.	
13. BOUNDARY LAMP	
14. KITCHEN CHIMENY	
14. WALL FAN	
15. COMPRESSOR	

PROJECT NAME - MR. NEERAJ GUPTA

DRAWING NAME - WORKING DRAWINGS

- Only written dimension should be followed.
- All dimension should be checked by contractor and any discrepancy in them shall be brought to the notice of Architect before execution.
- Structure details (beam & column) taken here are as given by structural engineer.
- All dimensions are feet & inch.


DRAWN BY -ADITYA

CHECKED BY -DEVENDRA


DATE -21 - 03 - 2023

PLOT 51




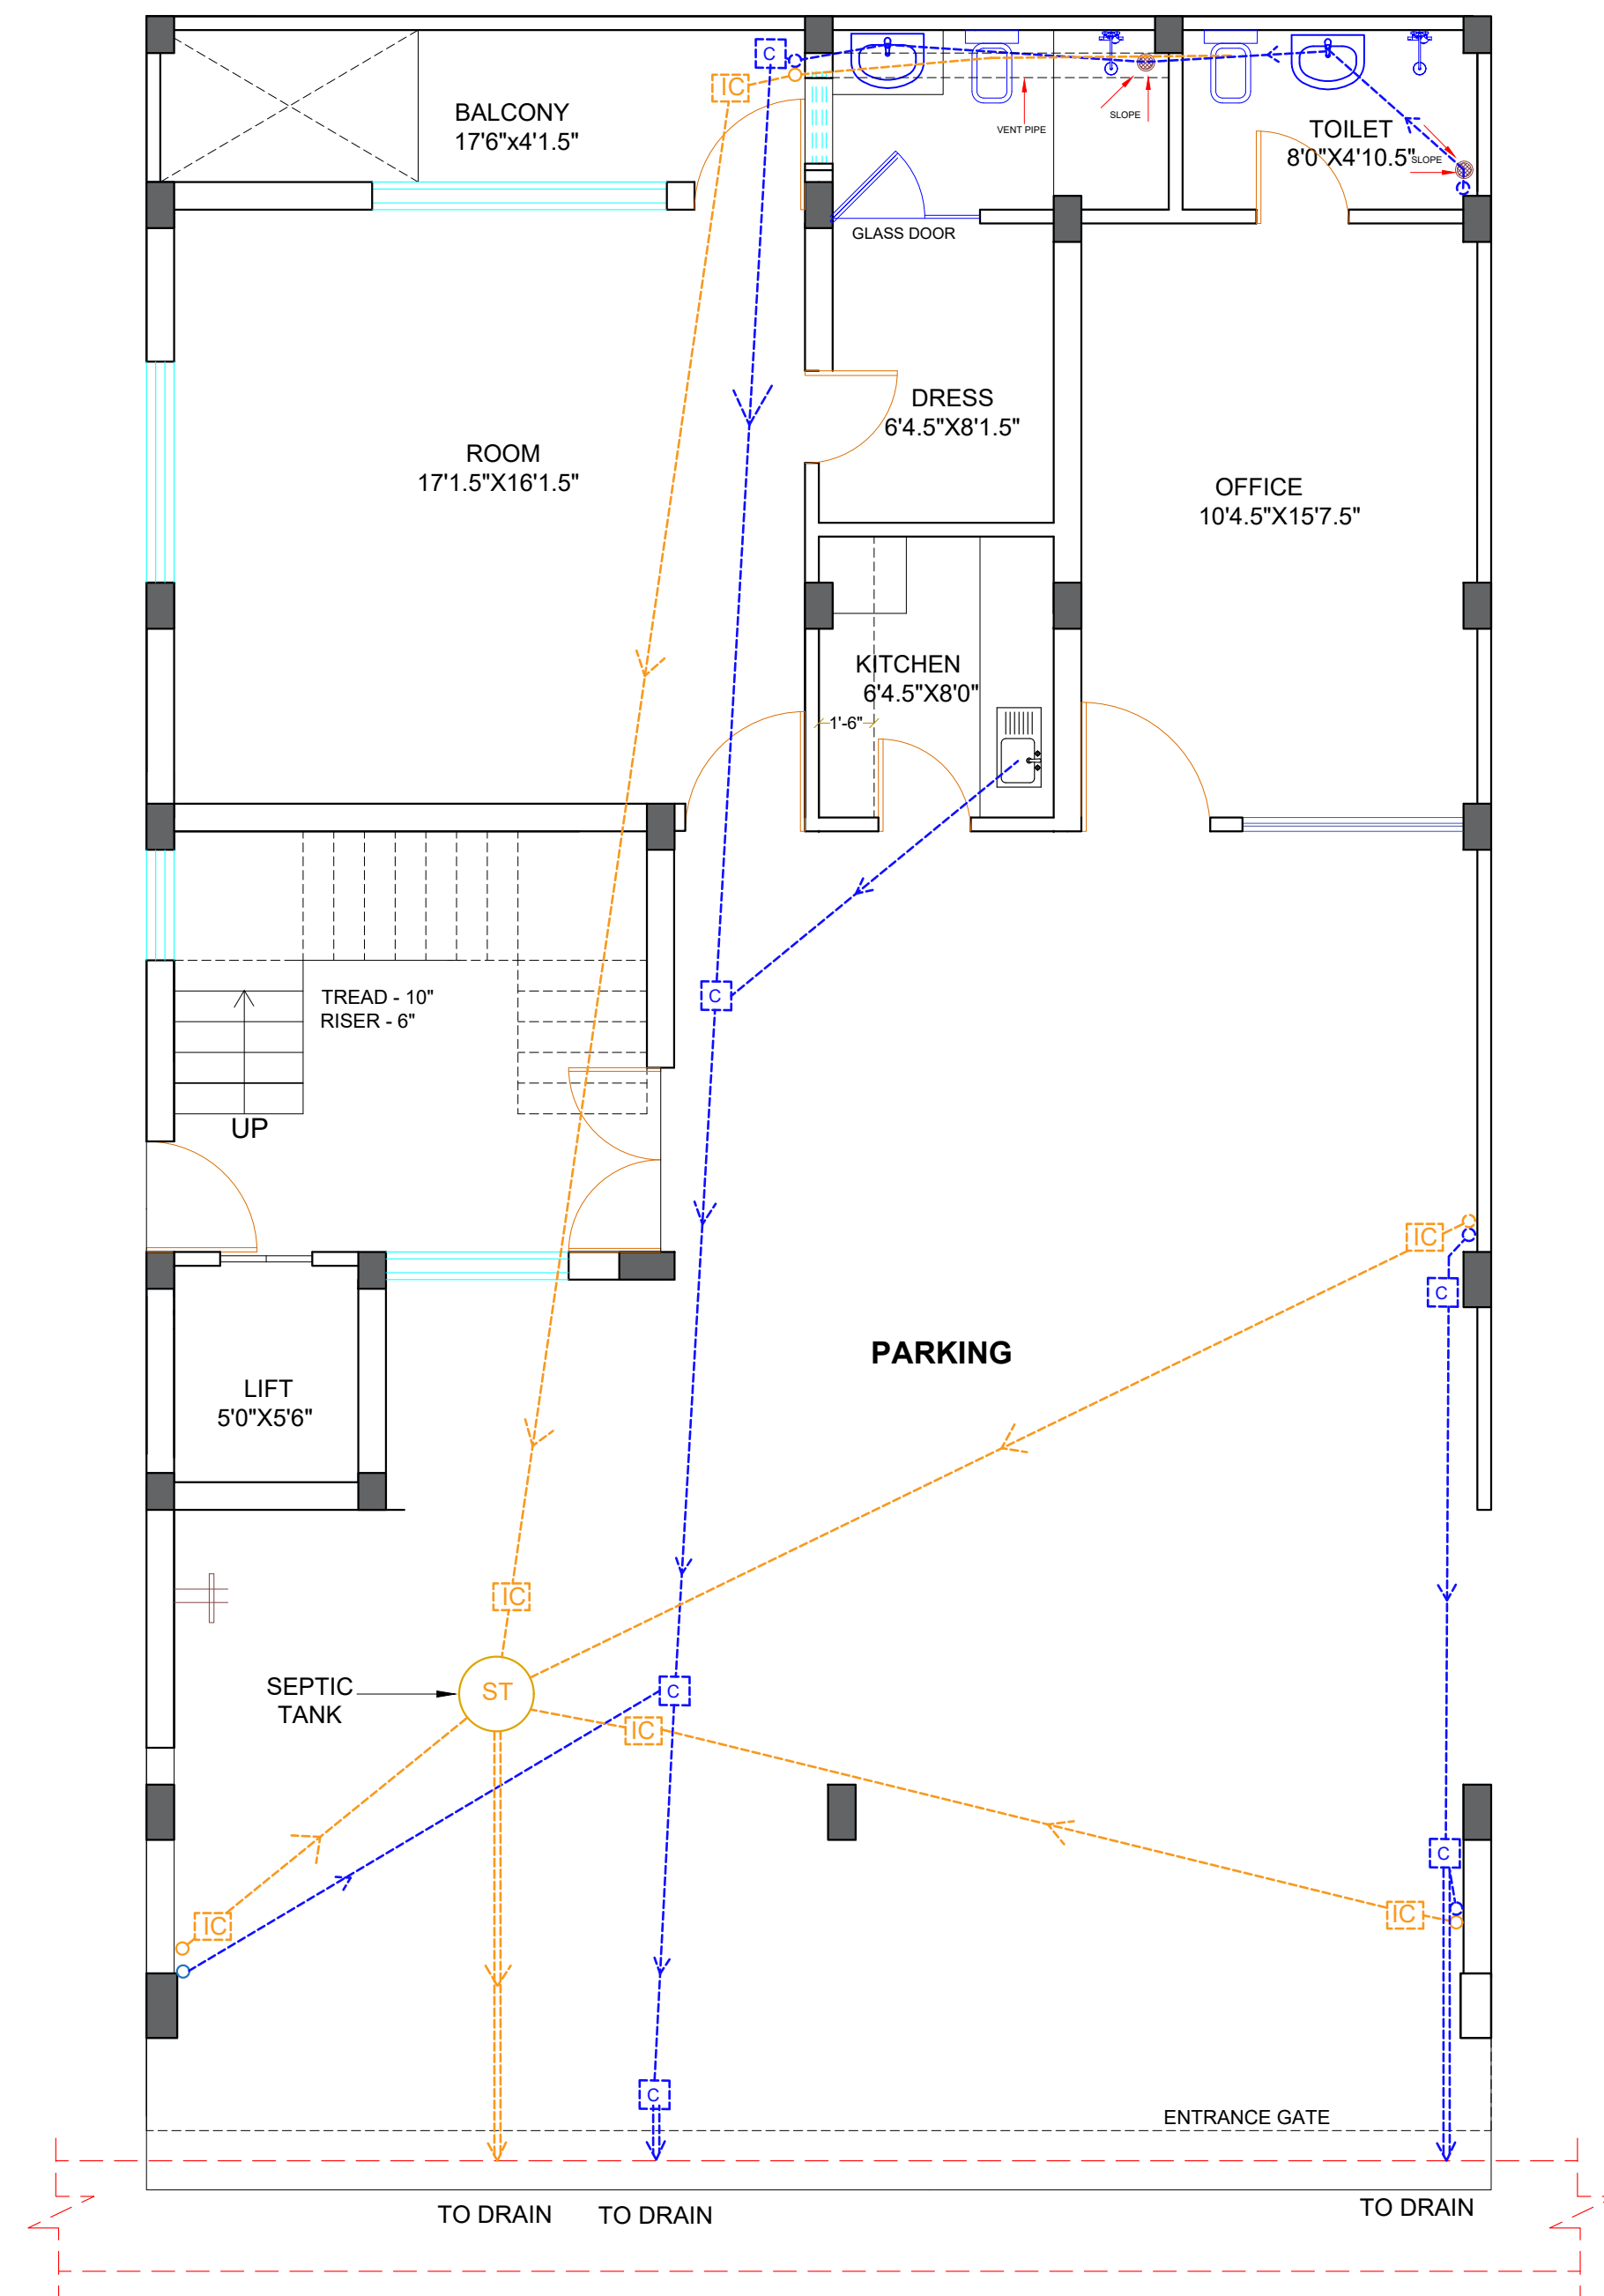

**GROUND FL. SANITARY PLAN
(PLOT 51)**

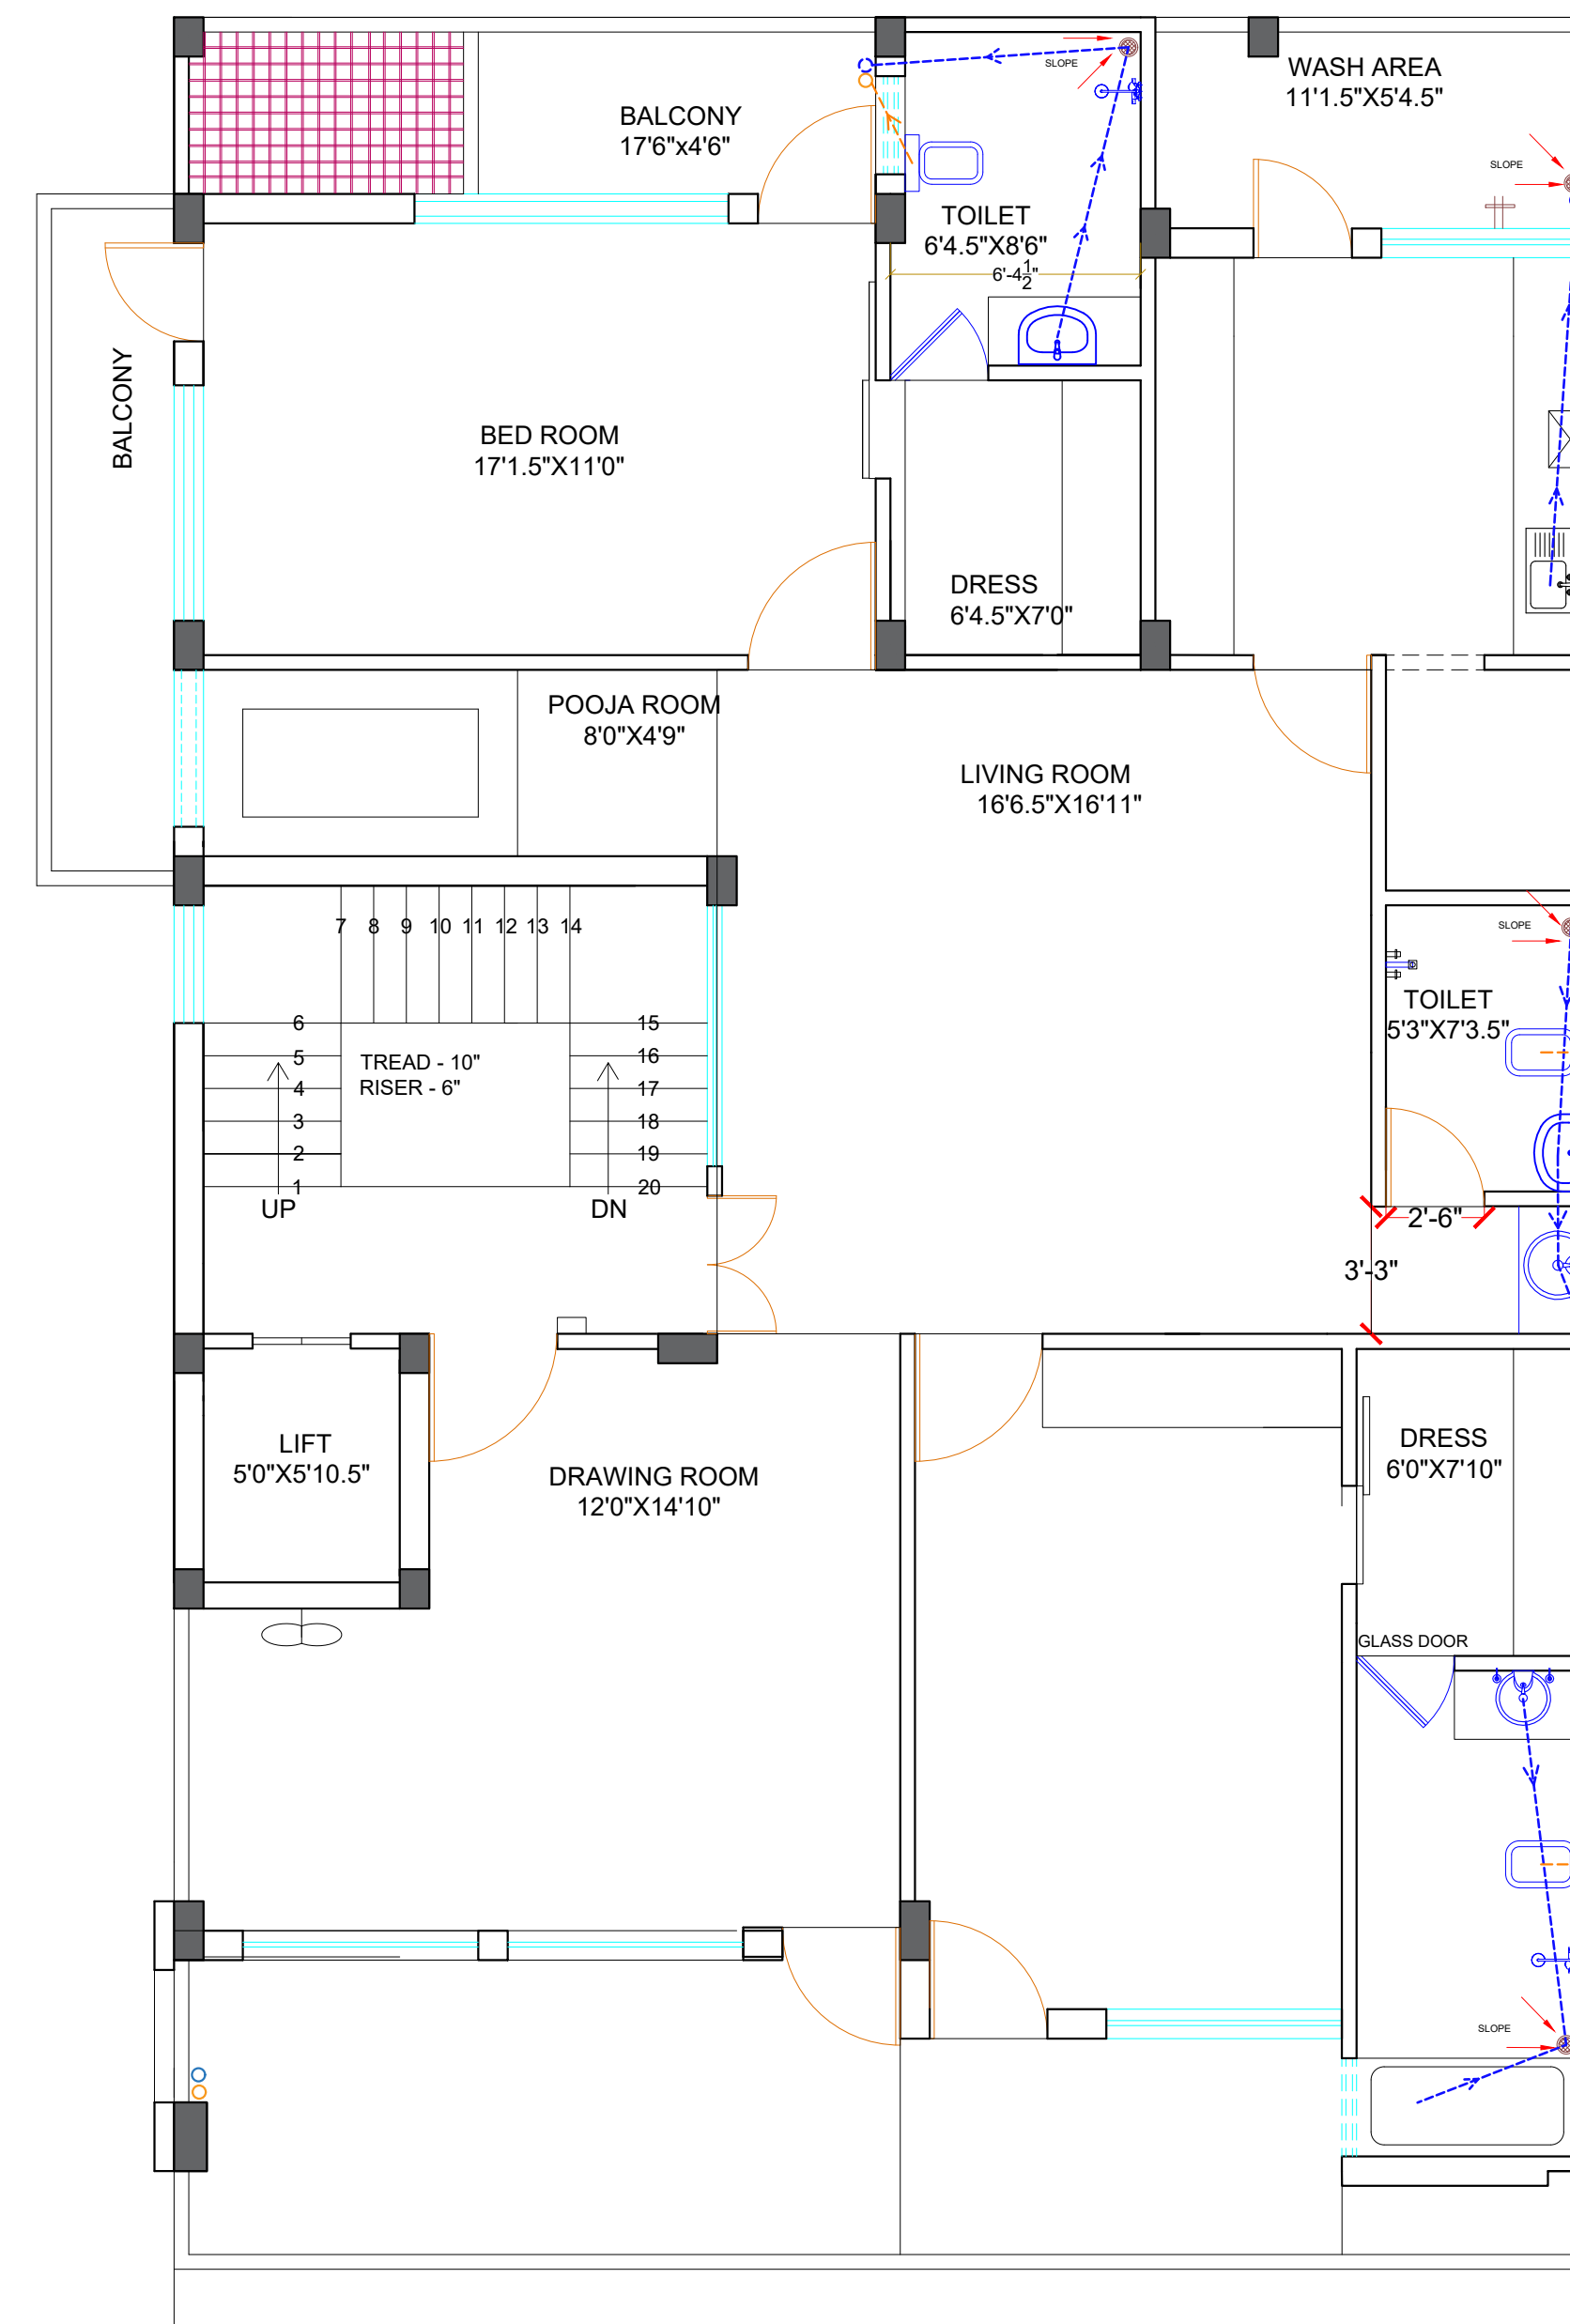

**FIRST FL. SANITARY PLAN
(PLOT 51)**

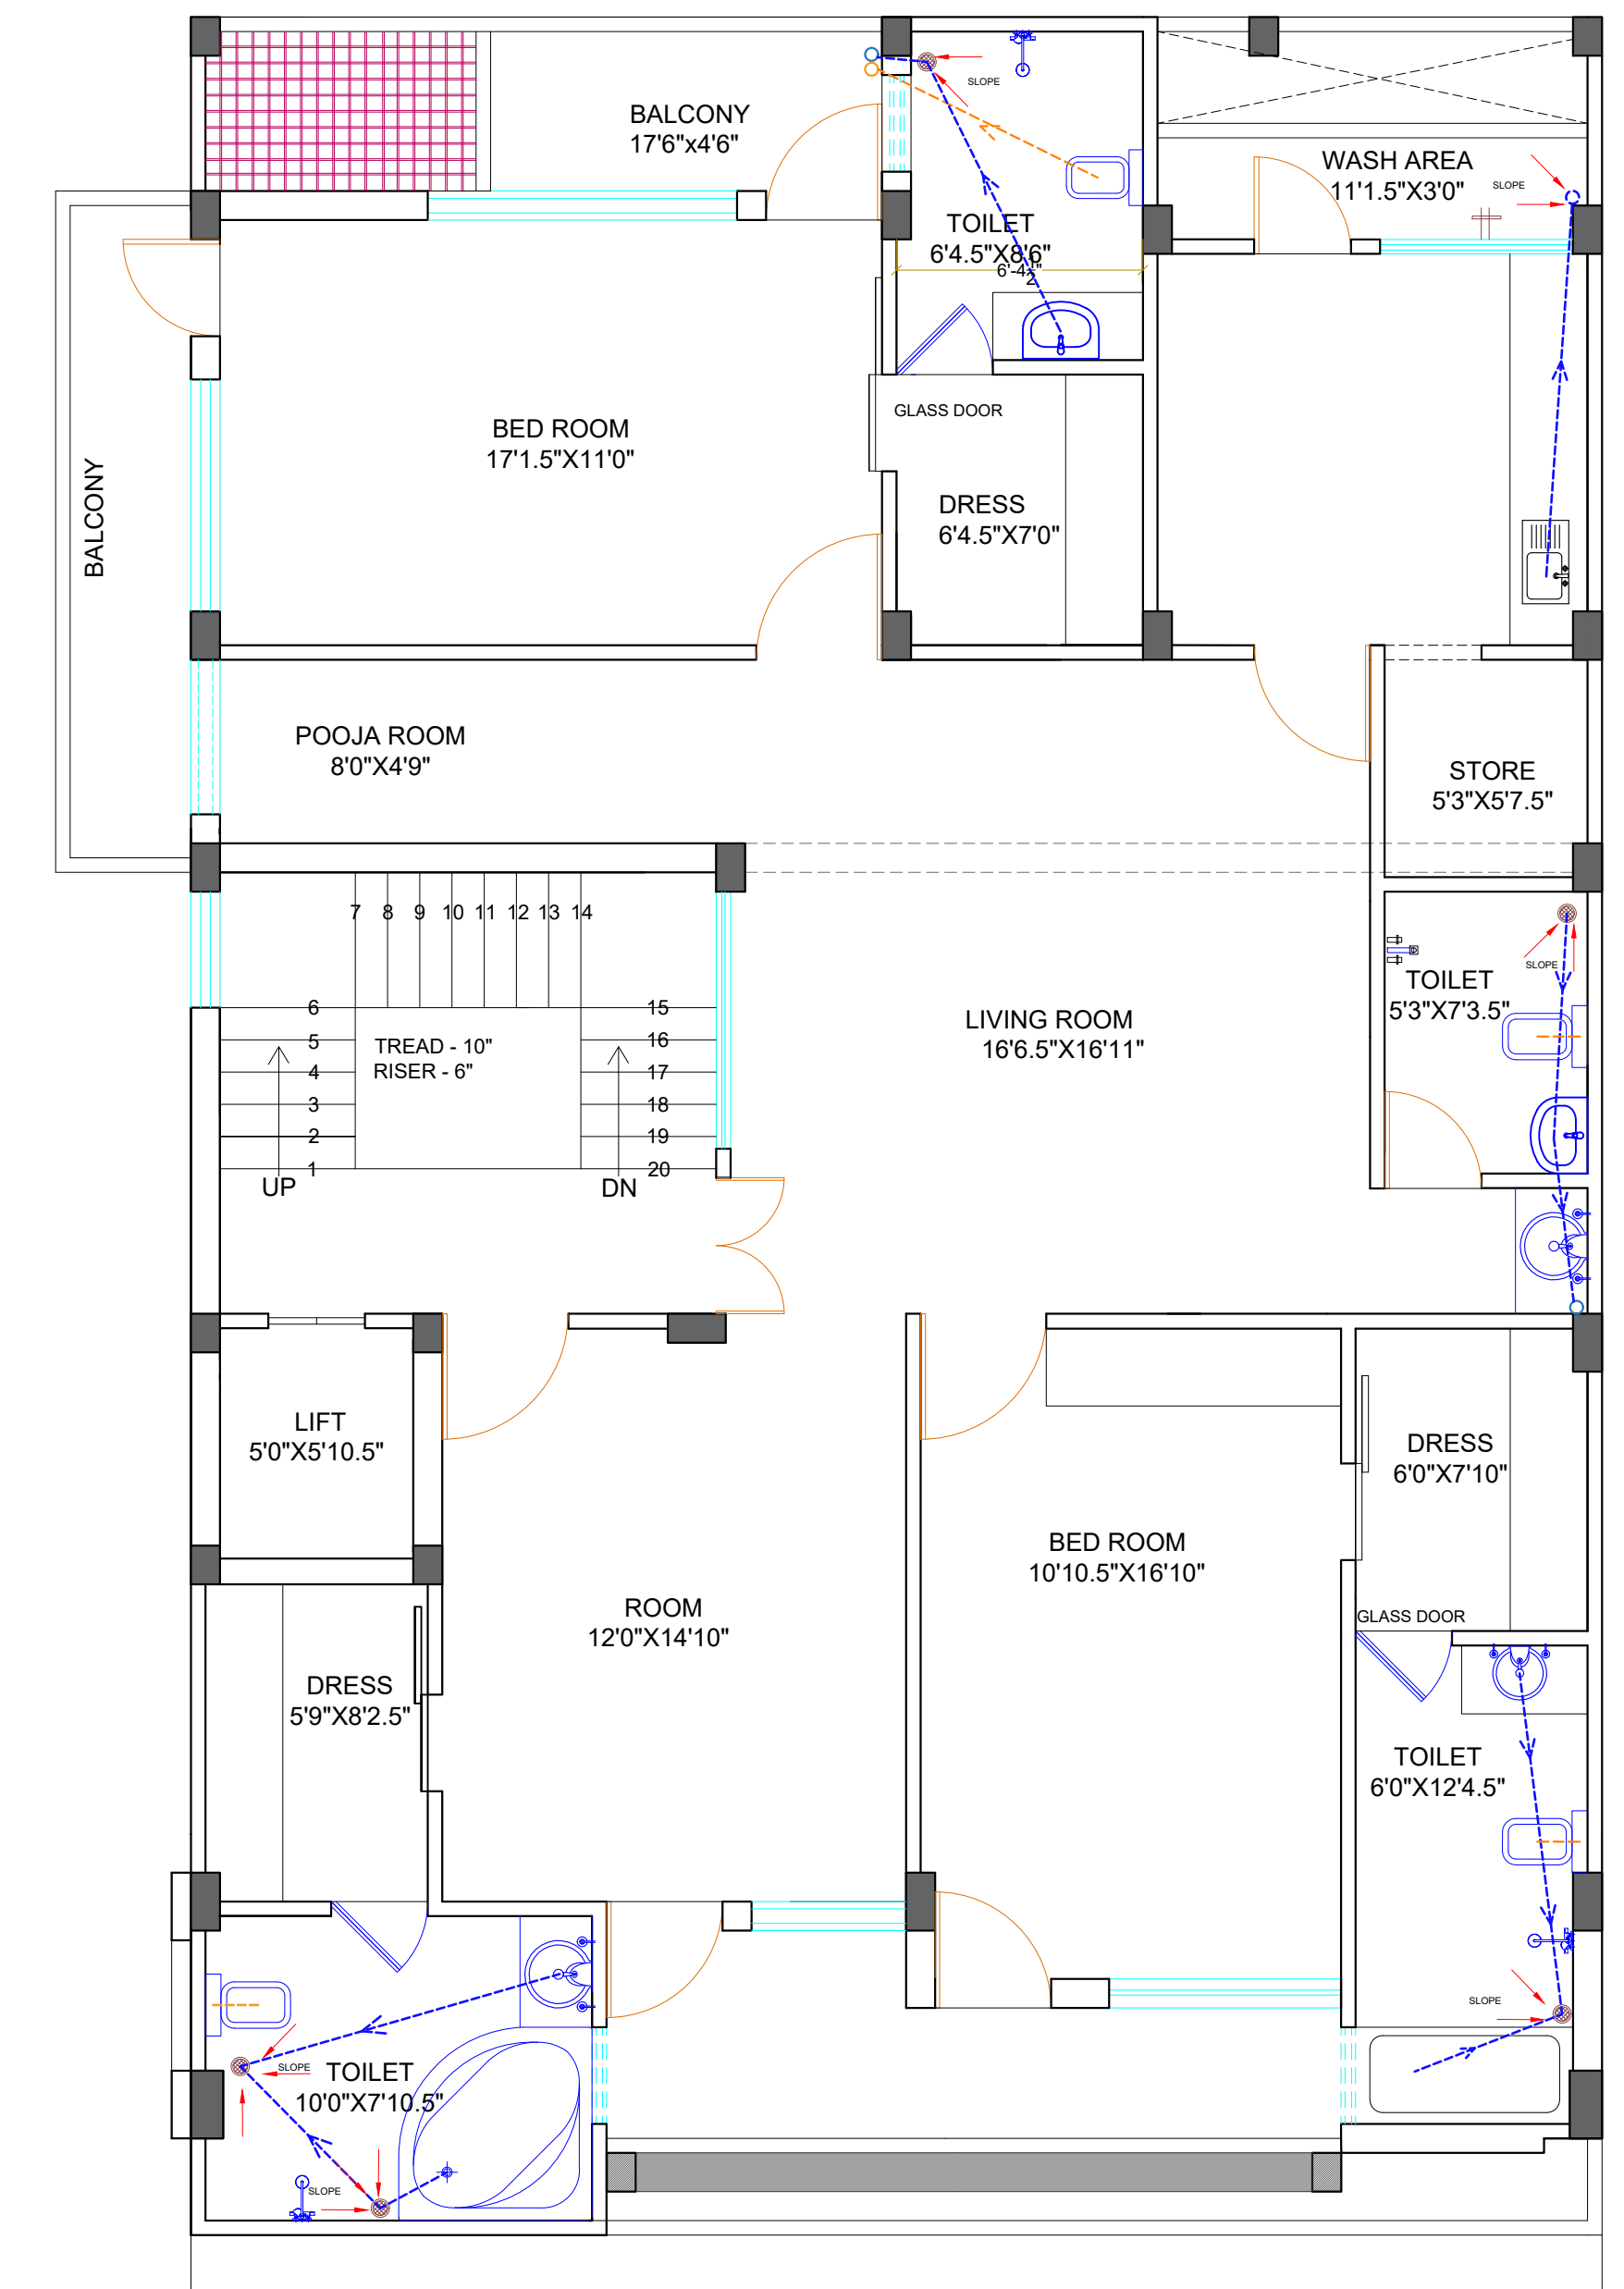

**SECOND FL. SANITARY PLAN
(PLOT 51)**

PROJECT NAME - MR. NEERAJ GUPTA

DRAWING NAME - WORKING DRAWINGS












- Only written dimension should be followed.
- All dimension should be checked by contractor and any discrepancy in them shall be brought to the notice of Architect before execution.
- Structure details (beam & column) taken here are as given by structural engineer.
- All dimensions are feet & inch.

DRAWN BY -ADITYA

CHECKED BY -DEVENDRA

DATE -21 - 03 - 2023



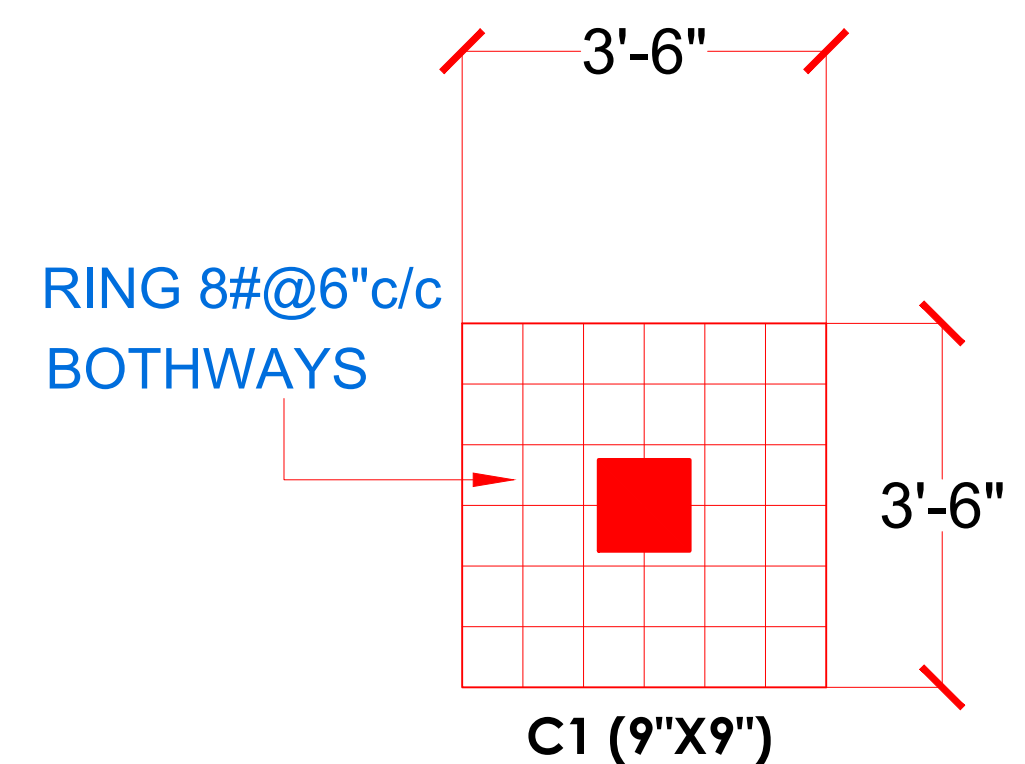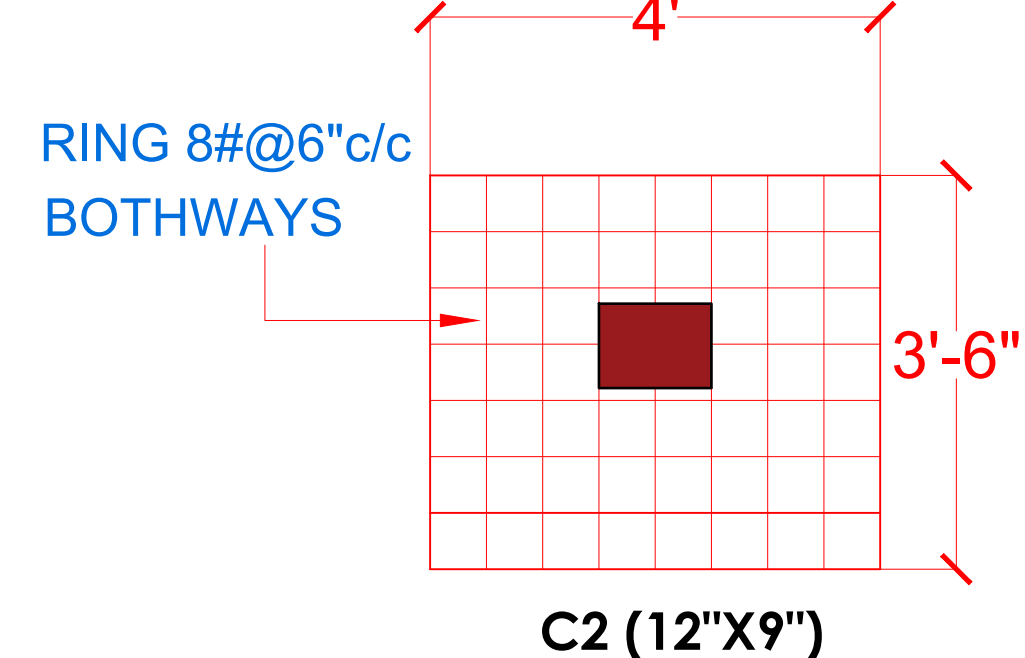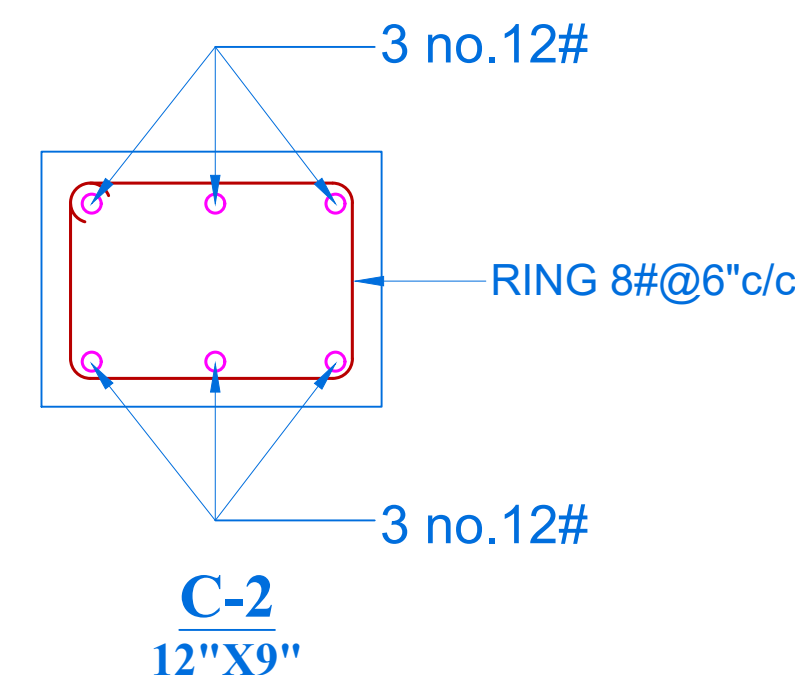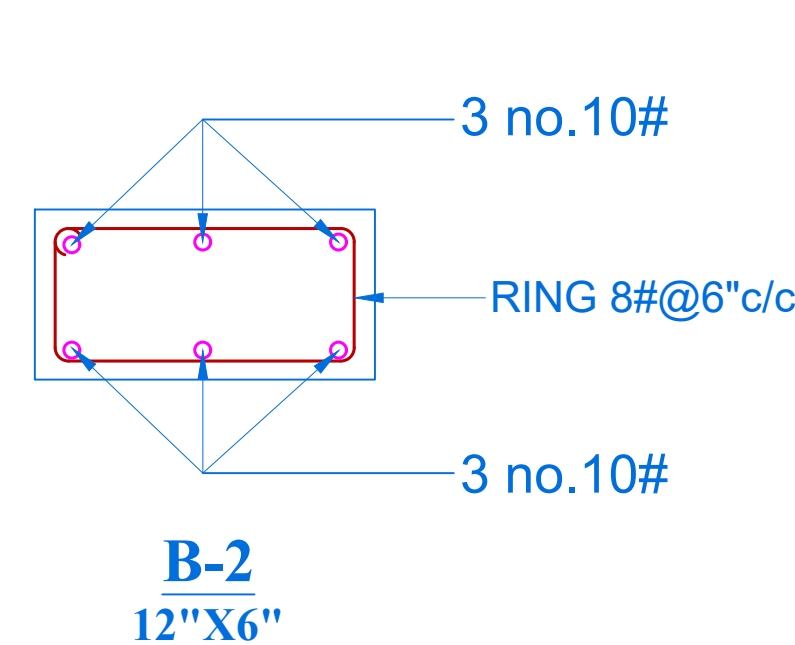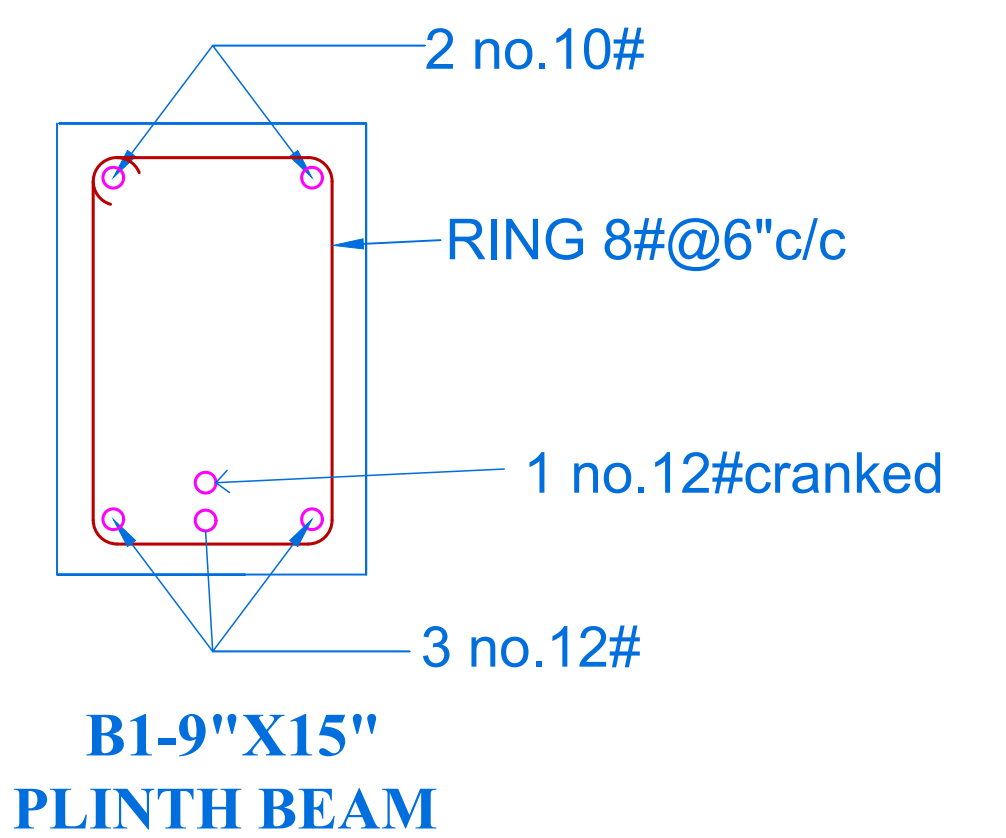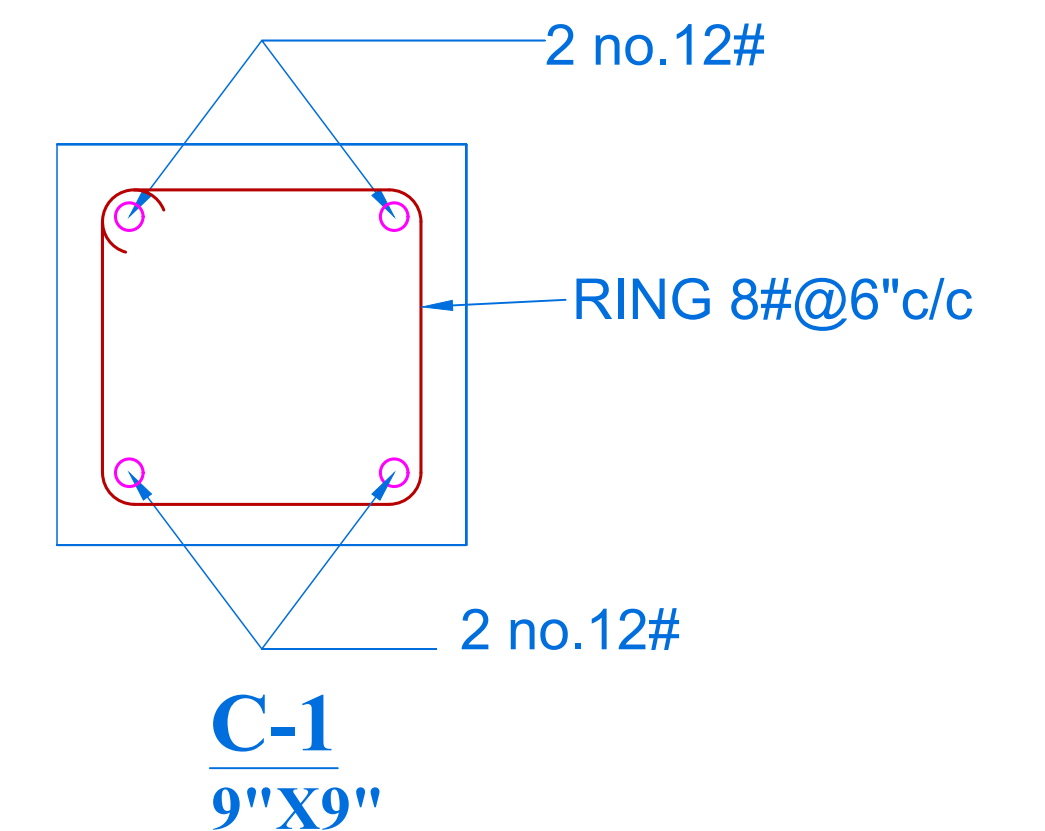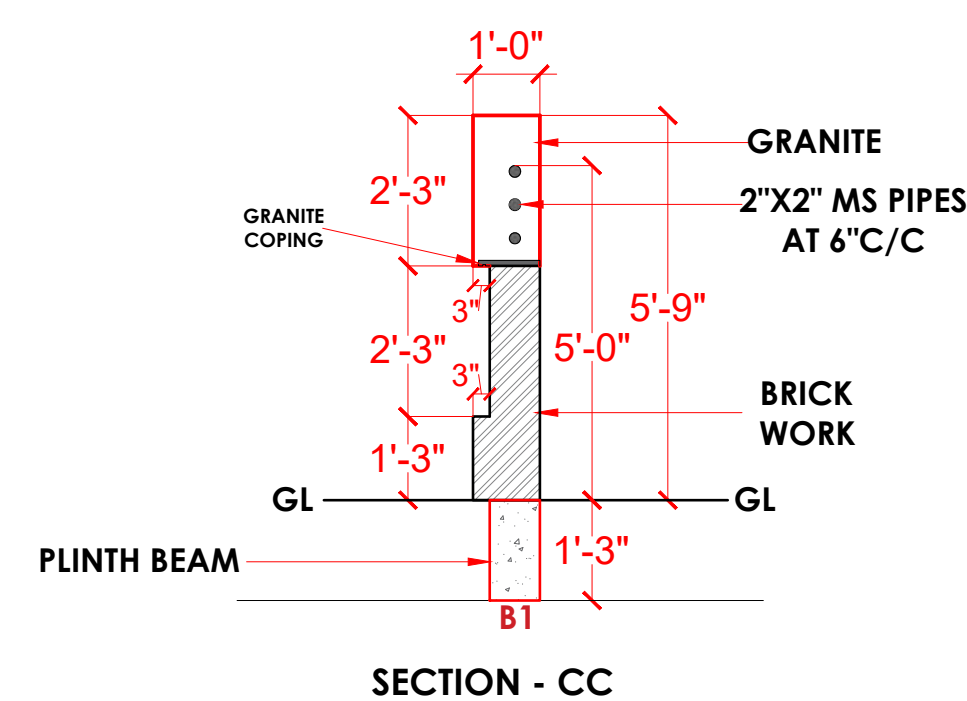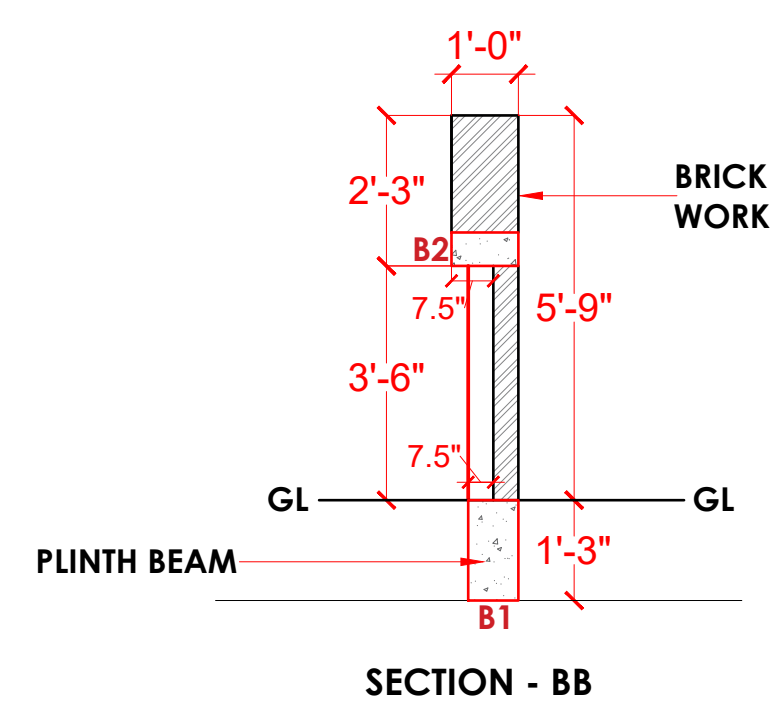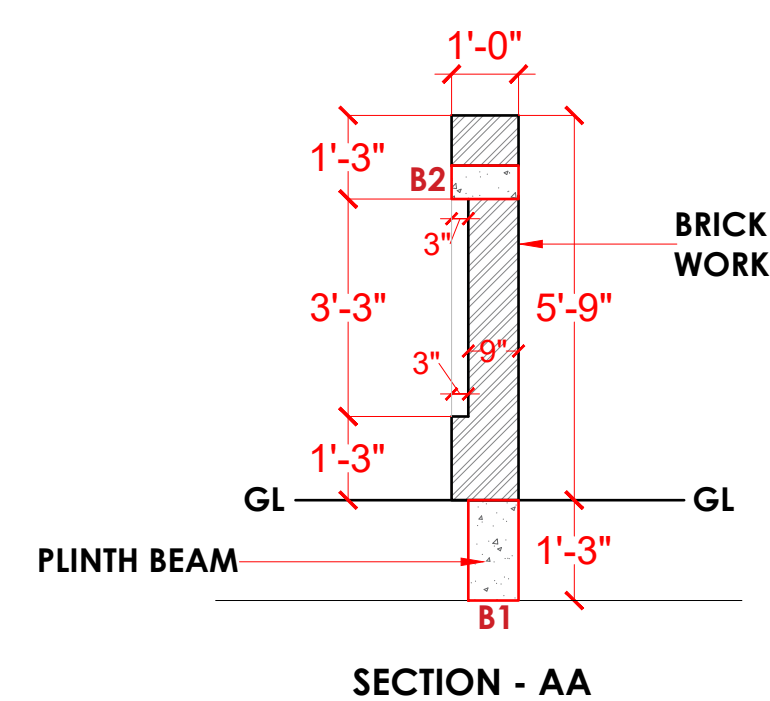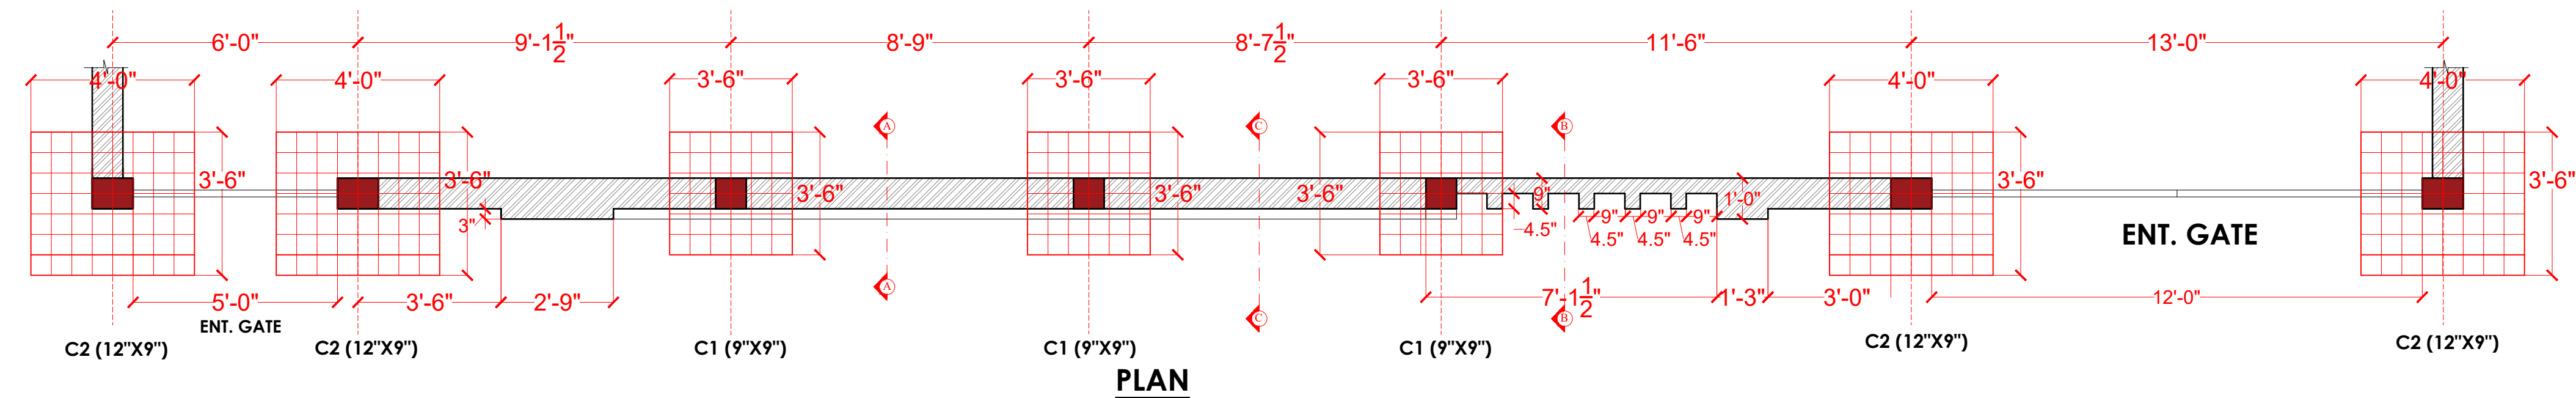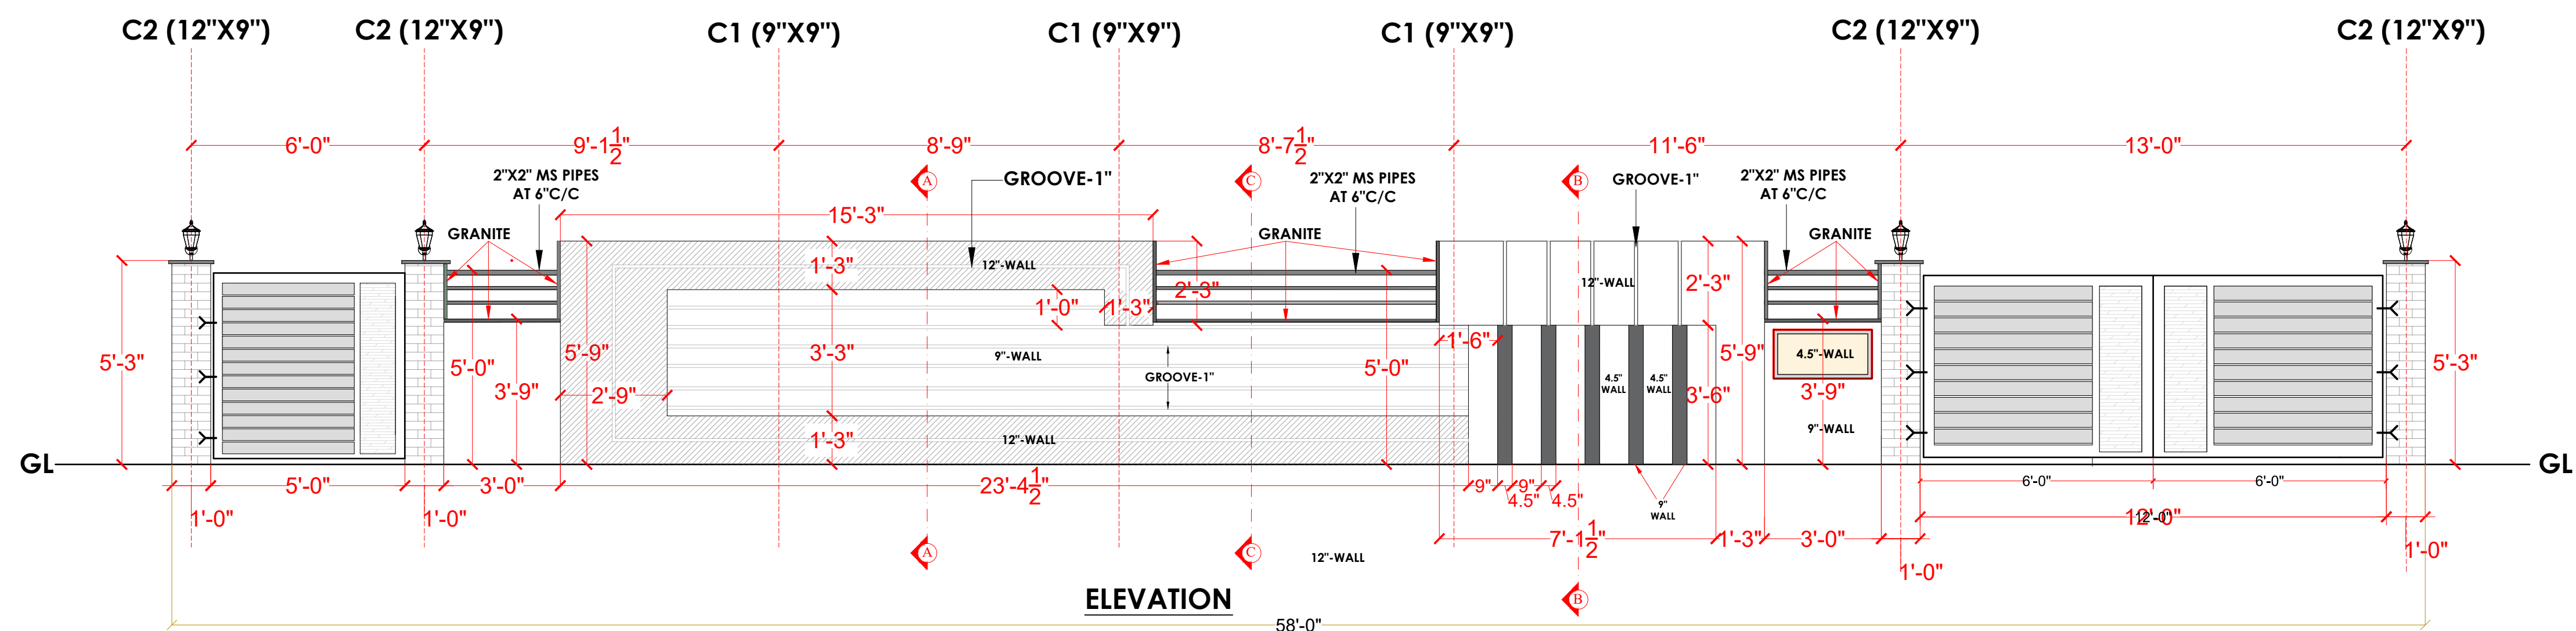

PROJECT NAME - MR. NEERAJ GUPTA

DRAWING NAME - WORKING DRAWINGS

- Only written dimension should be followed.
- All dimension should be checked by contractor and any discrepancy in them shall be brought to the notice of Architect before execution.
- Structure details (beam & column) taken here are as given by structural engineer.
- All dimensions are feet & inch.

DRAWN BY -ADITYA

CHECKED BY -DEVENDRA

DATE -21 - 03 - 2023

